

WINDOW SCHEDULE

MARK	WIDTH	HEIGHT	MANUFACTURER	MODEL	DETAIL			NOTES
					HEAD	JAMB	SILL	
A	7' - 11 1/2"	1' - 11 1/2"	Marvin Windows and Doors	ESCA2620	8/A4.3	6/A4.3	5/A4.3	
B	2' - 11 1/2"	1' - 11 1/2"	Marvin Windows and Doors	ESCAP3020	8/A4.3	6/A4.3	5/A4.3	
Window Notes								
1. Contractor to field verify all rough openings prior to procurement.								
2. Contractor to provide spray foam insulation at shims.								
3. Contractor to provide self-adhesive flashing membrane at head, jamb and sill locations per manufacturer's recommendation.								
4. Contractor to provide all required hardware at egress window locations to meet code.								
5. Window head height to be 9'-0" A.F.F.								

DOOR SCHEDULE


Door #	Width	Height	Thickness	Door Type	Frame Type	Details		Notes
						Jamb	Head	
100	4' - 0"	8' - 0"	1 3/4"	WD-1	-	3/A3.2	4/A3.1	1, 3
102	4' - 0"	8' - 0"	1 3/4"	WD-1	-	3/A3.2	4/A3.1	1, 3
106	5' - 6"	8' - 0"	1 3/4"	WD-1	-	4/A4.3 (Sim.)	7/A4.3 (Sim.)	1, 3
108A	(2) 3' - 0"	8' - 0"	1 3/4"	WD-1	-	4/A4.3	7/A4.3	1, 2
108B	(2) 3' - 0"	8' - 0"	1 3/4"	WD-1	-	4/A4.3	7/A4.3	1, 2
110	(2) 3' - 0"	8' - 0"	1 3/4"	WD-1	-	4/A4.3 (Sim.)	7/A4.3 (Sim.)	1, 2
114	(2) 3' - 0"	8' - 0"	1 3/4"	WD-1	-	4/A4.3 (Sim.)	7/A4.3 (Sim.)	1, 2
116	(2) 3' - 0"	8' - 0"	1 3/4"	WD-1	-	4/A4.3 (Sim.)	7/A4.3 (Sim.)	1, 2
DOOR NOTES								
1. Wood Door - Basis of Design: Rustica Double X Exterior Barn Door - Wood Species: Cedar - Finish: ST-1								
2. Barn Door Hardware - Basis of Design: Rustica Bi Parting Barn Door Hardware - Hanger Style: Stag - Handle Style: Moor 12 In. - Finish: Flat Black - Verify Locking Mechanism w/Owner								
3. Barn Door Hardware (Single Door) - Basis of Design: Rustica Outdoor Barn Door Hardware - Hanger Style: Stag - Handle Style: Moor 12 In. - Finish: Flat Black - Lock: Barn Door Hook								

FINISH SCHEDULE

SPACE		FLOORING	BASE	WALLS				CEILING		CABINETRY	NOTES
ROOM	NO.			NORTH	SOUTH	EAST	WEST	FINISH	HEIGHT		
Meds Room	100	Conc.	FRP-1	PT-1/FRP-1	PT-1/FRP-1	PT-1/FRP-1	PT-1/FRP-1	PT-1	See RCP	CB-1	
Lockers	102	Conc.	WB-1	WD-1	WD-1	WD-1	WD-1	Exp.	See RCP	-	
Helmets	104	Conc.	WB-1	WD-1	WD-1	WD-1	WD-1	Exp.	See RCP	-	
Tack Room	106	Conc.	WB-1	WD-1	WD-1	WD-1	WD-1	Exp.	See RCP	-	
Stalls	108	Conc./Exp.	WB-1	-	-	SS-1	SS-1	Exp.	See RCP	-	
Sick Horse Bay	110	Exp.	WB-1	WD-1	WD-1	WD-1	WD-1	Exp.	See RCP	-	
Hay Storage	112	Conc.	WB-1	-	-	-	SS-1	Exp.	See RCP	-	
Sick Horse Bay	114	Exp.	WB-1	WD-1	WD-1	WD-1	WD-1	Exp.	See RCP	-	


FINISHES LEGEND

PAINT and STAIN:				WOOD:			
PT-1	Interior Paint	Walls	Sherwin Williams - SW 9588 - High Sierra - eg-shel	WD-1	Wood Boards	Wood Finishes	3/4" Wd. Boards - Stain: ST-1 - Species: Cedar
ST-1	Exterior Stain	Wood Finishes	Verify finish w/Architect	FIBER REINFORCED PLASTIC			
				FRP-1	FRP	Meds Room	Marlite - Digitally Printed Plank - Finish: Willow Bark 5344-S4
				METAL:			
FLOORING:				M-1	Fascia, Trim, Etc.	Exterior	EDCO Fascia and Trim - Color: Statuary Bronze
CONC-1	Burnished Concrete	First Floor	Matte Finish	M-2	Gutter	Exterior	EDCO Rainware - Size: 3" x 4" - Color: Statuary Bronze
				M-3	Downspout	Exterior	EDCO Rainware - Color: Statuary Bronze
				M-4	Outside Corner Trim	Exterior	MAC Metal Architectural - M21H Molding - Color: Match Siding
				M-5	Inside Corner Trim	Exterior	MAC Metal Architectural - M22H Molding - Color: Match Siding
				M-6	Window Sill	Exterior	MAC Metal Architectural - M04H Molding - Color: Match Siding
EXTERIOR SOFFIT & CLADDING:				M-7	Cladding Starter Strip	Exterior	MAC Metal Architectural - M17H Molding - Color: Match Siding
SS-1	Prefinished Stl. Siding	Exterior	MAC Metal Architectural - Board and Batten - Finish: Cork	M-8	Top of Wall Trim	Exterior	MAC Metal Architectural - M04H Molding - Color: Match Siding
MS-1	Prefinished Mtl. Soffit	Exterior	EDCO Vented Mtl. Soffit - Color: Statuary Bronze	M-9	Door Jamb	Exterior	MAC Metal Architectural - M05H Molding - Color: Match Siding
ROOFING				CASEWORK:			
AS-1	Asphalt Shingles	Exterior	Certainteed Landmark Shingles - Color: Driftwood	CB-1	Mtl. Cabinetry	Meds Room	Moduline - Pro Series - Finish: Textured Gray w/Black Anodized Frame
BASE:				Lockers:			
WB-1	Wood Base	Units	1x4 Cedar Board - Finish: ST-1	L-1	Mtl. Lockers	Meds Room	ASI Storage Solutions - Competitor Collection Single Tier Locker w/ - Size: 24 w x 24 d x 66 h - Finish: Black
NOTES:							
1. All Materials and Products to be installed per manufacturer's specifications							
2. All windows to have 1x cedar wd. at interior side of head, jamb, and sill - Finish: ST-1							

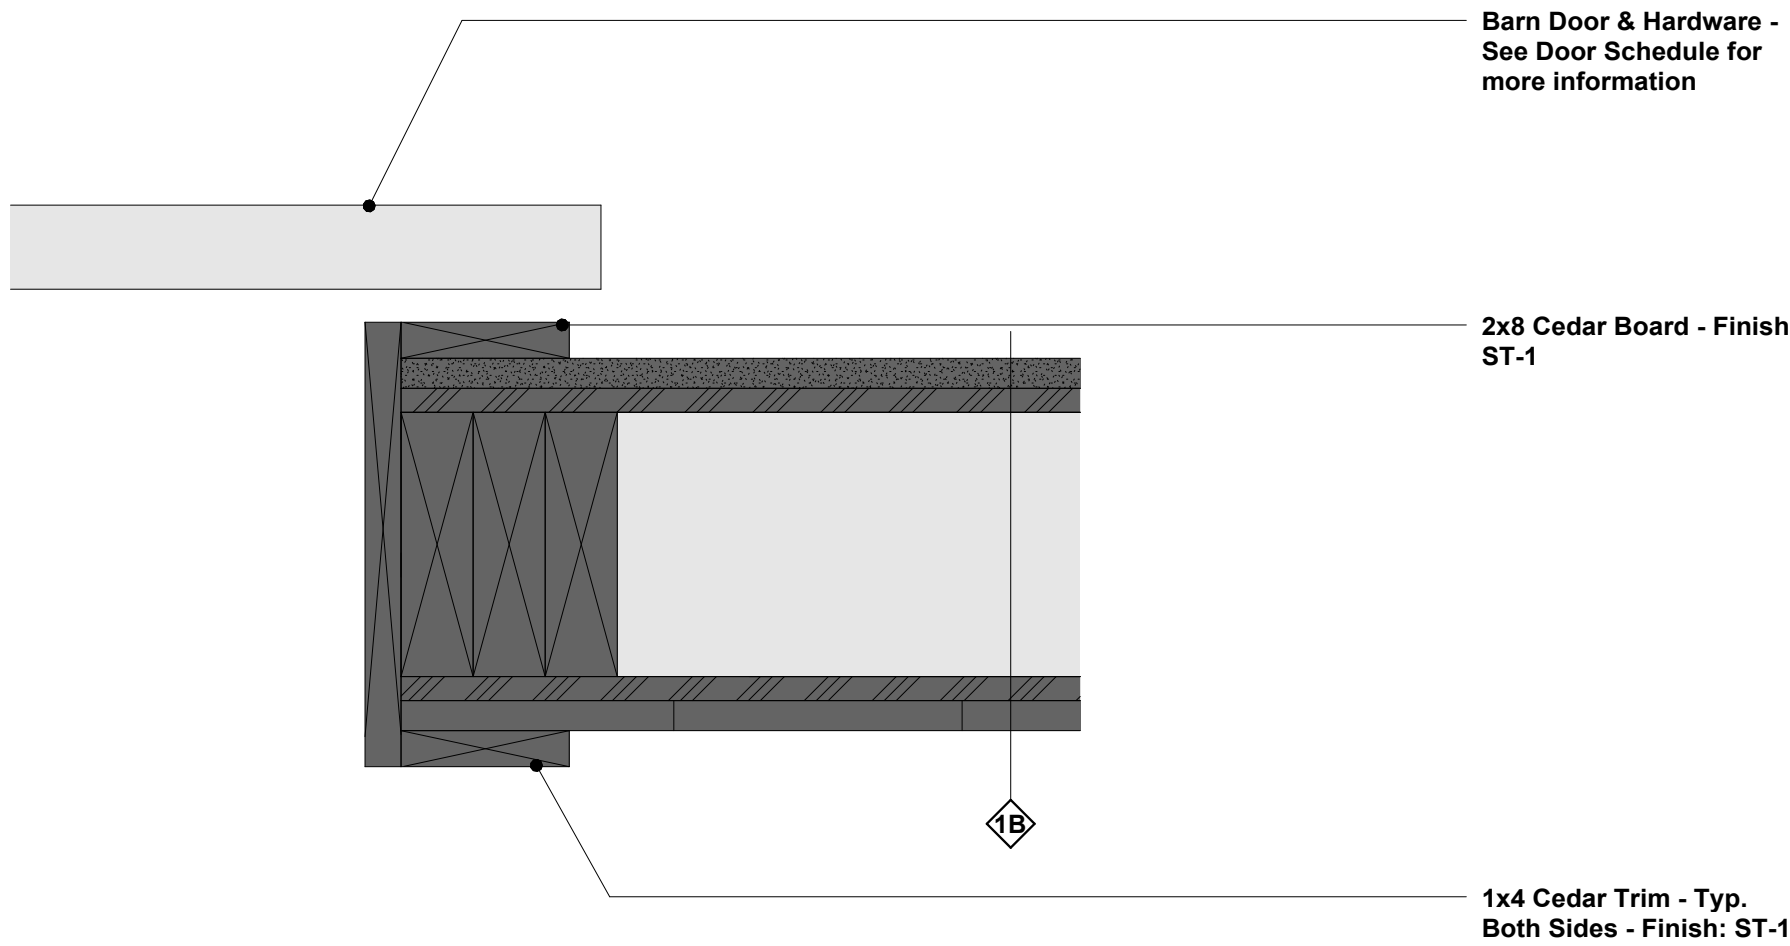


Int. Door Detail - Jamb

SCALE 3" = 1'-0"

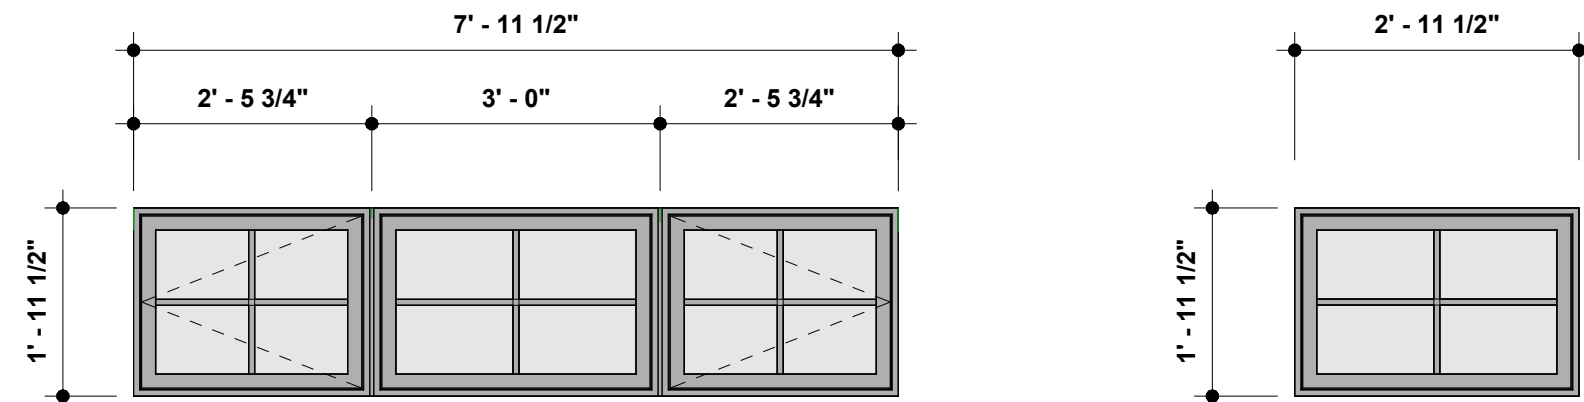


Window Elevations

SCALE 1/2" = 1'-0"

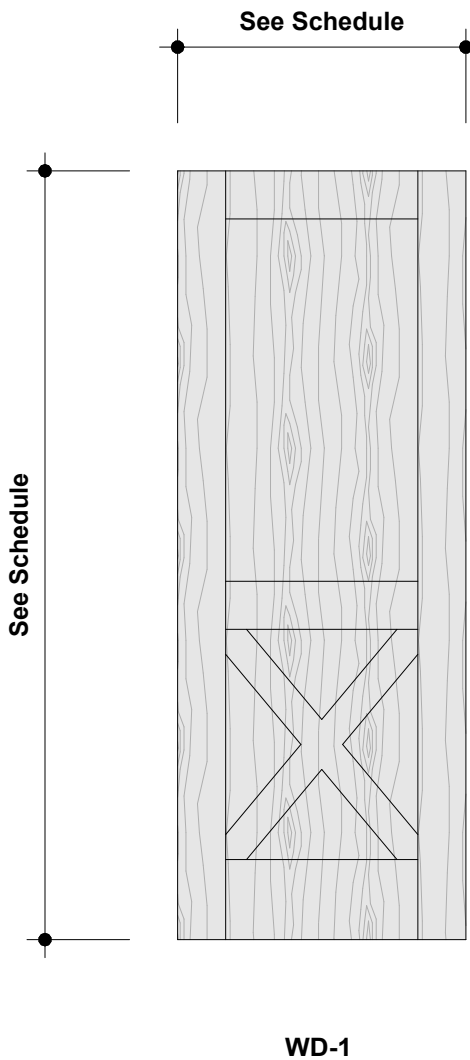

Door Elevations

SCALE 1/2" = 1'-0"

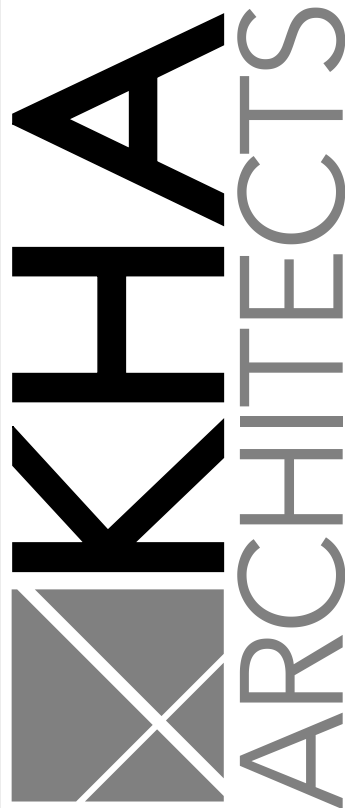

72-185 PAINTERS PATH
SUITE A
PALM DESERT, CA
92260
760.776.4068

INSTRUMENTS OF SERVICE
THESE DRAWINGS ARE AN INSTRUMENT
OF SERVICE AND REMAIN THE PROPERTY
OF KRISTI HANSON ARCHITECTS, INC.
THEY ARE NOT TO BE REPRODUCED OR
ALTERED IN ANY WAY, NOR DISCLOSED
OR ASSIGNED TO ANY THIRD PARTY
WITHOUT THE EXPRESS WRITTEN
PERMISSION OF KRISTI HANSON
ARCHITECTS, INC.

CITY APPROVAL:

TRMF RIDING STABLES - HORSE STALLS
14532 1-94 Loop East
ND 58645



REVISION LIST

SCHEMATIC	DESIGN REVIEW
DESIGN DEV.	
CONST. DOCS.	
	BUDG. DEPT.
CITY SUB. 1	
CITY SUB. 2	
	CONSTRUCTION
Addendum #2 09/01/2026	
CONSTR. REV 2	
CONSTR. REV 3	


PROJECT # : 2515

CONTACT : KRISTI

SCALE: AS NOTED

SCHEDULES




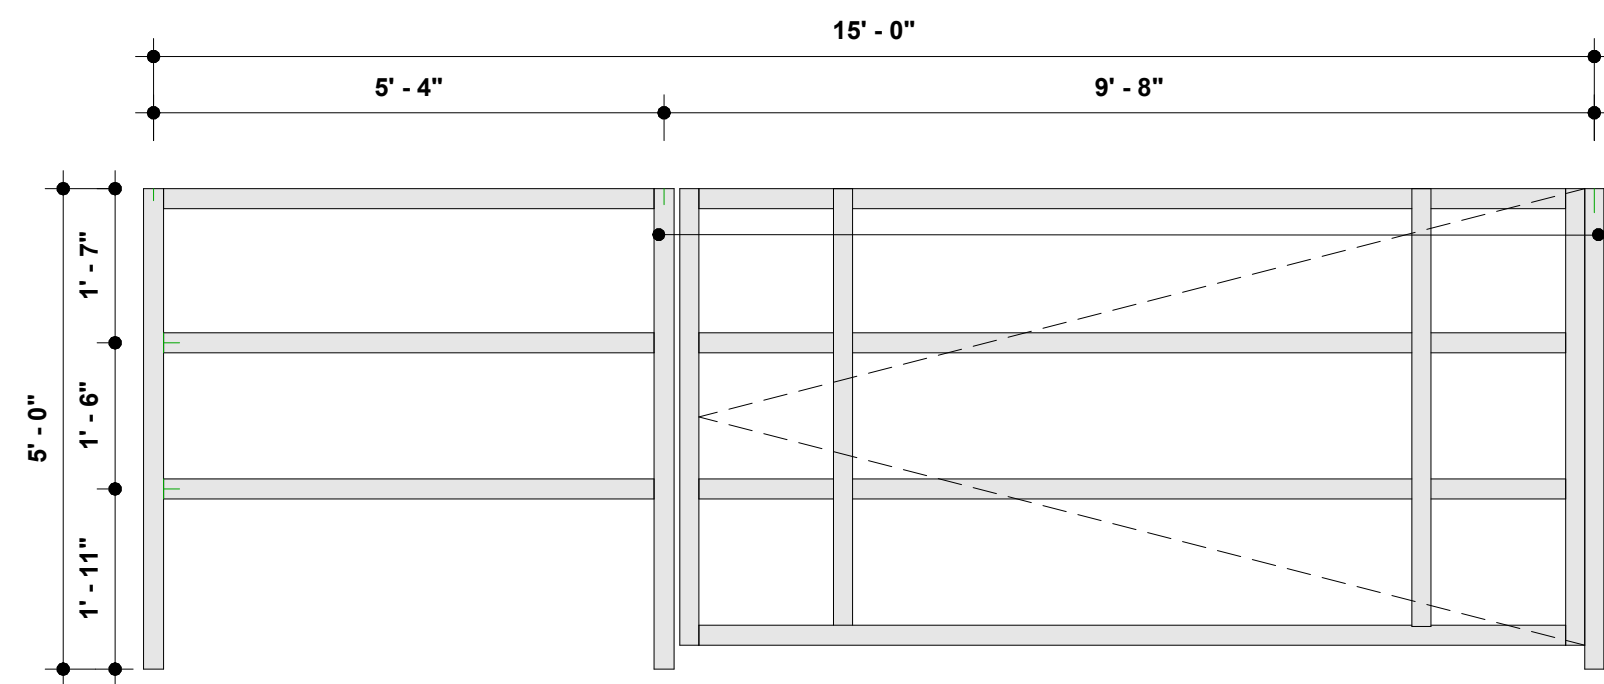

2 1/2" Dia. Stl Guardrail and Gate System - Finish: Hot Dip Galvanized - Powder Coat to Match Soffit/Fascia

Stall Gate Hardware:
Each Gate Shall Have:
(2) Heavy-Duty Adjustable J-Bolt Hinges (Min. 1" Dia. Threaded Bolt)
(1) Heavy-Duty Weld-On Drop-Fork Gate Latch w/locking mechanism

*Verify hinge weight requirements prior to procurement

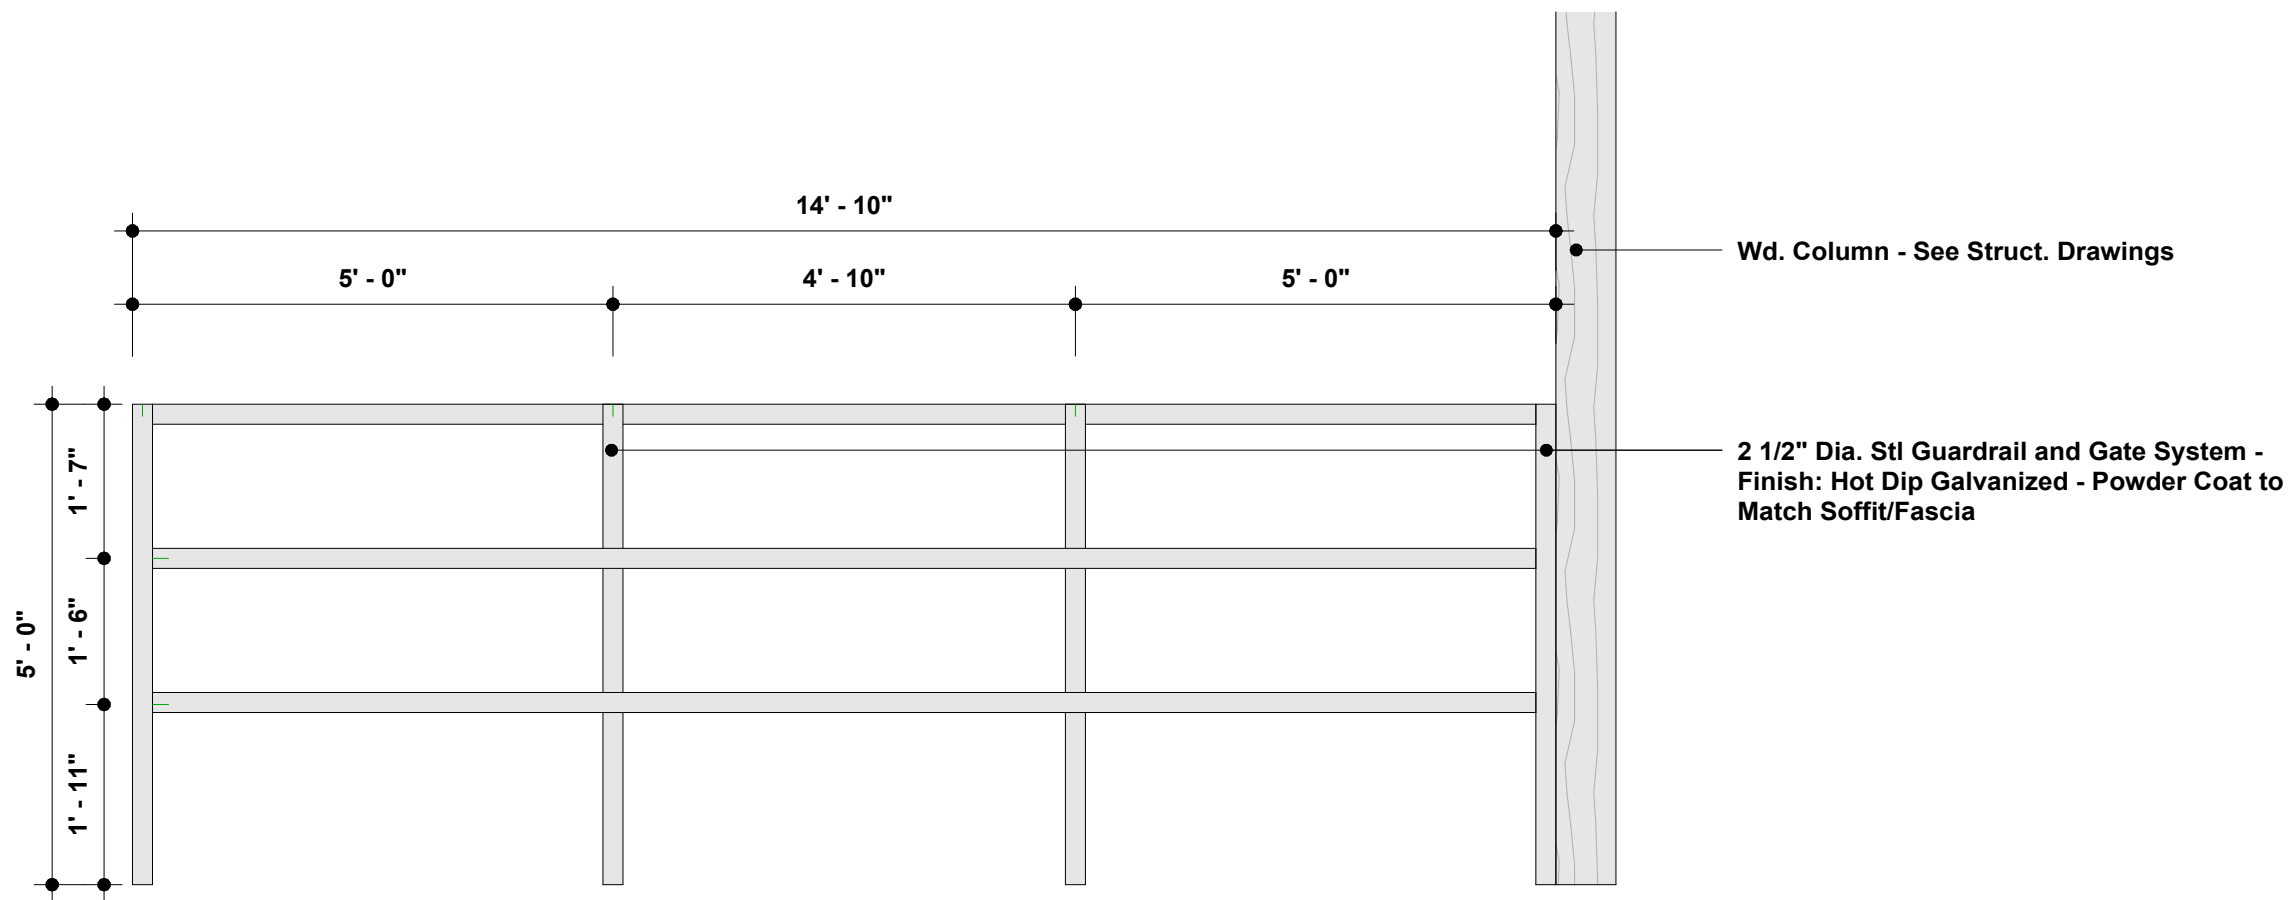

Wd. Column - See Struct. Drawings

2 1/2" Dia. Stl Guardrail and Gate System - Finish: Hot Dip Galvanized - Powder Coat to Match Soffit/Fascia

4

Horse Stall Gate Elevation - Typ.

SCALE 1/2" = 1'-0"

7


Horse Stall Fence Elevation - A

SCALE 1/2" = 1'-0"

3

Building Section - C

SCALE 1/8" = 1'-0"

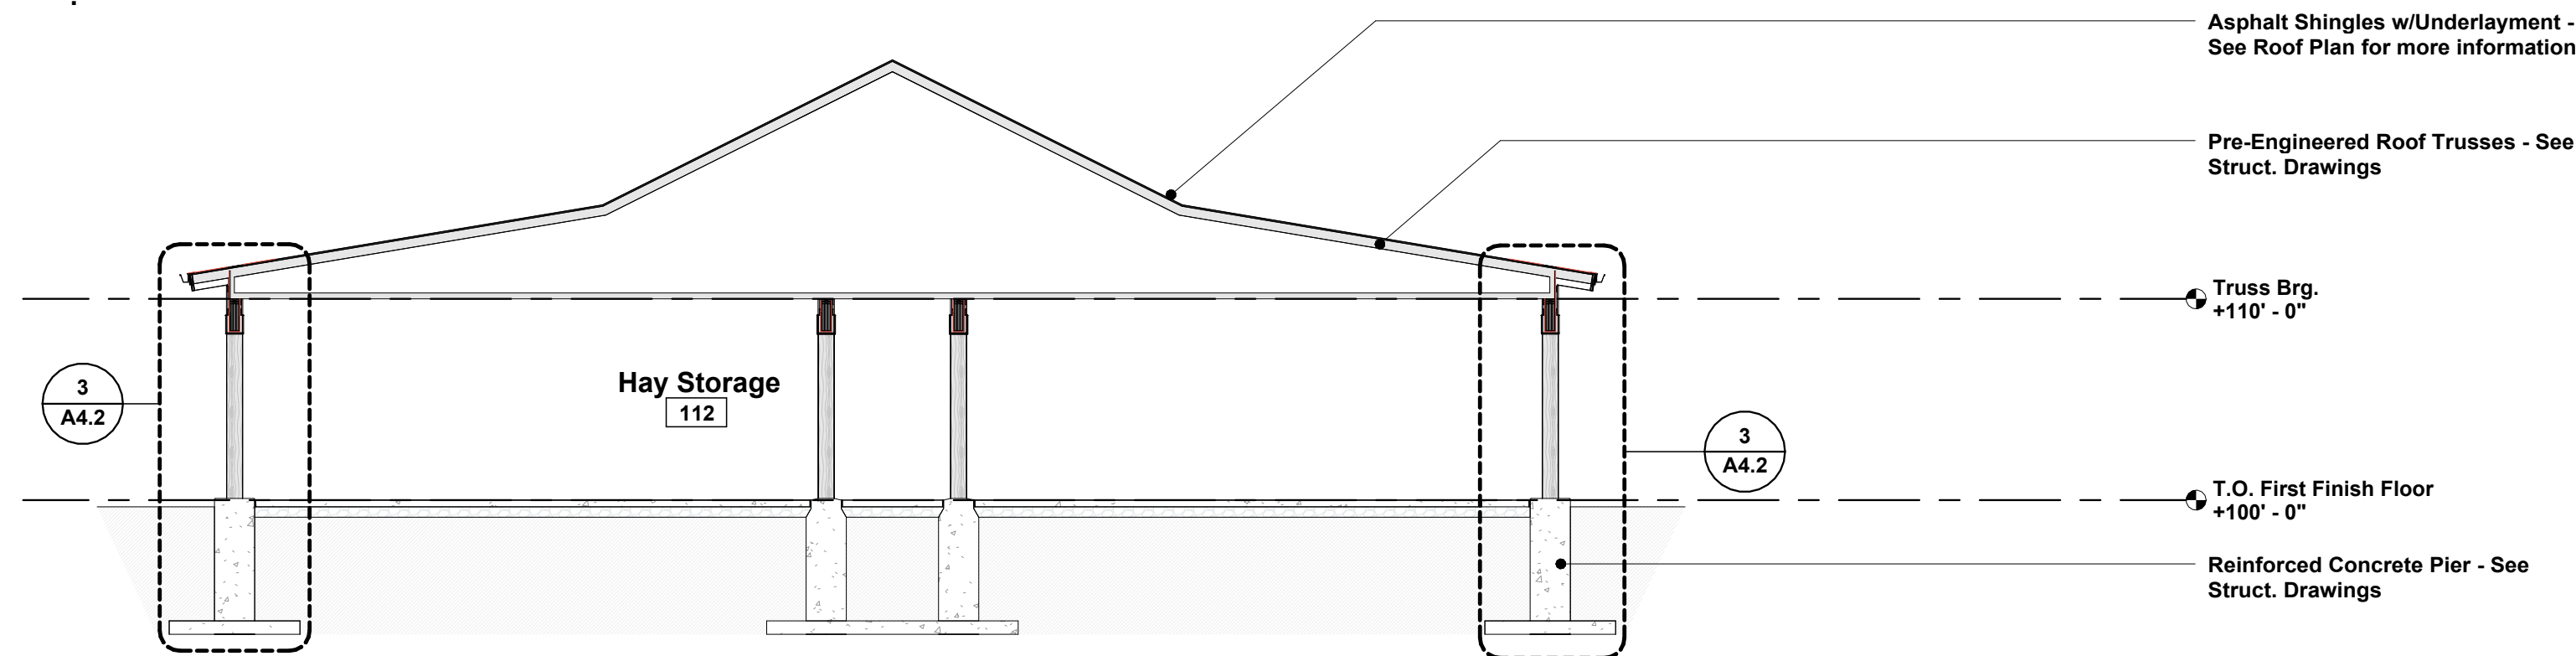


Asphalt Shingles w/Underlayment - See Roof Plan for more information

Pre-Engineered Roof Trusses - See Struct. Drawings

Truss Brg. +110' - 0"

T.O. First Finish Floor +100' - 0"

Reinforced Concrete Pier - See Struct. Drawings

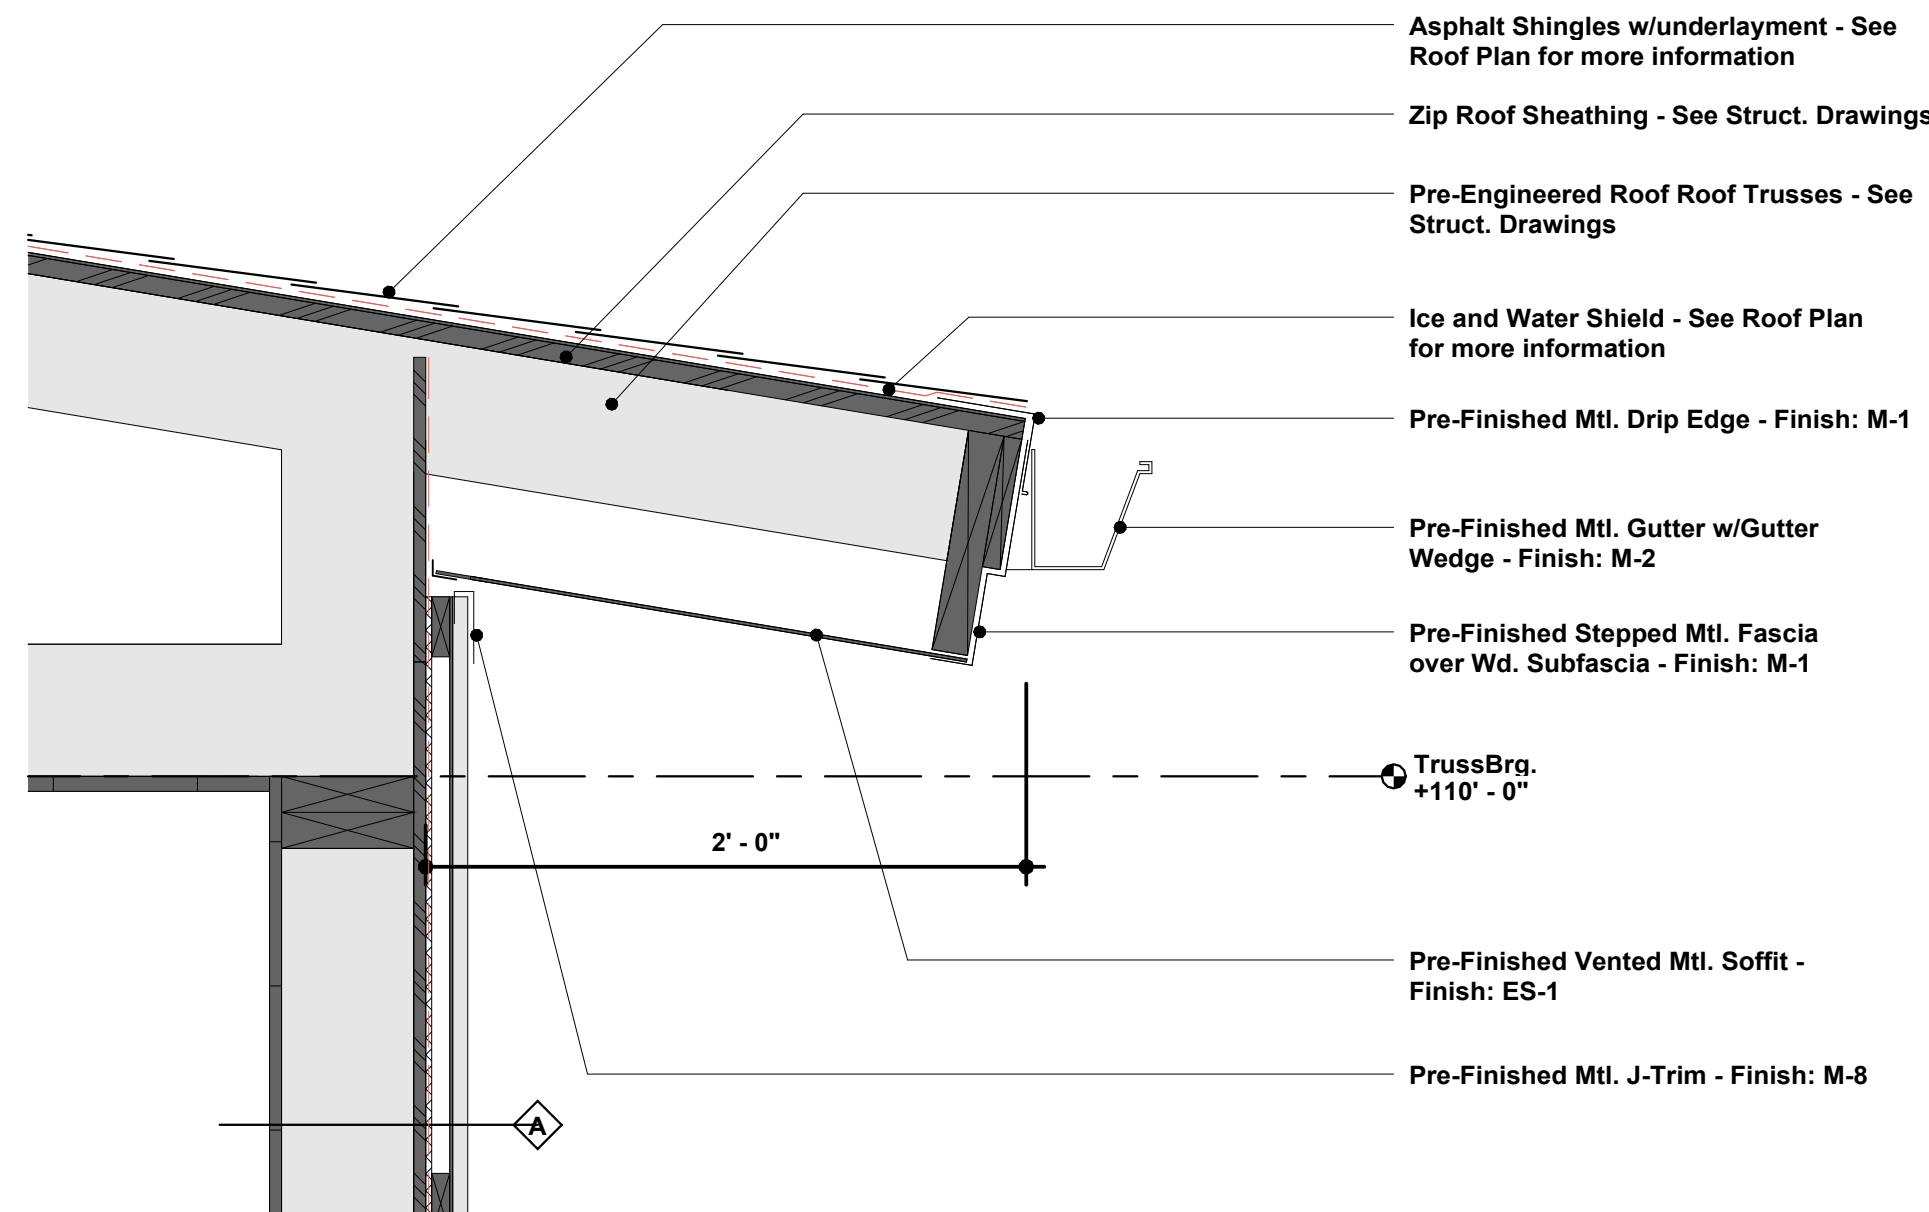

Asphalt Shingles w/underlayment - See Roof Plan for more information

Zip Roof Sheathing - See Struct. Drawings

Pre-Engineered Roof Trusses - See Struct. Drawings

Ice and Water Shield - See Roof Plan for more information

Pre-Finished Mtl. Drip Edge - Finish: M-1

Pre-Finished Mtl. Gutter w/Gutter Wedge - Finish: M-2

Pre-Finished Stepped Mtl. Fascia over Wd. Subfascia - Finish: M-1

Truss Brg. +110' - 0"

Pre-Finished Vented Mtl. Soffit - Finish: ES-1

Pre-Finished Mtl. J-Trim - Finish: M-8

6


Section Detail - Eave

SCALE 1 1/2" = 1'-0"

2

Building Section - B

SCALE 1/8" = 1'-0"

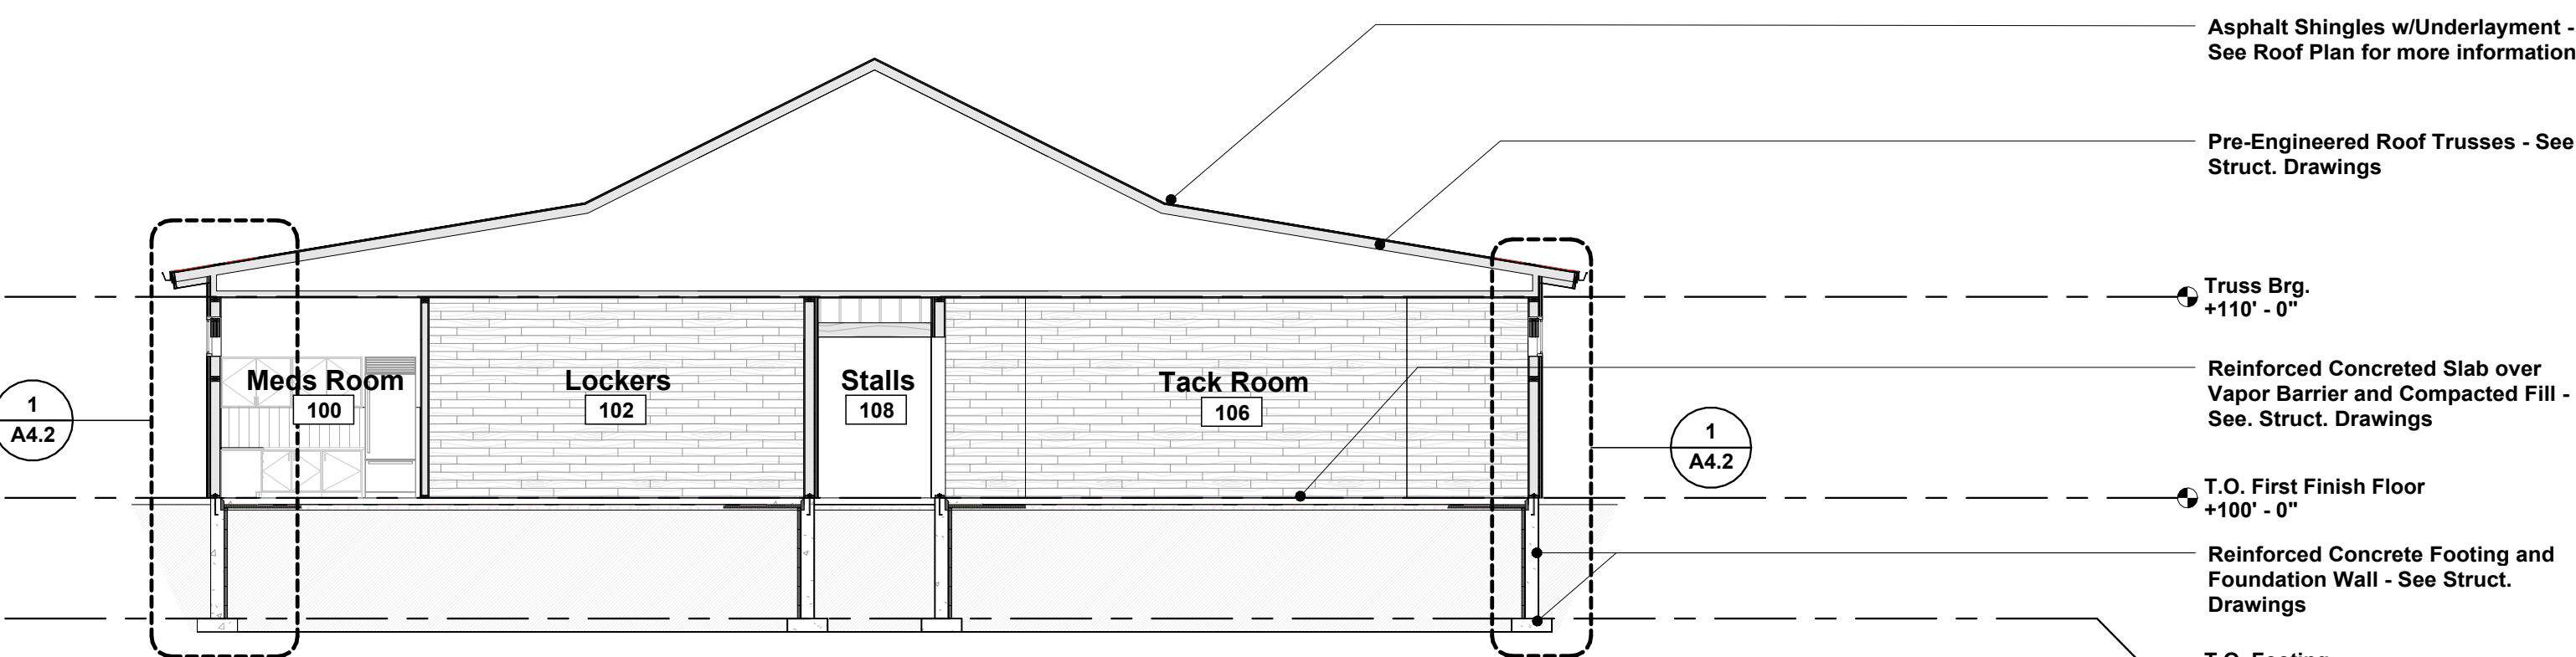

Asphalt Shingles w/Underlayment - See Roof Plan for more information

Pre-Engineered Roof Trusses - See Struct. Drawings


Truss Brg. +110' - 0"

Reinforced Concrete Slab over Vapor Barrier and Compacted Fill - See Struct. Drawings

T.O. First Finish Floor +100' - 0"

Reinforced Concrete Footing and Foundation Wall - See Struct. Drawings

T.O. Footing +94' - 0"

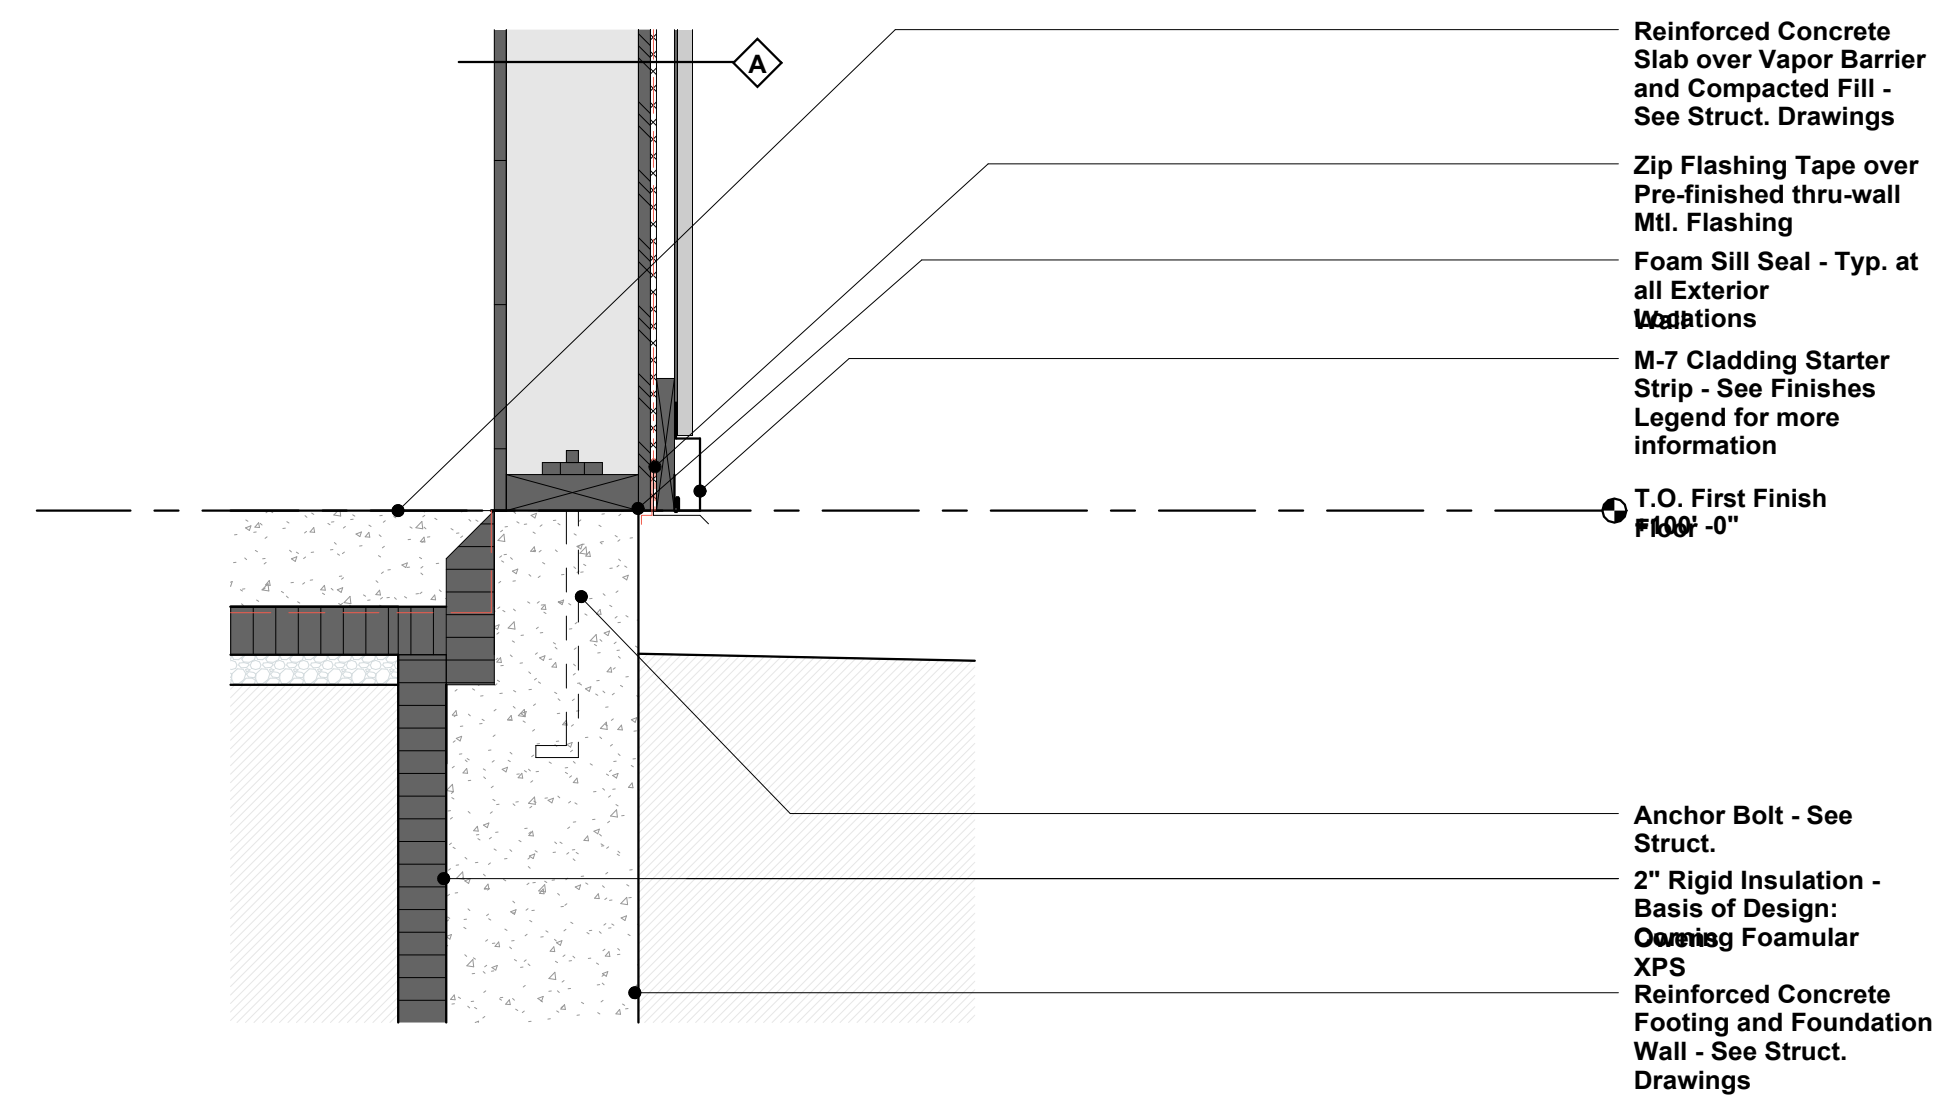

Reinforced Concrete Slab over Vapor Barrier and Compacted Fill - See Struct. Drawings

Zip Flashing Tape over Pre-finished thru-wall Mtl. Flashing

Foam Sill Seal - Typ. at all Exterior Windows

M-7 Cladding Starter Strip - See Finishes Legend for more information

T.O. First Finish Floor +100' - 0"

Anchor Bolt - See Struct. Drawings


2" Rigid Insulation - Basis of Design: Owens Corning Foamular XPS

Reinforced Concrete Footing and Foundation Wall - See Struct. Drawings

1

Building Section - A

SCALE 1/8" = 1'-0"

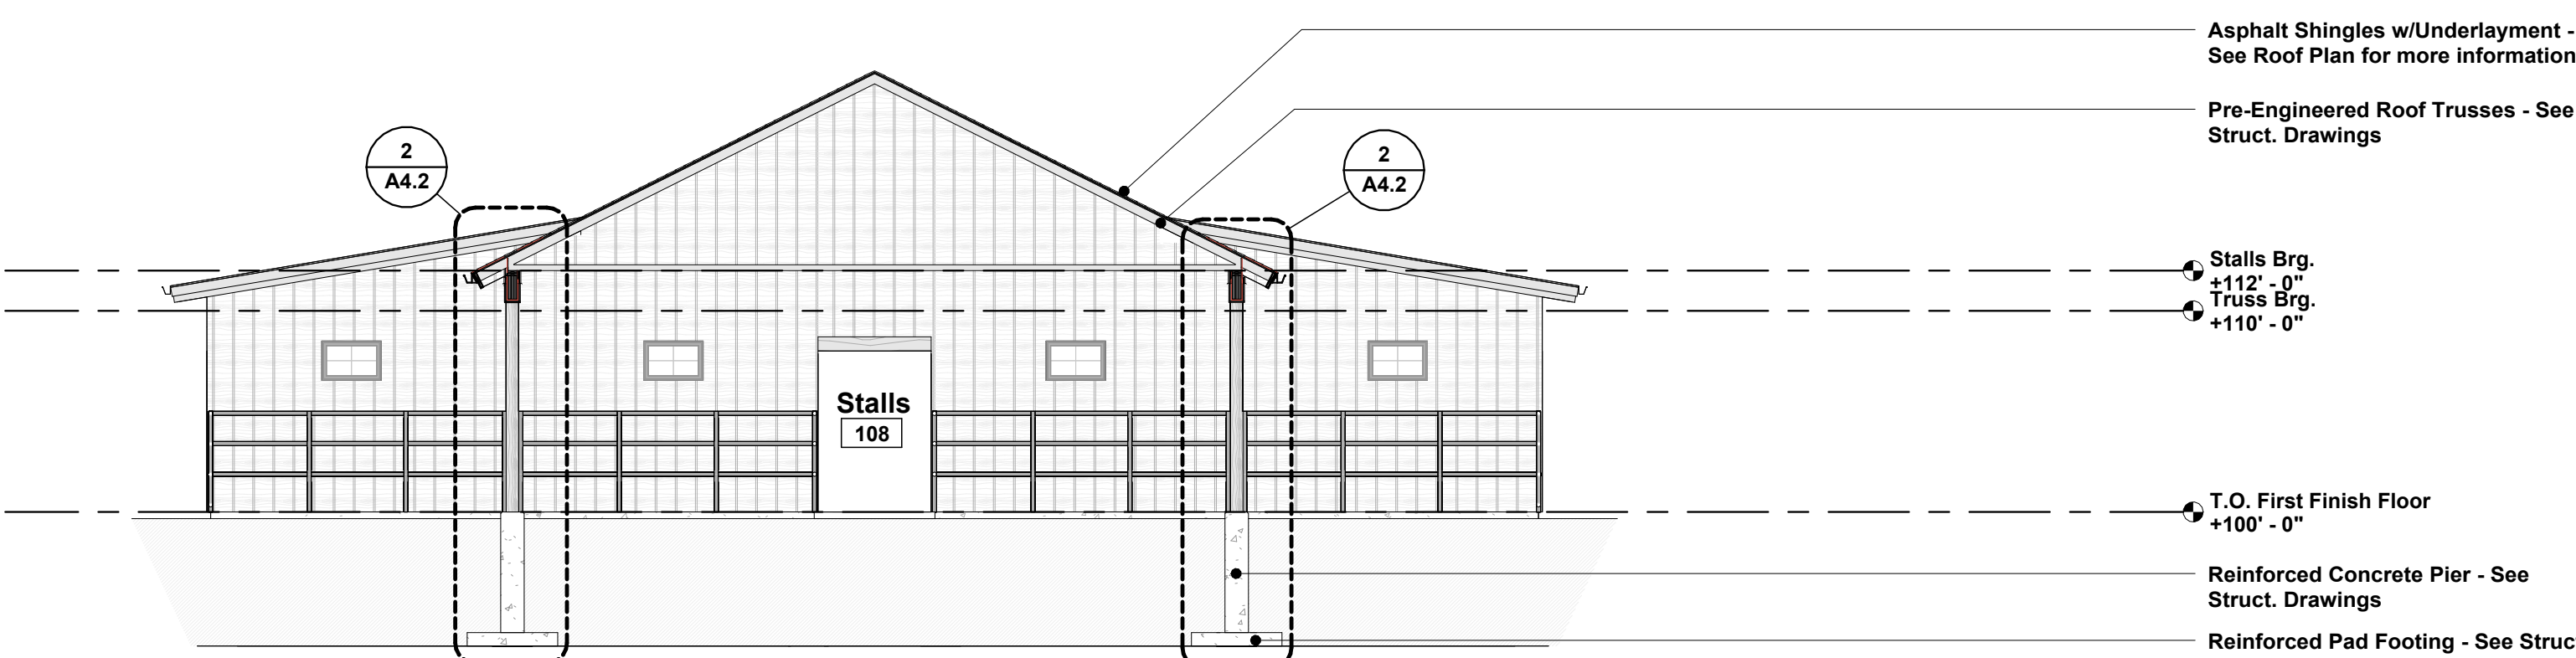

Asphalt Shingles w/Underlayment - See Roof Plan for more information

Pre-Engineered Roof Trusses - See Struct. Drawings

Stalls Brg. +112' - 0"

Truss Brg. +110' - 0"

T.O. First Finish Floor +100' - 0"

Reinforced Concrete Pier - See Struct. Drawings

Reinforced Pad Footing - See Struct. Drawings

5


Section Detail - Foundation

SCALE 1 1/2" = 1'-0"


REVISION LIST	
SCHEMATIC	DESIGN REVIEW
DESIGN DEV.	CONST. DOCS.
CITY SUB. 1	BUDG. DEPT.
CITY SUB. 2	CONSTRUCTION
Addendum #2 09/01/2026	CONSTR. REV 2
CONSTR. REV 3	

PROJECT #: 2515
CONTACT: KRISTI
SCALE: AS NOTED


BUILDING SECTIONS

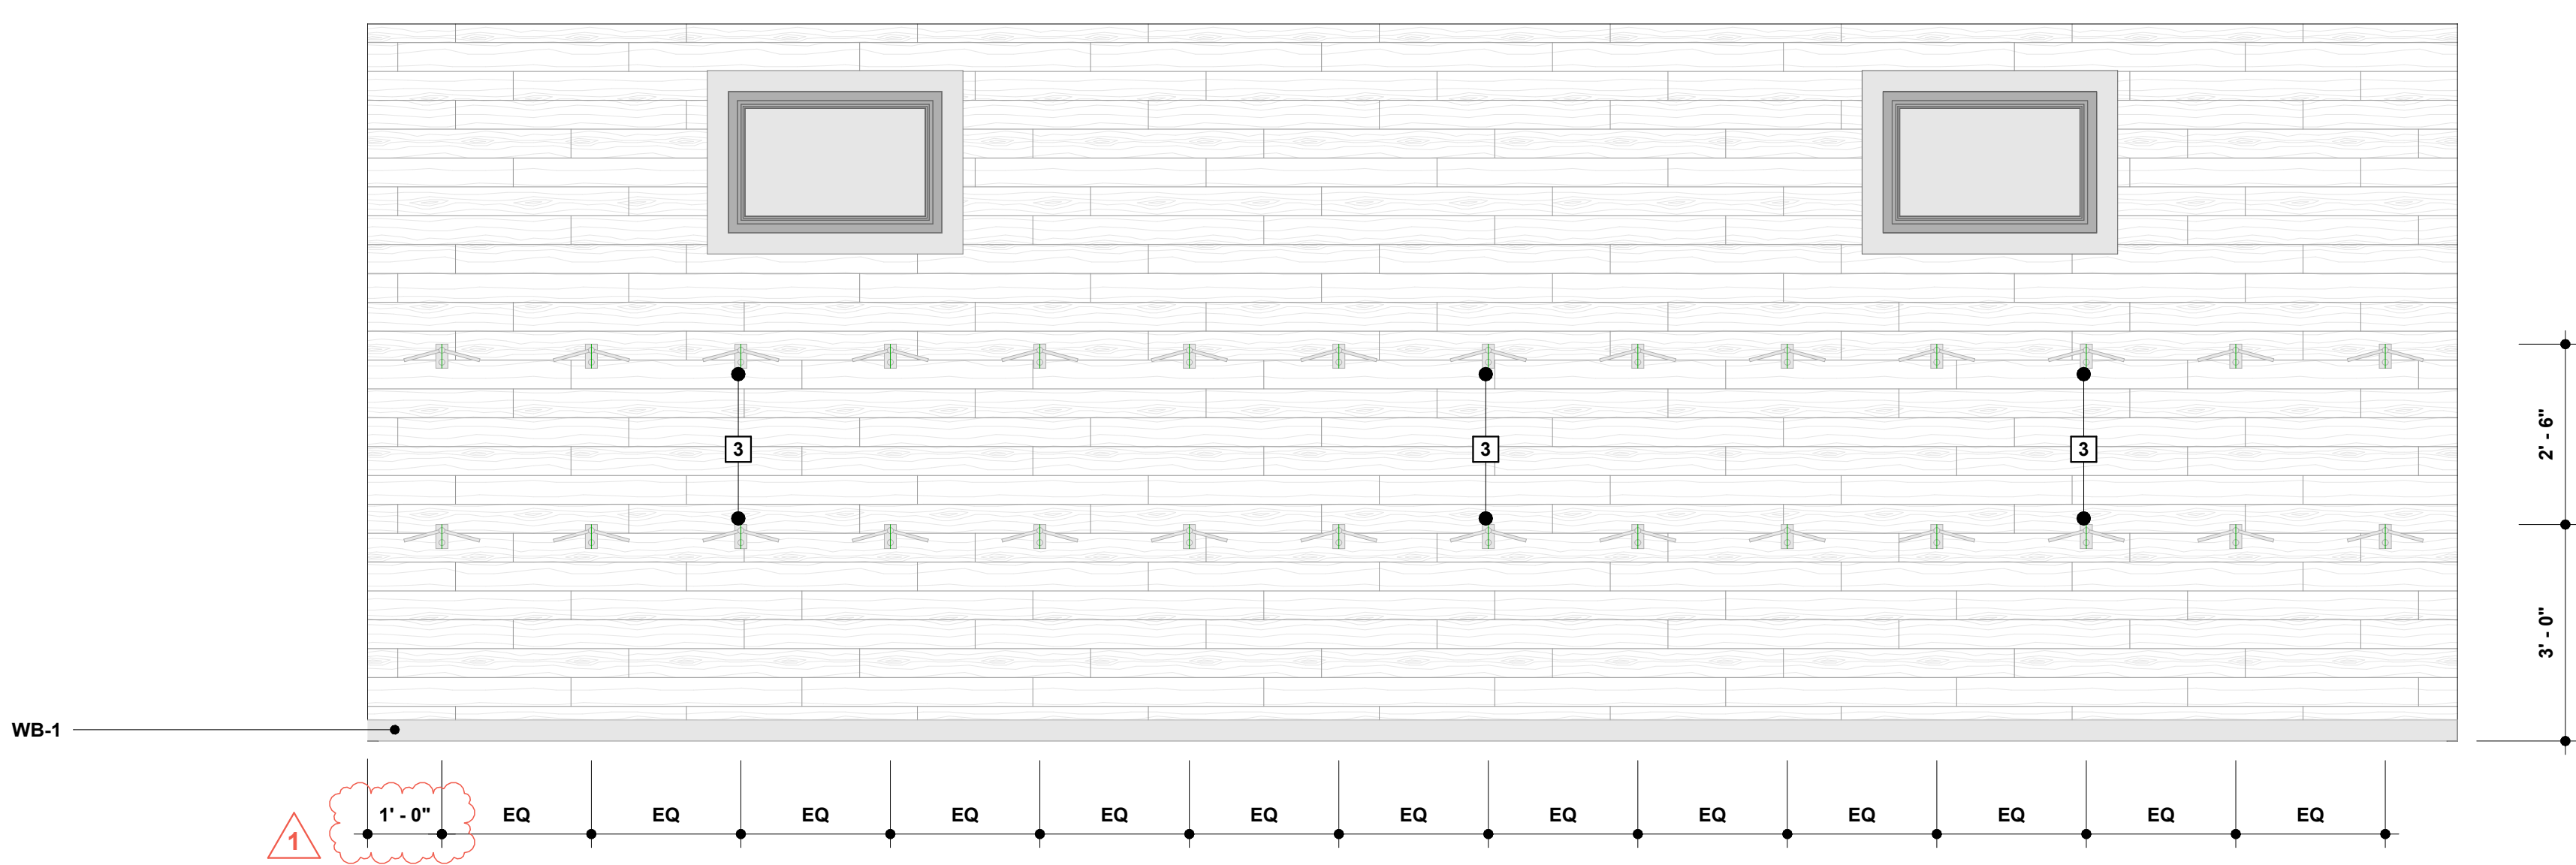


4 Tack Room 106 - A
SCALE 1/2" = 1'-0"
:

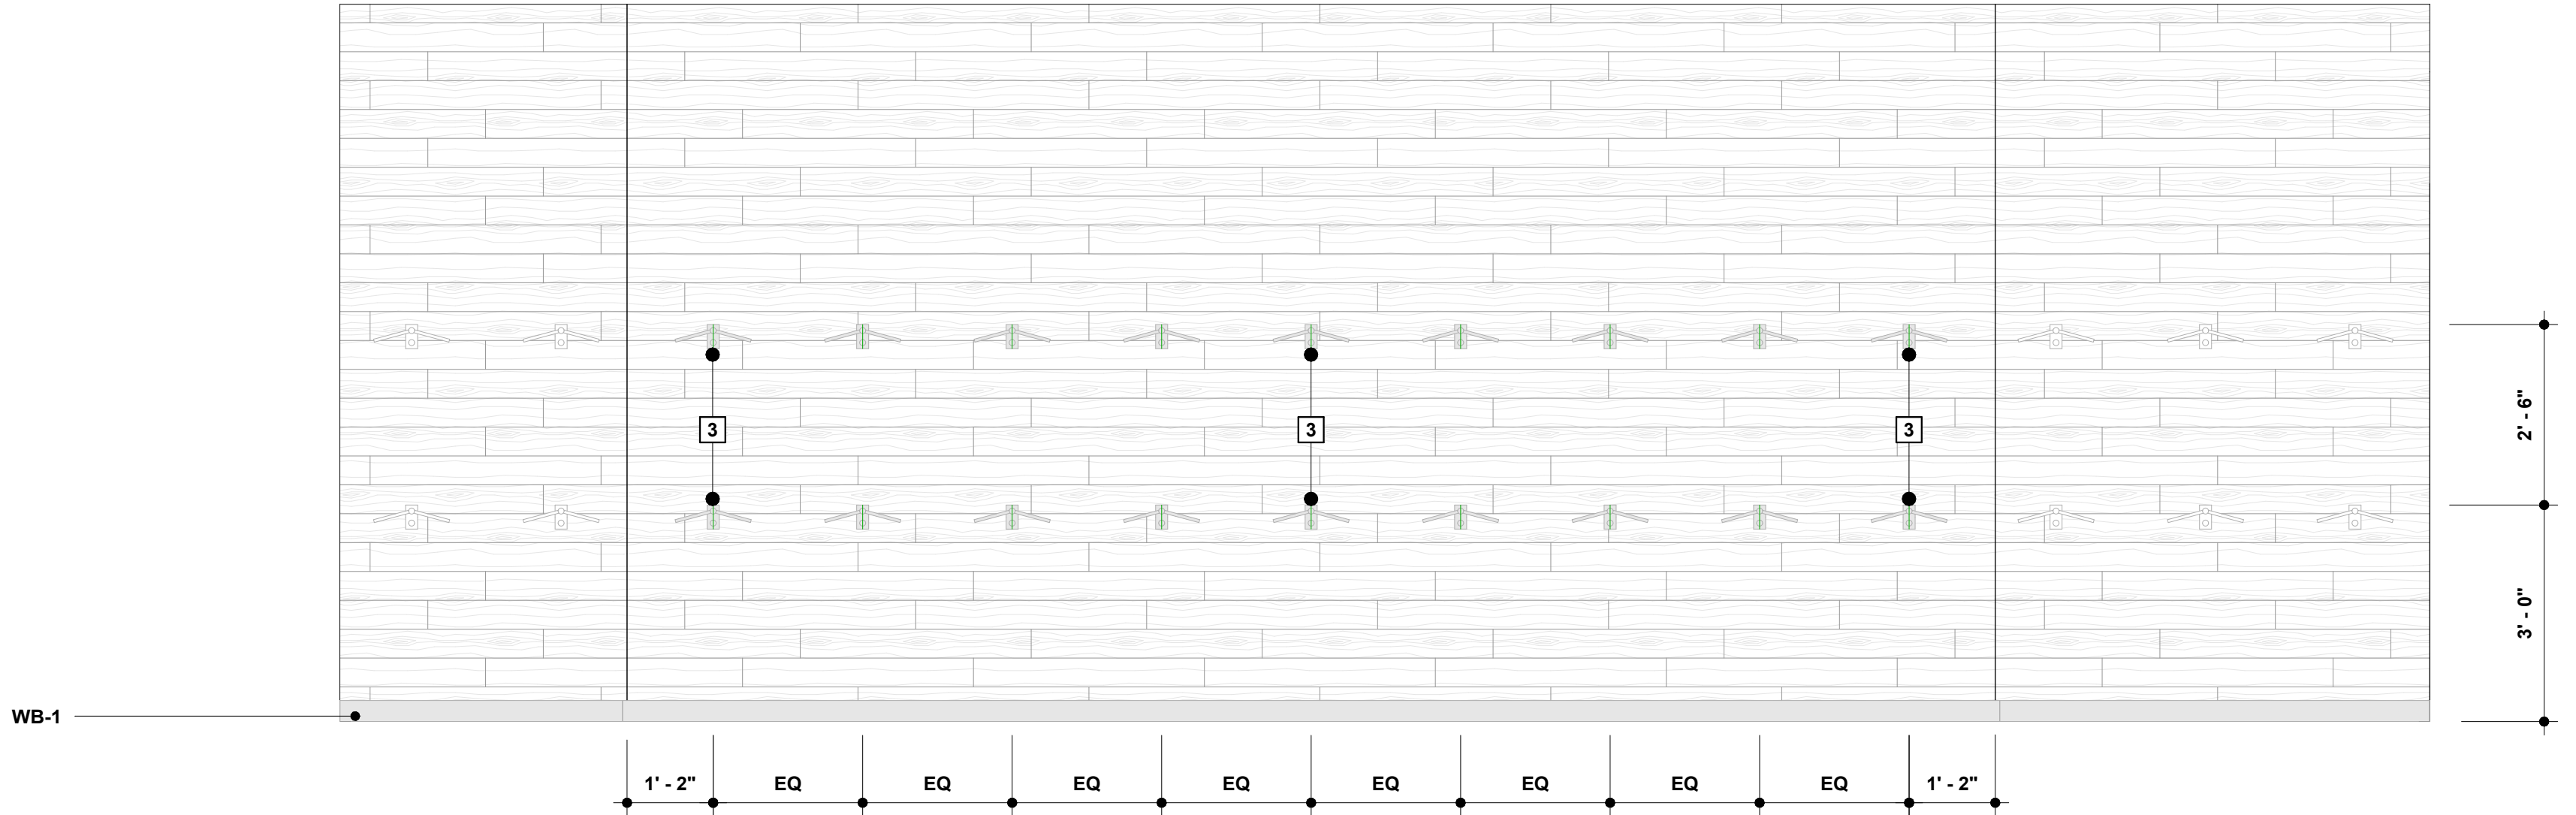

3 Tack Room 106 - B
SCALE 1/2" = 1'-0"
:

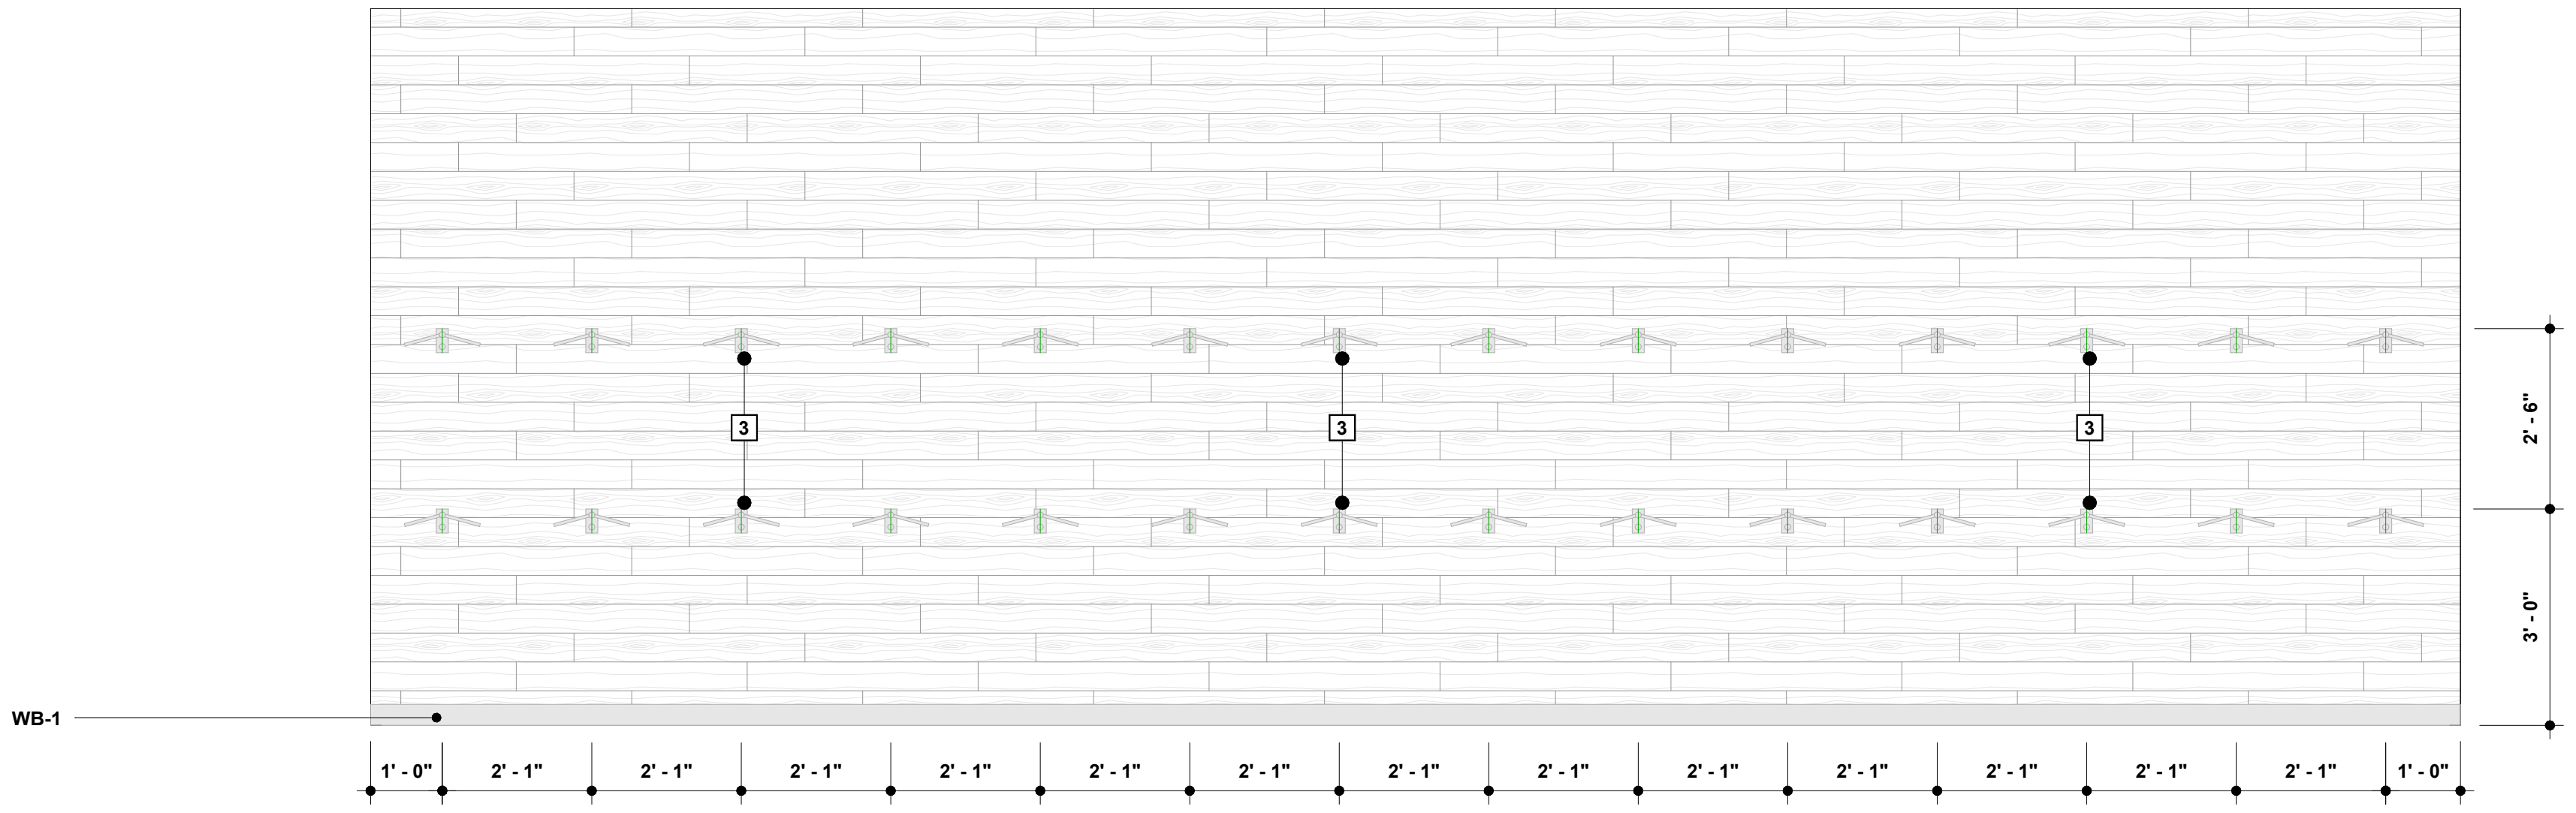

1 Tack Room 106 - C
SCALE 1/2" = 1'-0"
:

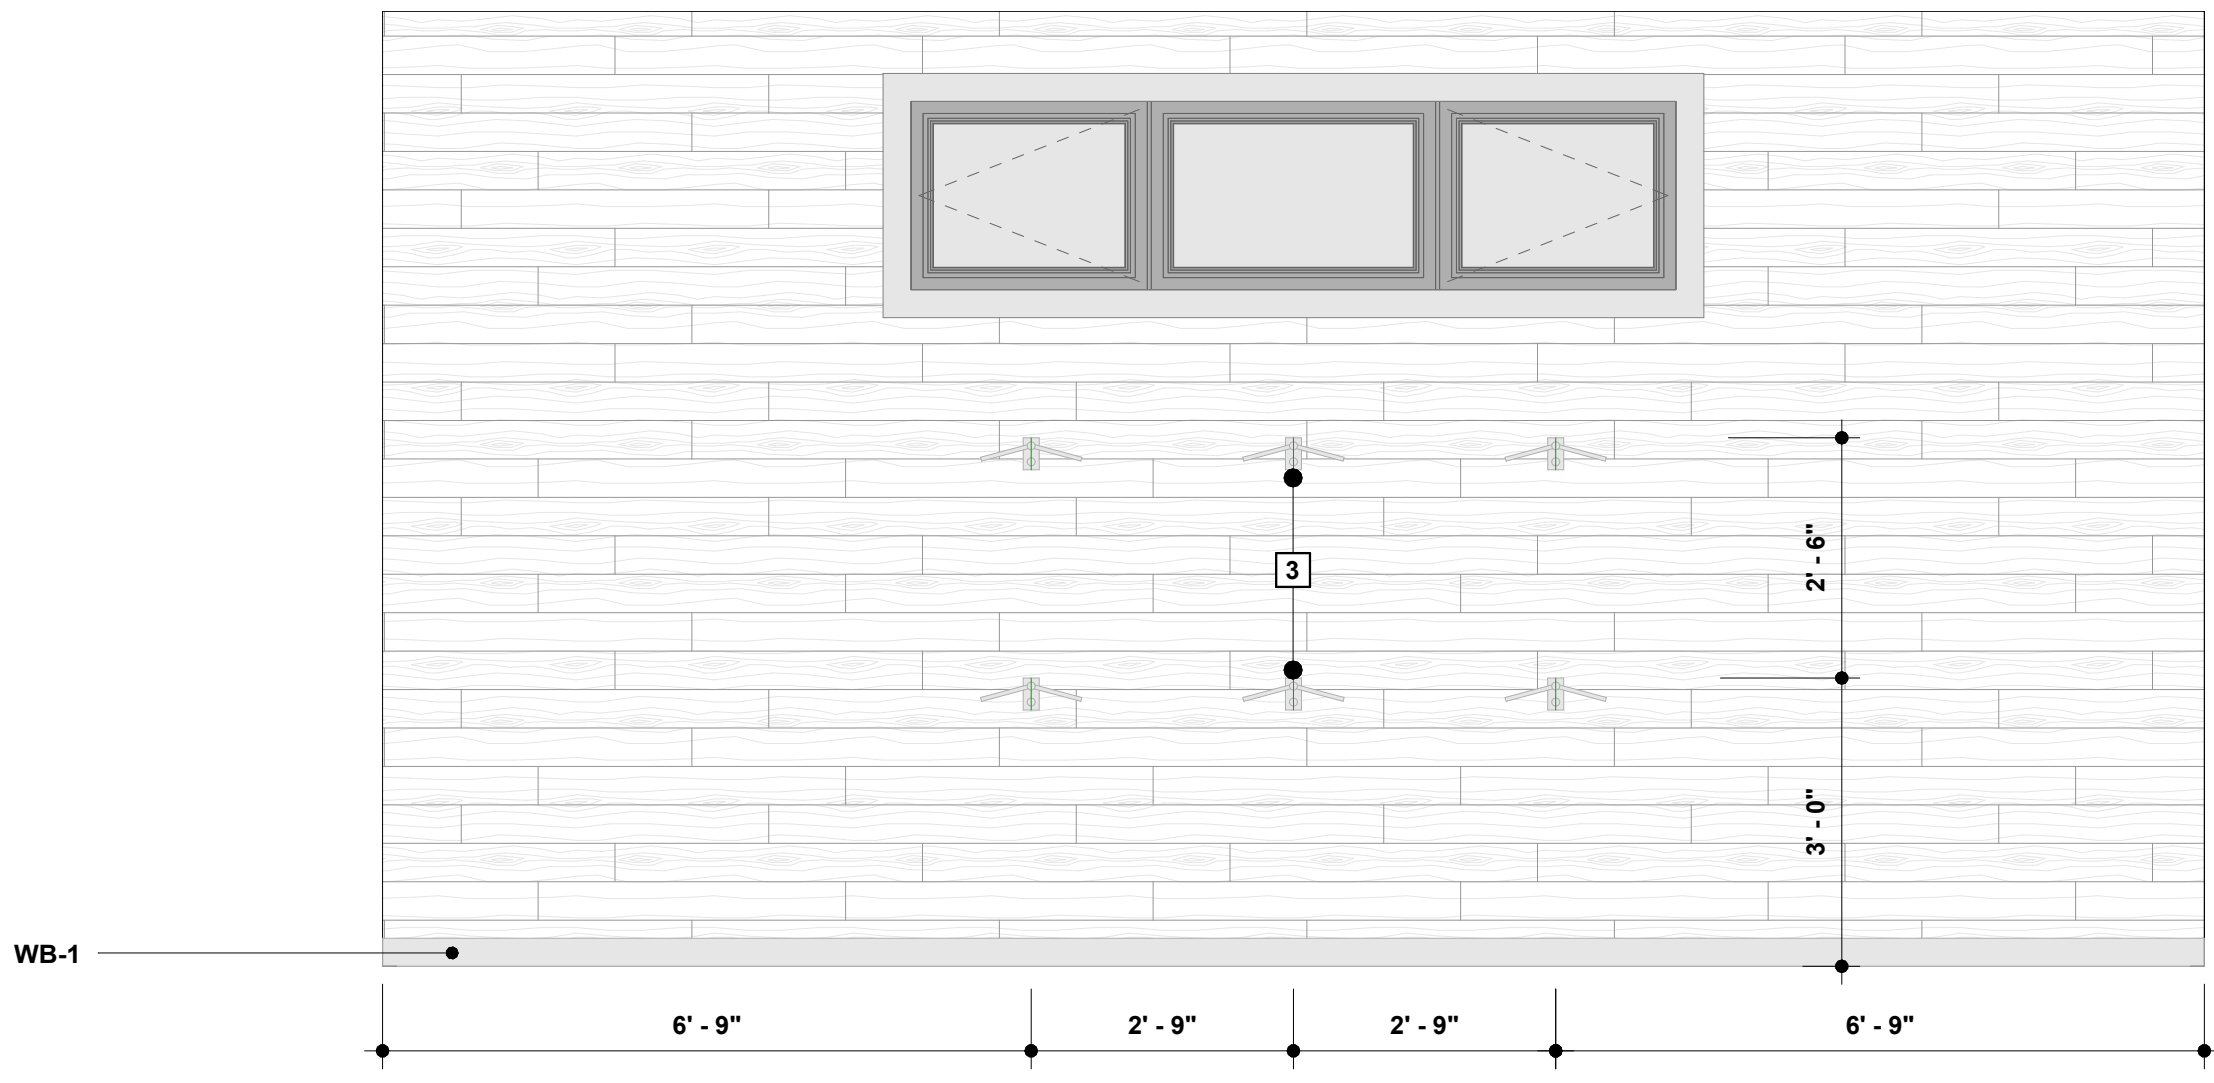

2 Tack Room 106 - D
SCALE 1/2" = 1'-0"
:

Interior Elevation Keynotes

- 1 Undercounter Fridge - Verify Make and Model w/Owner
- 2 Refrigerator - Verify Make and Model w/Owner
- 3 Saddle Rack - Basis of Design: Easy-Up Wall Mount Saddle Rack with Pad Bar - Finish: Black

72-185 PAINTERS PATH
SUITE A
PALM DESERT, CA
92260
760.776.4068

INSTRUMENTS OF SERVICE
THESE DRAWINGS ARE AN INSTRUMENT
OF SERVICE AND REMAIN THE PROPERTY
OF KRISTI HANSON ARCHITECTS INC.
THEY ARE NOT TO BE REPRODUCED OR
ALTERED IN ANY WAY, NOR DISCLOSED
OR ASSIGNED TO ANY THIRD PARTY
WITHOUT THE EXPRESS WRITTEN
PERMISSION OF KRISTI HANSON
ARCHITECTS, INC.

CITY APPROVAL:

TRMF RIDING STABLES - HORSE STALLS
14532 1-94 Loop East
ND 58645



REVISION LIST	
SCHEMATIC	DESIGN REVIEW
DESIGN DEV.	
CONST. DOCS.	
CITY SUB. 1	BIDS. DEPT.
CITY SUB. 2	
1 Addendum #2 09/01/2026	CONSTRUCTION
CONSTR. REV 2	
CONSTR. REV 3	

PROJECT # : 2515

CONTACT : KRISTI

SCALE: AS NOTED

INTERIOR
ELEVATIONS

SHEET
A5.1
DATE: 08/07/26
Q.C. _____

REVISION LIST	
SCHEMATIC	DESIGN REVIEW
DESIGN DEV.	
CONST. DOCS.	
CITY SUB. 1	BLDG. DEPT.
CITY SUB. 2	
Addendum #2 09/01/2026	CONSTRUCTION
CONSTR. REV 2	
CONSTR. REV 3	

PROJECT # : 2515
CONTACT : KRISTI
SCALE: AS NOTED

RCP

RCP General Notes


1. Paint All Fixture Trim/Diffusers to Match Soffit Color if Located in Gypsum Soffit.
2. Paint Linear Mechanical Diffusers to Match Wall Finish if Located in Wall Surface.
3. Window Heads and Jambes to be GWB Returns Finished to Match Adjacent Wall.
4. All finished ceiling heights on first floor to be 10'-0" A.F.F. unless otherwise noted.

RCP Legend

- Wd. Ceiling - See Finish Schedule and Finishes Legend for more information
- Pre-finished Vented Metal Soffit - See Finish Schedule and Finishes Legend for more information
- Exterior Wall Sconce - See Elec. Drawings for more information
- 1x4 Surface Mount Light Fixture - See Elec. Drawings for more information
- Linear LED - See Elec. Drawings for more information
- Downlight - See Elec. Drawings for more information


RCP Keynotes

- 1 Wd. Gable Accents - See details for additional information
- 2 Aluminum Gutter & Downspout System - Finish: M-2 (Gutter) and M-3 (Downspout)
- 3 Wd. Beam - Finish: WD-1
- 4 Exposed Roof Trusses in this location

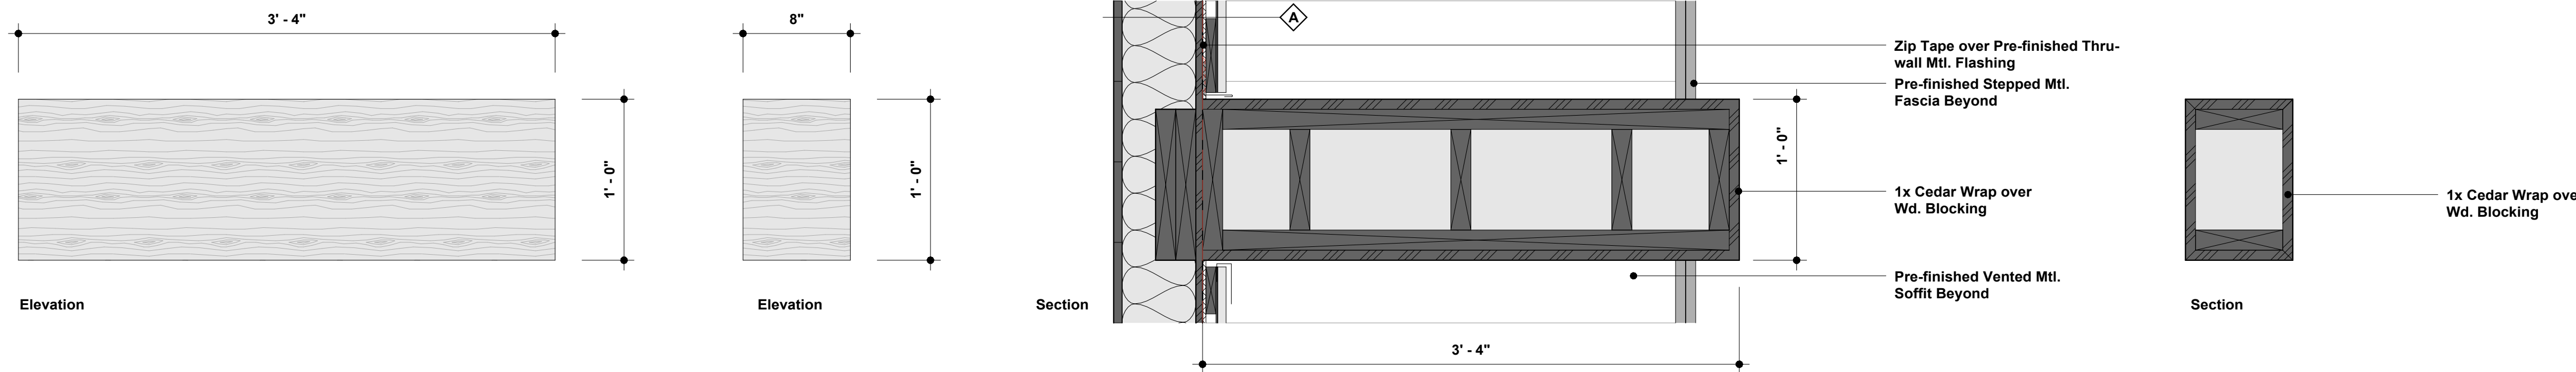

Gable Accent Details

SCALE 1 1/2" = 1'-0"

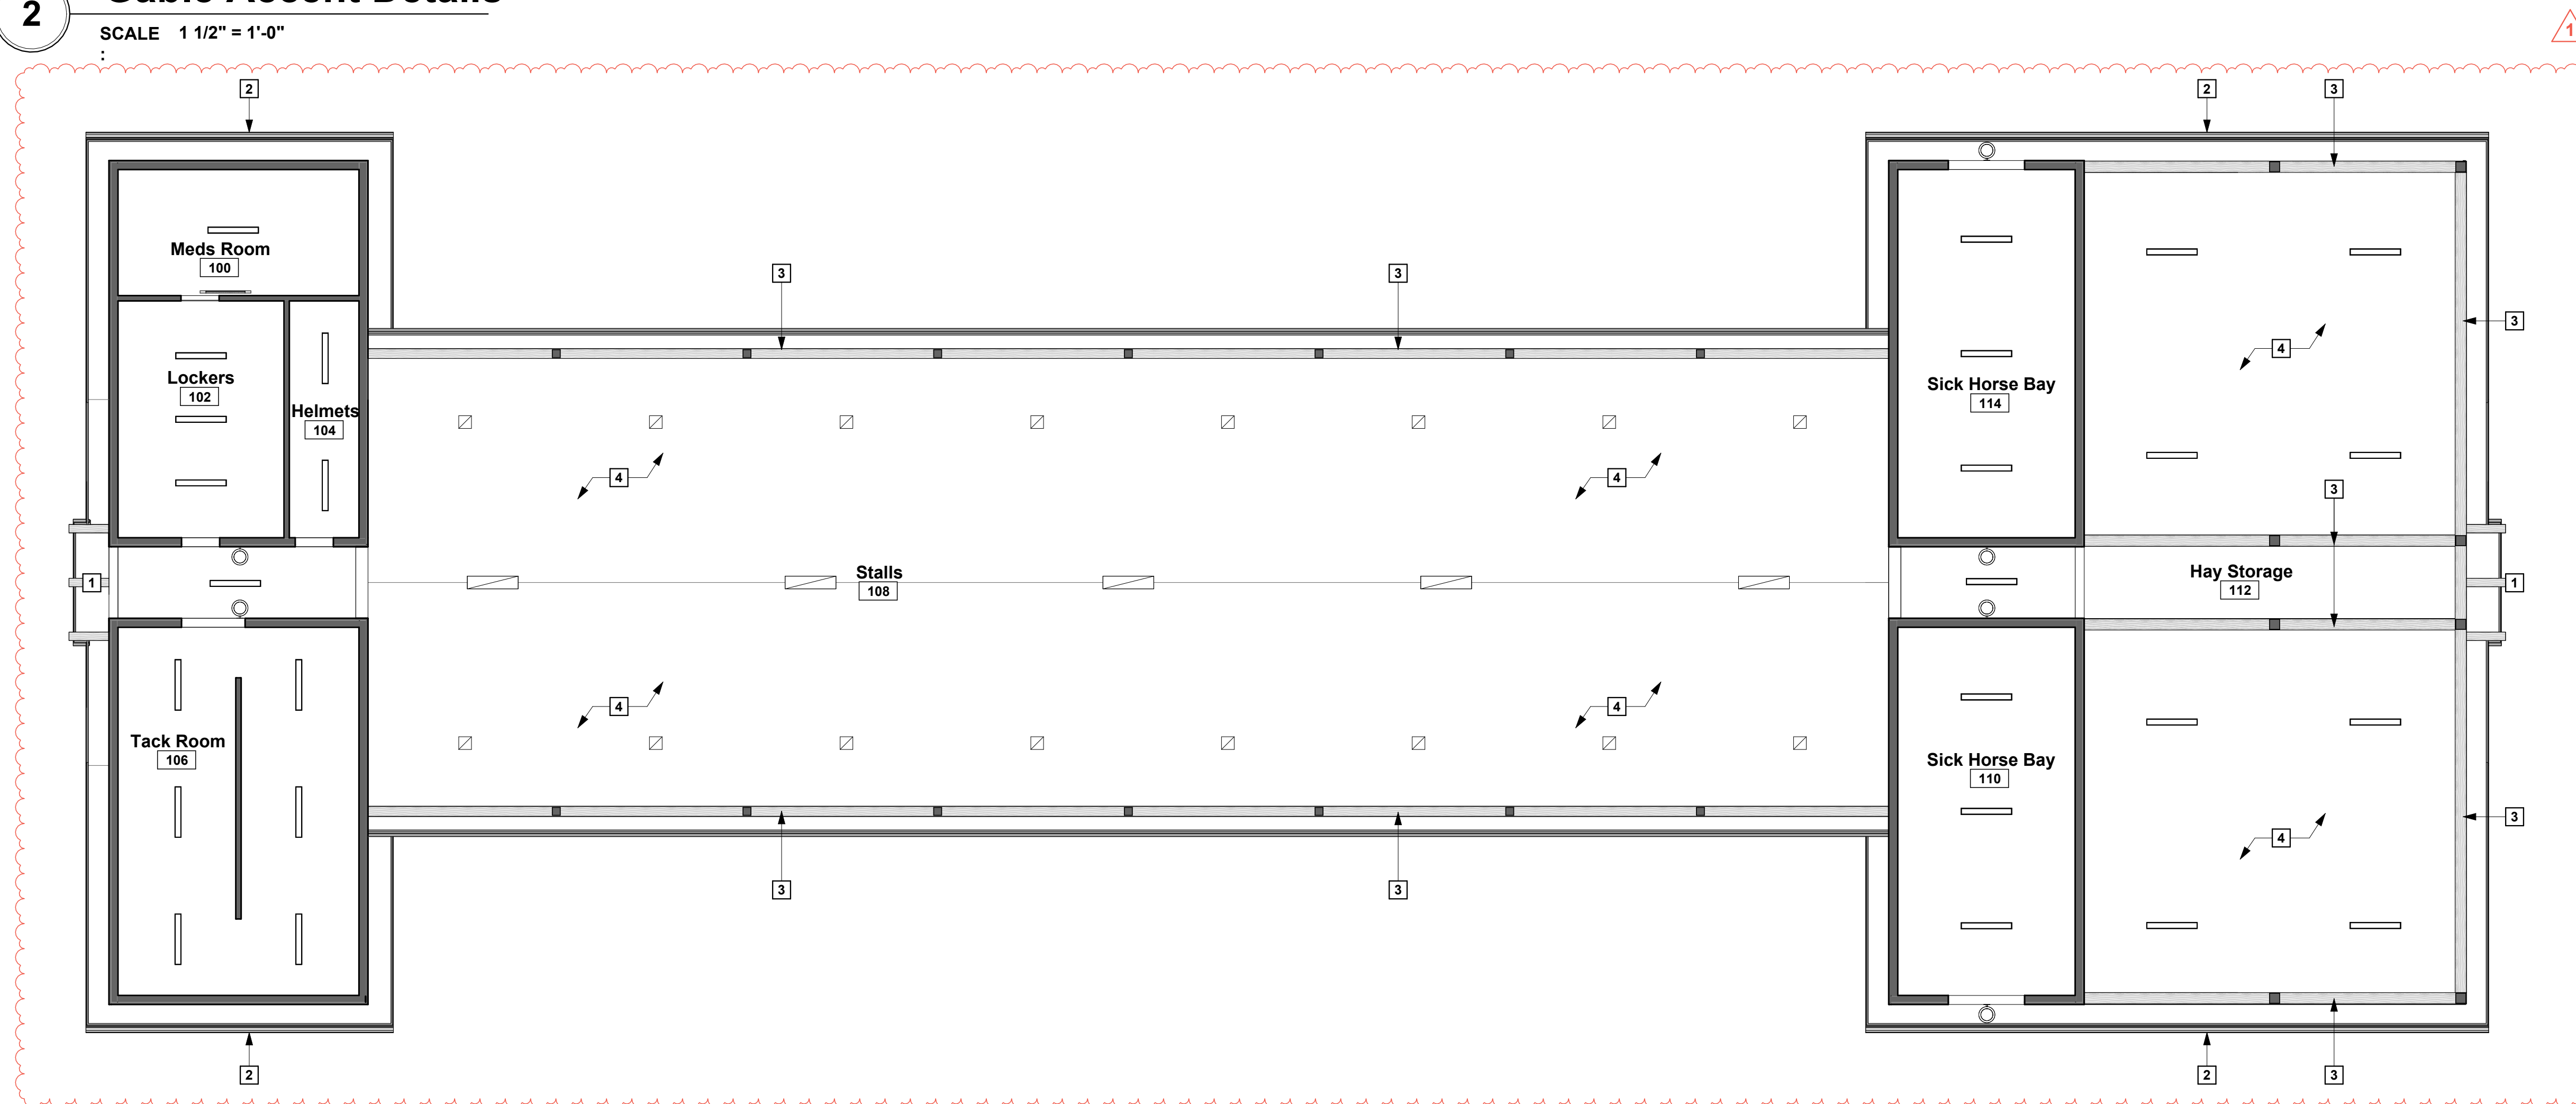


RCP

SCALE 1/8" = 1'-0"

REVISION LIST		
SCHEMATIC	DESIGN REVIEW	
DESIGN DEV.		
CONST. DOCS.		
CITY SUB. 1	BLDG. DEPT.	
CITY SUB. 2		
CONSTR. REV 1	CONSTRUCTION	
CONSTR. REV 2		
CONSTR. REV 3		

PROJECT #: 2515
CONTACT : KRISTI
SCALE: AS NOTED
HORSE STABLES -
FIRST FLOOR
LIGHTING PLAN

LUMINAIRE SCHEDULE									
TYPE	MANUFACTURERS OR EQUAL	CATALOG INFORMATION	FIXTURE DESCRIPTION	LED DATA	DRIVER DATA	INPUT WATTS	VOLTAGE	MOUNTING	REMARKS
				TYPE	TYPE				
D1	KENALL OR EQUAL	MS15-D SERIES	16"x16" SQUARE DOWNLIGHT, FULL FACE, MARINE GRADE DIE CAST ALUMINUM HOUSING, EPDM GASKETING, WET LOCATION RATED. IP64 AND IK10.	3500K LED 3300 LUMENS	0-10V DIMMING LED DRIVER	30	120VOLT	SURFACE	
F1	KENALL OR EQUAL	MLH12 SERIES	4 FOOT LINEAR LED, MARINE GRADE DIE CAST ALUMINUM HOUSING, EPDM GASKETING, WET LOCATION RATED. IP64 AND IK9.	3500K LED 5000 LUMENS	0-10V DIMMING LED DRIVER	49	120VOLT	SURFACE	PROVIDE PENDANT MOUNTING AS NECESSARY IN ROOMS 102, 104, 108, 110, 112, AND 114 WHERE CEILINGS ARE OPEN TO TRUSSES ABOVE.
F2	KENALL OR EQUAL	MLH12 SERIES	4 FOOT LINEAR LED, MARINE GRADE DIE CAST ALUMINUM HOUSING, EPDM GASKETING, WET LOCATION RATED. IP64 AND IK9.	3500K LED 7800 LUMENS	0-10V DIMMING LED DRIVER	73	120VOLT	SURFACE	
F3	KENALL OR EQUAL	MLH12 SERIES	4 FOOT LINEAR LED, MARINE GRADE DIE CAST ALUMINUM HOUSING, EPDM GASKETING, WET LOCATION RATED. IP64 AND IK9.	3500K LED 9900 LUMENS	0-10V DIMMING LED DRIVER	98	120VOLT	SURFACE	PROVIDE PENDANT MOUNTING AS NECESSARY IN ROOMS 102, 104, 108, 110, 112, AND 114 WHERE CEILINGS ARE OPEN TO TRUSSES ABOVE.
L	ANP OR EQUAL	WS08 SERIES	8 INCH LED RLM WAREHOUSE SHADE WITH WM40 STYLE WALL MOUNT, MATTE BLACK FINISH	LED 3500K 2000 LUMENS	LED DRIVER	20	120VOLT	WALL	
X			WALL MOUNTED SCONCE TO BE SELECTED AND PROVIDED BY OTHERS, INSTALLED BY ELECTRICIAN.						

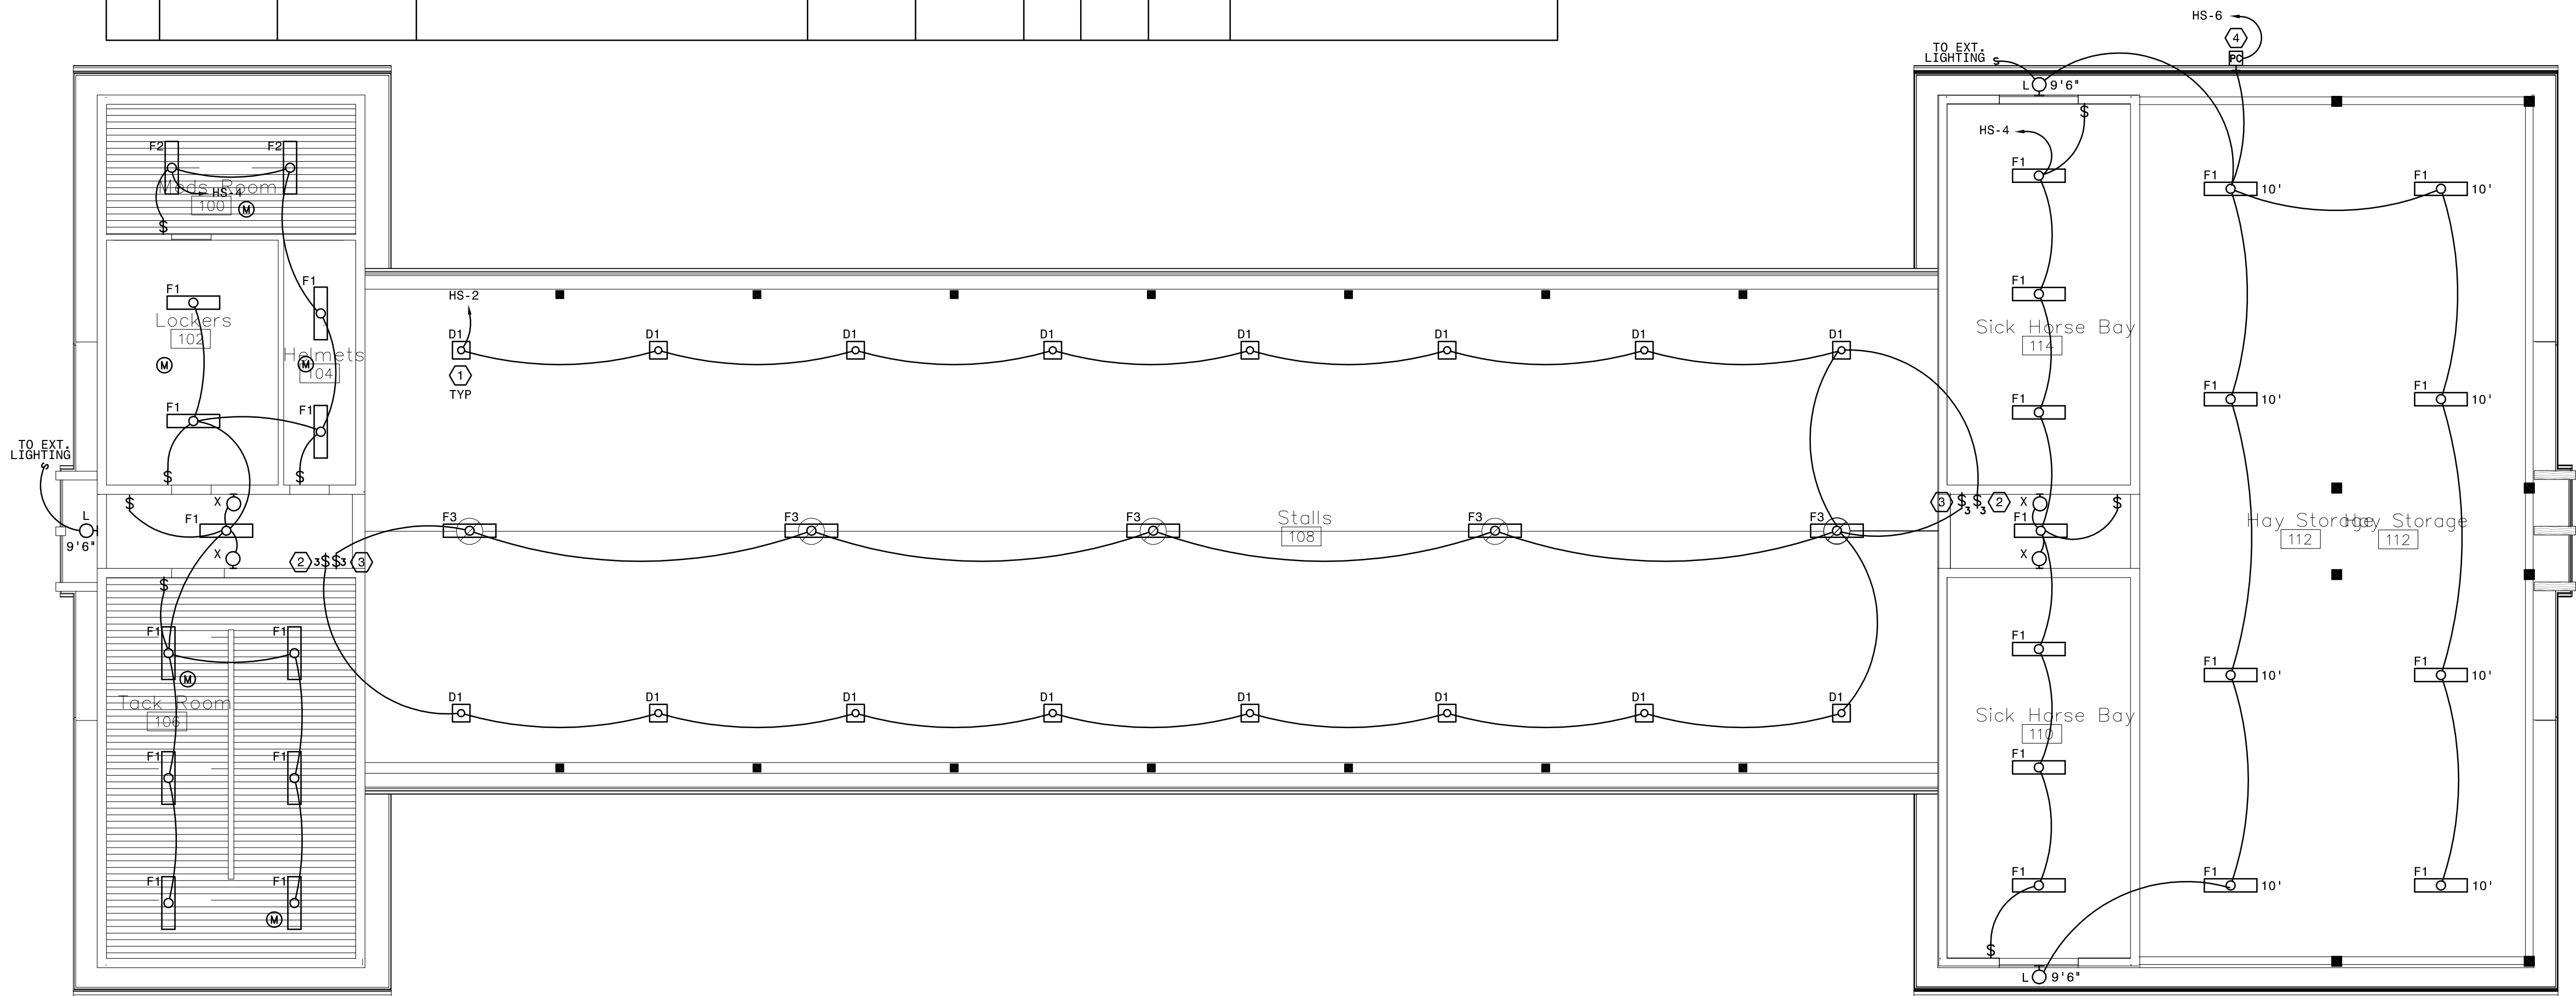

PLAN NOTES:

1. VERIFY MOUNTING LOCATION OF FIXTURE WITH ARCHITECT PRIOR TO INSTALL.
2. SWITCH IS TO PERFORM MANUAL ON/OFF CONTROL FOR THE D1 FIXTURES ABOVE THE HORSE STABLES.
3. SWITCH IS TO PERFORM MANUAL ON/OFF CONTROL FOR THE F1 & F3 FIXTURES BETWEEN THE HORSE STABLES.
4. PROVIDE PHOTOCELL FOR AUTOMATIC ON/OFF CONTROL FOR ALL EXTERIOR FIXTURES. VERIFY MOUNTING LOCATION WITH ARCHITECT PRIOR TO INSTALL. PROVIDE A 4 POLE LIGHTING CONTACTOR FOR CONNECTION TO CONTROLLED CIRCUITS.