


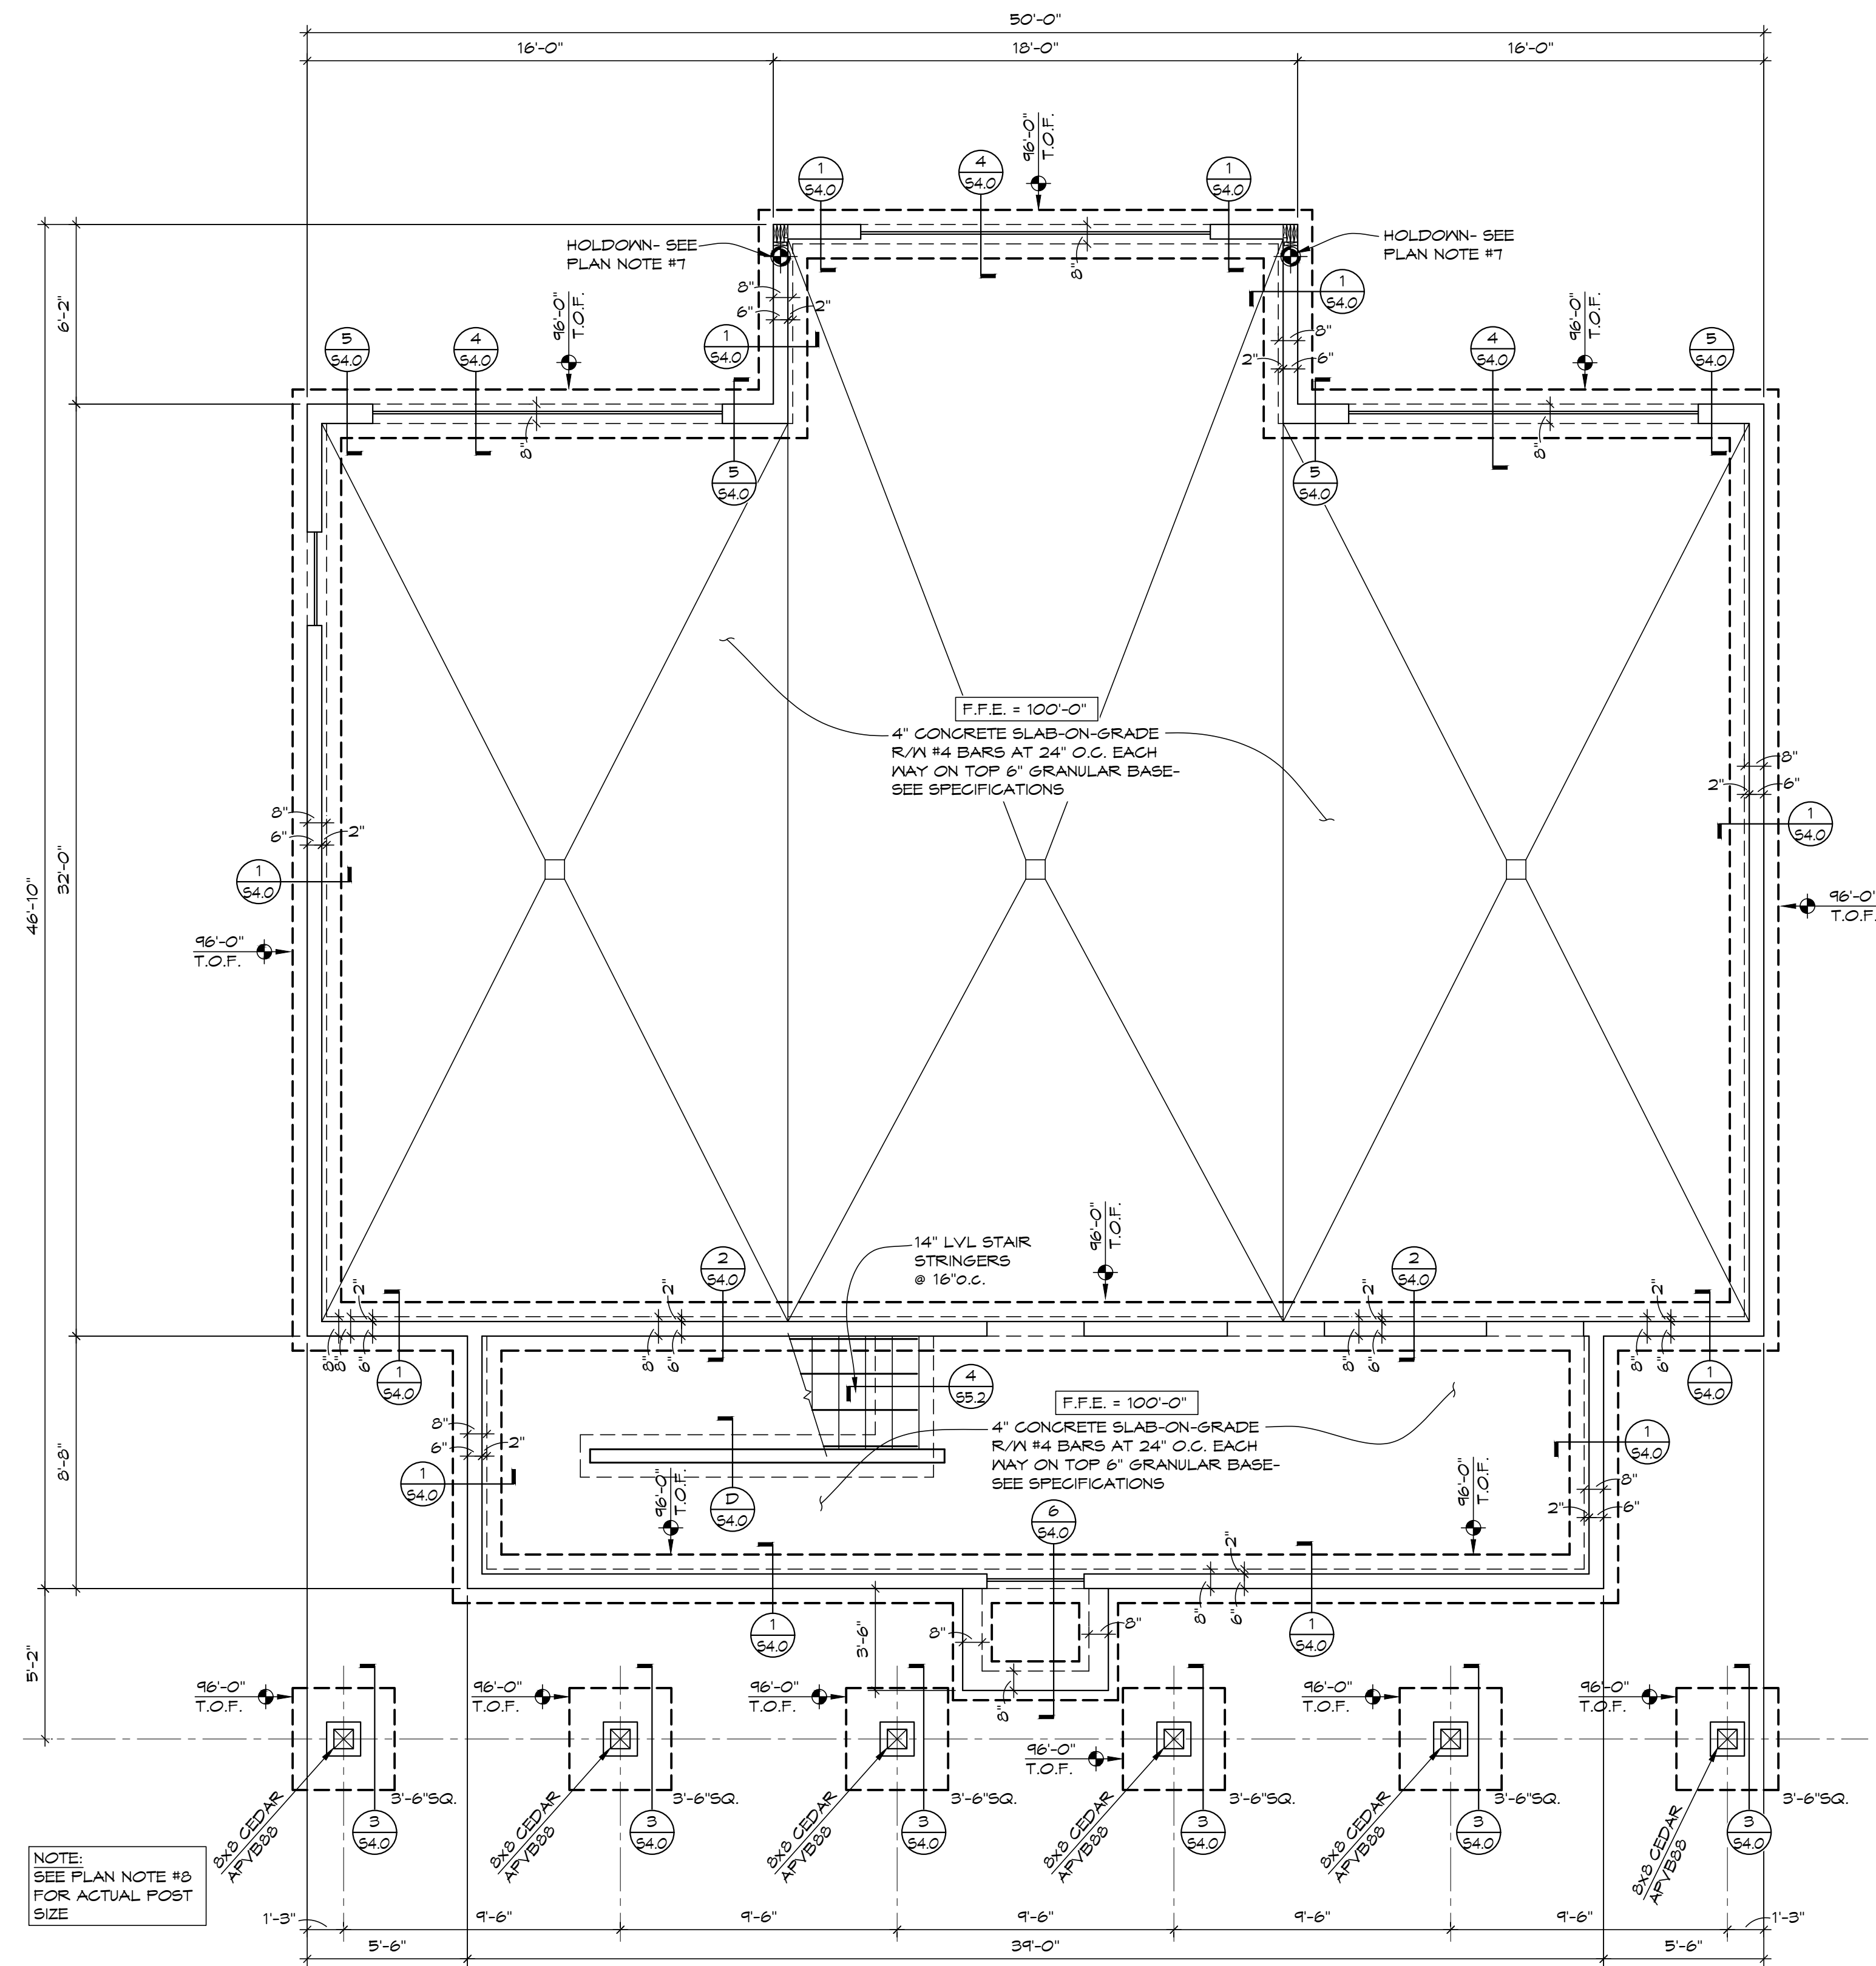

FOUNDATION PLAN

SCALE: 1/4"=1'-0"



PLAN NOTES:

(1) ALL PAD FOOTINGS ARE CENTERED BELOW THE COLUMN THEY SUPPORT - SEE FOUNDATION PLAN & PAD FOOTING SCHEDULE FOR SIZE & REINFORCING.

(2) ALL CONTINUOUS WALL FOOTINGS ARE 10" THICK UNREINFORCED, AND PROJECT 6" BEYOND EACH FACE OF FOUNDATION THEY SUPPORT, EXCEPT AS NOTED OTHERWISE.

(3) @--- INDICATES STEP IN CONTINUOUS WALL FOOTING, SPACE STEPS AT 4'-0" FROM BUILDING CORNERS AND OTHER FOOTINGS STEPS EXCEPT AS SHOWN OTHERWISE.

(4) X'-X" T.O.F. --- INDICATES TOP OF FOOTING ELEVATION.

(5) GENERAL CONTRACTOR TO COORDINATE WITH ELECTRICAL CONTRACTOR FOR BUILDING GROUNDING WIRE ATTACHMENT TO FOUNDATION WALL REINFORCING PRIOR TO POURING FOUNDATION WALL.

(6) MECHANICAL PIPING CROSSING FOUNDATION WALL- SEE FOLLOWING RECOMMENDATIONS REGARDING PIPING & FOUNDATION CONFLICTS INDICATED ON PLAN. COORDINATE ALL OTHER LOCATIONS NOT SHOWN WITH STRUCTURAL ENGINEER.

(7) --- INDICATES APPROXIMATE LOCATION OF SHEAR WALL HOLDOWN TO BE LOCATED AT END OF SHEAR WALL SEGMENT AT BASE OF WALL BELOW. SEE DETAIL 4/S&1, PLAN FOR LOCATIONS & REFER TO GENERAL STRUCTURAL SHEARWALL NOTES FOR ANCHORING REQUIREMENTS.

(8) 8x8 CEDAR POST TO BE ACTUAL 1 1/2x7 1/2.

PAD FOOTING SCHEDULE

(2000 PSF ALLOWABLE SOIL BRG CAPACITY)

SIZE	THICKNESS	REINFORCING
3'-6" SQ.	12"	(5) #4 HORIZ. EA. WAY

FOOTING REINFORCING NOTES:
1) SPACE BARS EVENLY EACH WAY ACROSS MATS
2) UNLESS NOTED OTHERWISE, ALL REBAR MATS ARE REQUIRED TO BE LOCATED 3" CLEAR FROM BOTTOM AND SIDES OF FOOTING



REVISION LIST

SCHEMATIC	DESIGN REVIEW
DESIGN DEV.	
CONST. DOCS.	
CITY SUB. 1	
CITY SUB. 2	
CONSTR. REV 1	
CONSTR. REV 2	
CONSTR. REV 3	

PROJECT #: C2663A-A

CONTACT: CHRIS

SCALE: AS NOTED

FOUNDATION PLAN

DATE: 8/7/2026

SHEET

DATE: 8/7/26

DATE: 8/7/26

DATE: 8/7/26

DATE: 8/7/26

DATE: 8/7/26


DATE: 8/7/26

DATE: 8/7/26

DATE: 8/7/26


DATE: 8/7/26

DATE: 8/7/26

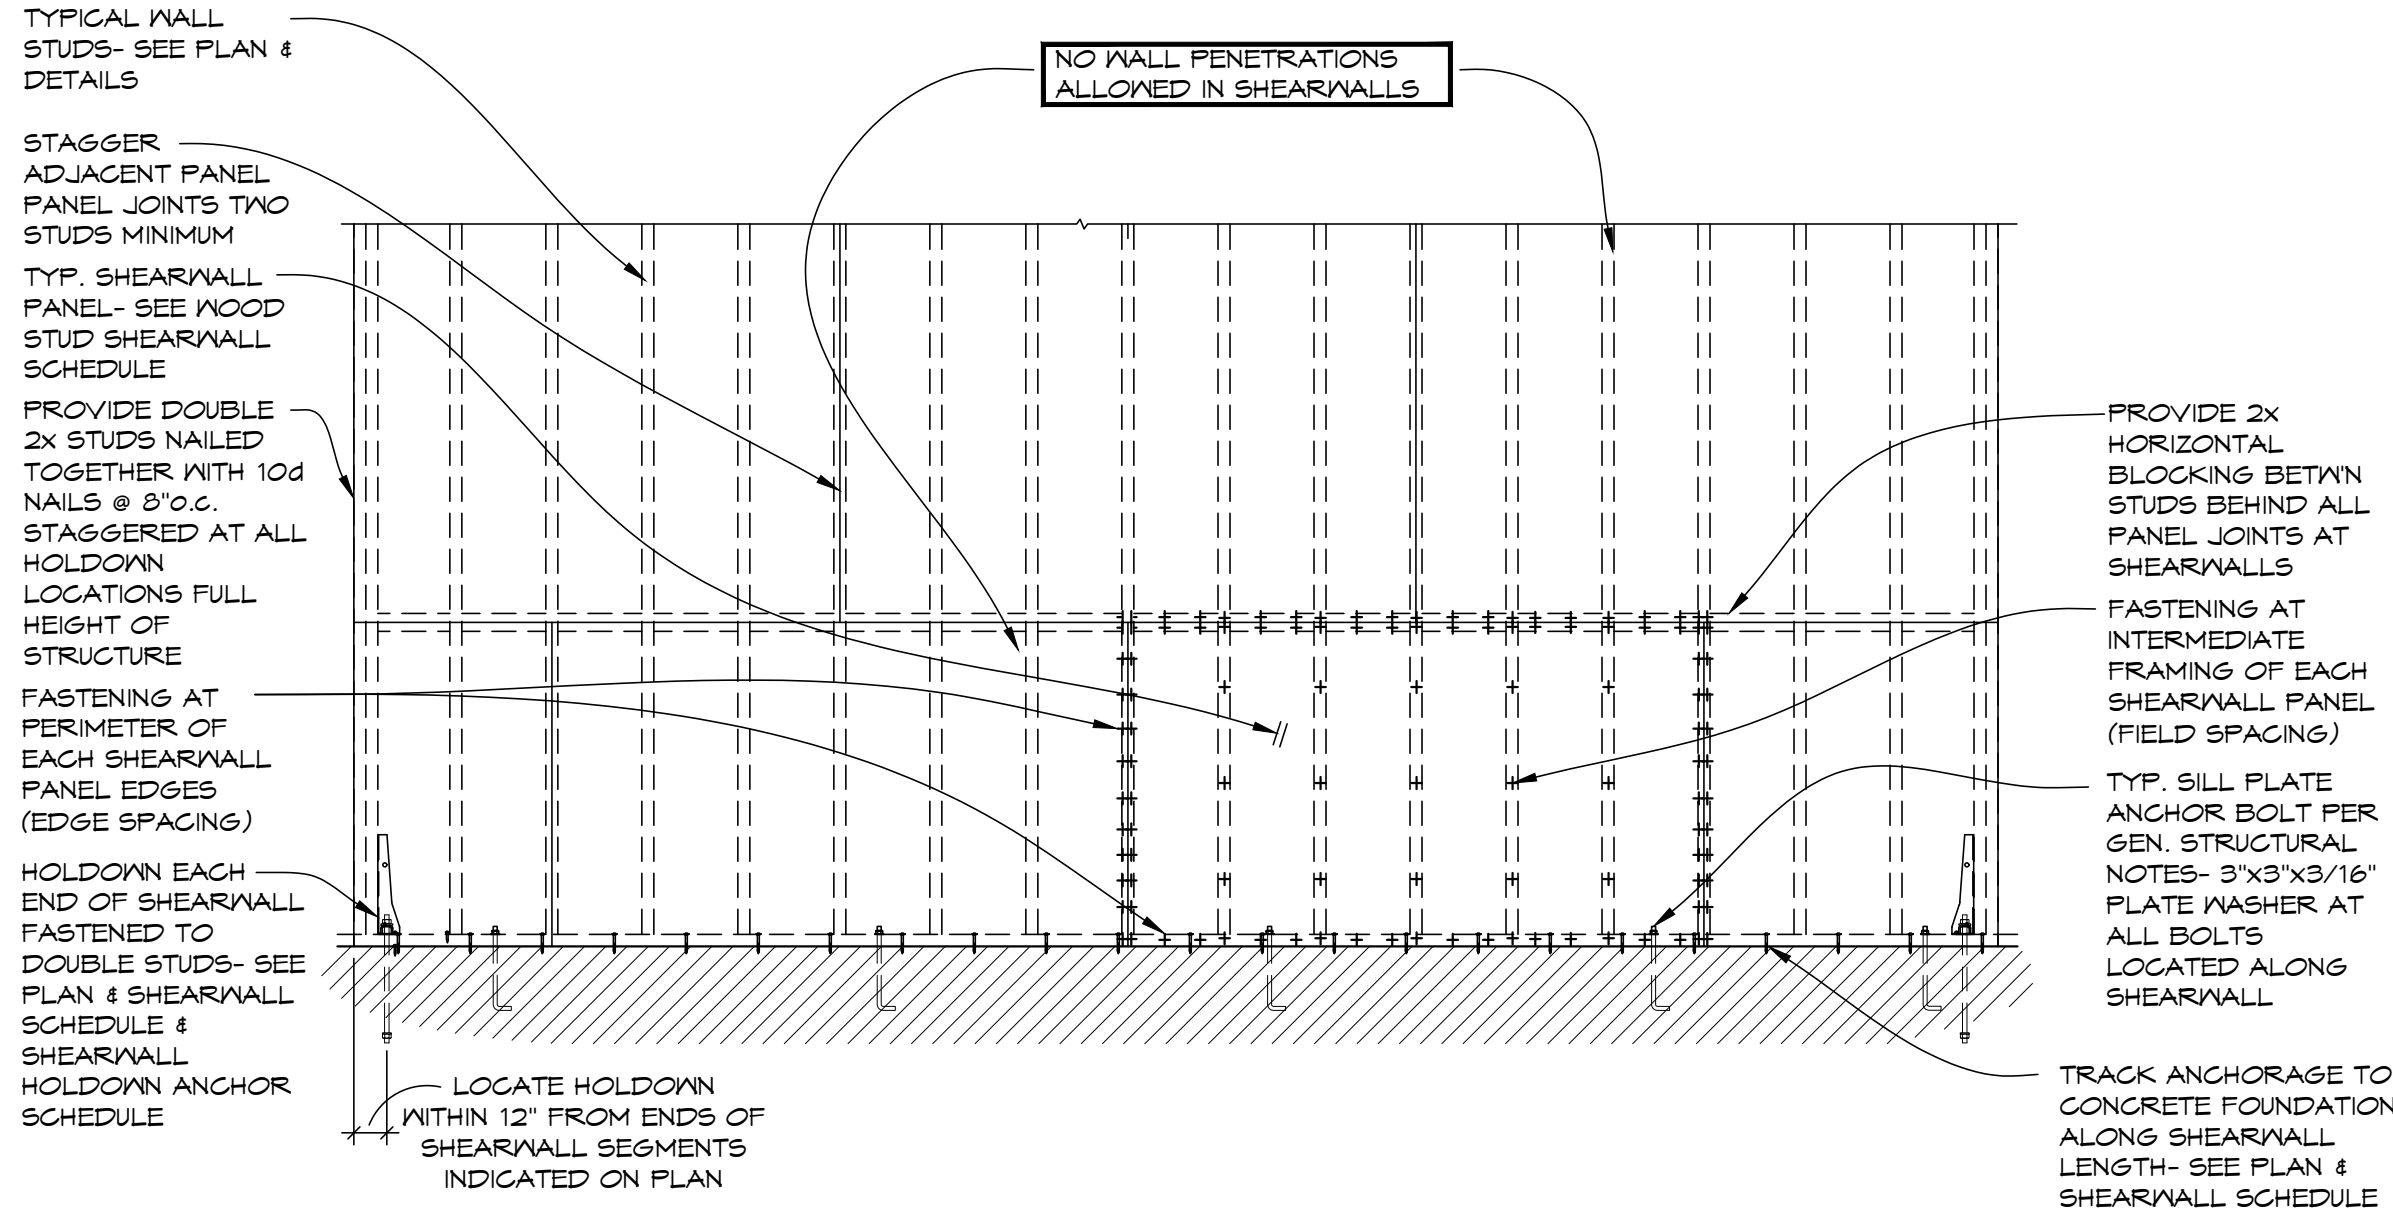


WOOD STUD SHEARWALL SCHEDULE						
MARK	SHEARWALL SHEATHING	PANEL FASTENING		SILL TO ANCHORAGE	HOLDOWNS (SEE ENDS OF SHEARWALLS)	BLOCKING @ PANEL JOINTS
		EDGE	FIELD			
S6.1	EXTERIOR SHEARWALLS R-6 ZIP SHEATHING ALL EXTERIOR WALL FACES	.131 SHANK NAILS @ 4" O.C.	.131 SHANK NAILS @ 12" O.C.	HILTI X-CP FASTENERS @ 10" O.C. & 2 3/4" EDGE DISTANCE	SIMPSON HDUE3-SDS3- SEE PLAN FOR SIZE & DET. 3/56.1	BLOCKED


1 TYPICAL WOOD STUD SHEARWALL FASTENING DETAIL/SCHEDULE
S6.1 SCALE: 3/4"=1'-0"

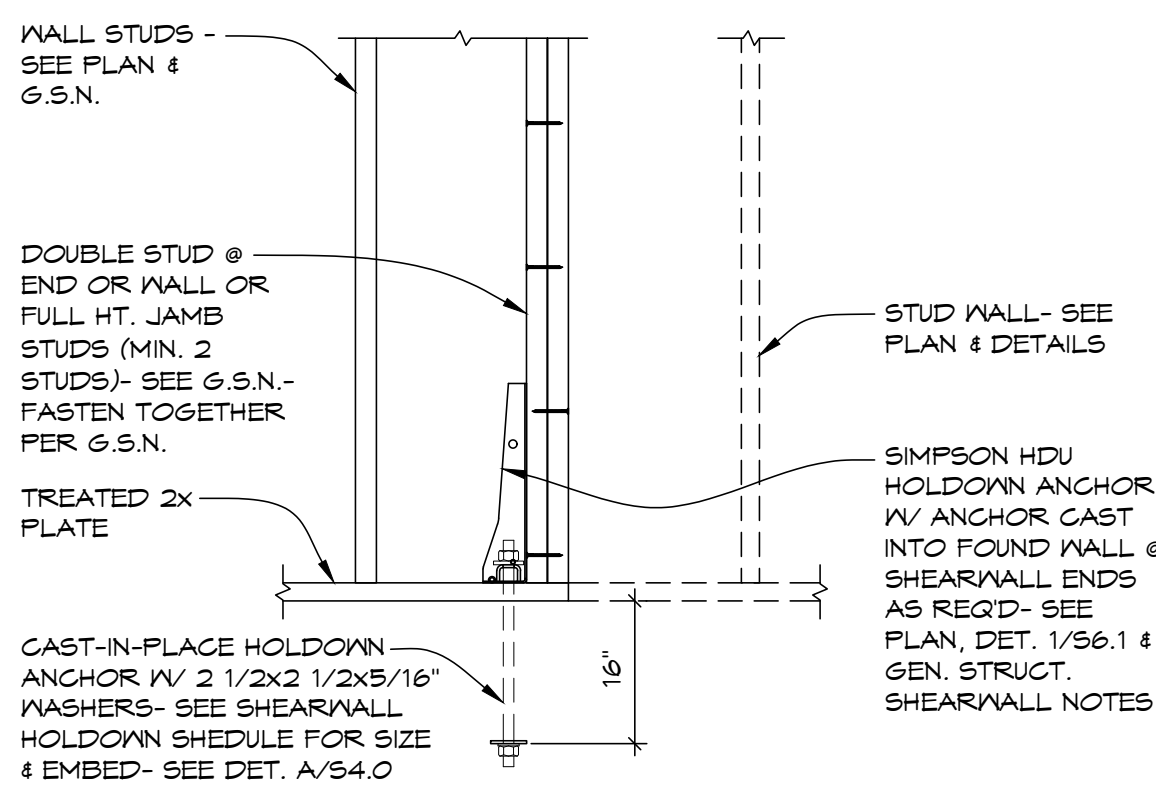

3 HOLDOWN DET. @ DOOR, WINDOW, WALL END
S6.1 SCALE: 3/4"=1'-0"

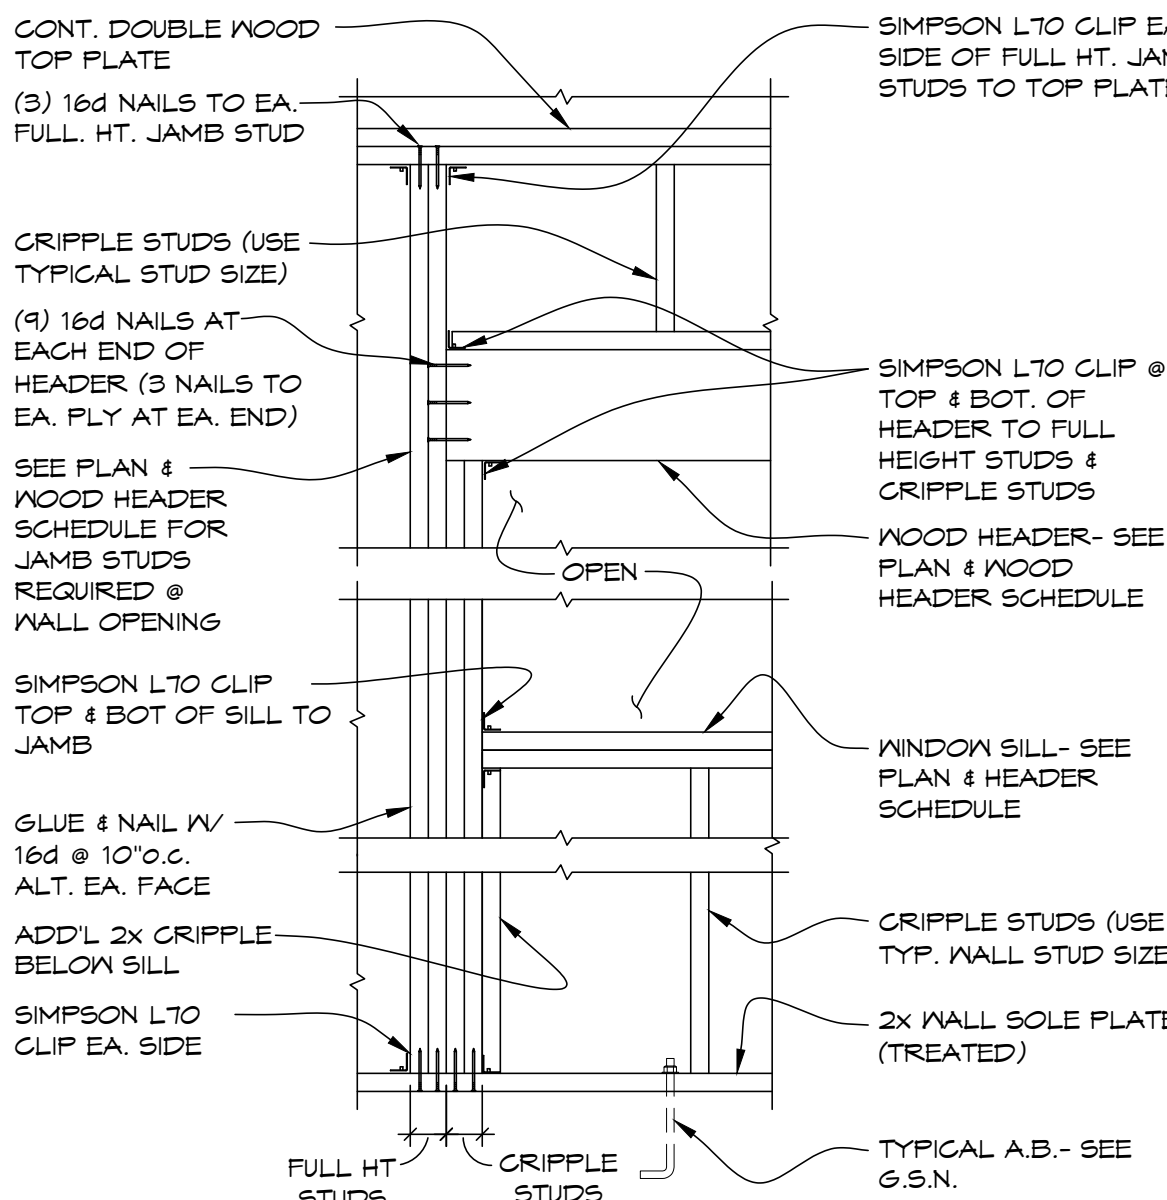

4 WOOD HEADER BRG. DET. @ WINDOW/DOOR
S6.1 SCALE: 3/4"=1'-0"

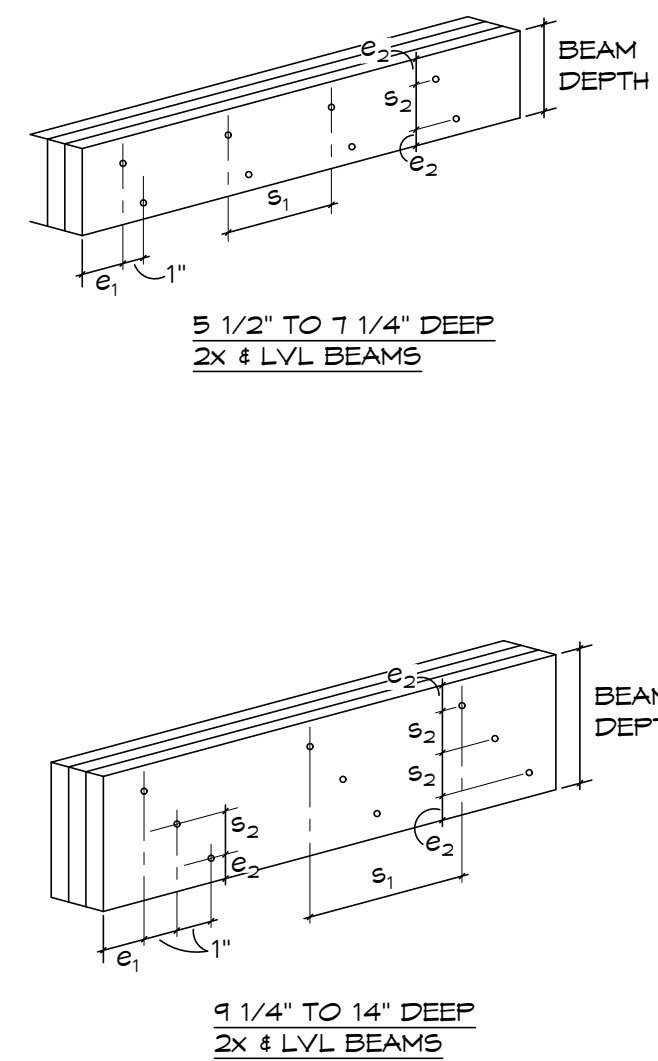

2 TYPICAL MULTI-PLY BEAM FASTENING REQUIREMENTS
S6.1 SCALE: 3/4"=1'-0"


MULTI-PLY BEAM FASTENING SCHEDULE					
PLIES	FASTENERS	e ₁	e ₂ (min.)	s ₁	s ₂ (min.)
(2)-2x6	SIMPSON SDW22300 (2 ROWS)	6"	1 1/2"	16"	2 1/2"
(2)-2x8					3 1/2"
(3)-2x8	SIMPSON SDW22428 (2 ROWS)				3 1/2"
(3)-2x10	SIMPSON SDW22428 (3 ROWS)				2 1/2"
(3)-2x12		3 1/2"			
(2)-1 3/4"x5 1/2" LVL	SIMPSON SDW22338 (2 ROWS)	6"	1 1/2"	16"	2 1/2"
(2)-1 3/4"x7 1/4" LVL					3 1/2"
(2)-1 3/4"x9 1/4"	SIMPSON SDW22338 (3 ROWS)				2 1/2"
(3)-1 3/4"x9 1/4" LVL					2 1/2"
(3)-1 3/4"x11 1/4" LVL	SIMPSON SDW22500 (3 ROWS)	6"	1 1/2"	16"	3 1/2"
(3)-1 3/4"x14" LVL					5"

MULTI-PLY BEAM FASTENING SCHEDULE NOTES:

(1) MULTI-PLY WOOD BEAMS SUPPORTING FRAMING LOAD ON THEIR FACE(S) VIA HANGERS ARE TO BE FASTENED PER THE SCHEDULE AND DIAGRAMS AS SHOWN.

(2) SCREWS (OR NAILS) OTHER THAN SIMPSON SDW TRUSS-PLY SCREWS OF TYPE & LENGTH NOTED ARE NOT ACCEPTABLE FOR FASTENING OF WOOD BEAM PLIES

MULTI-PLY BEAM FASTENING SCHEDULE NOTES:
(1) MULTI-PLY WOOD BEAMS SUPPORTING FRAMING LOAD ON THEIR FACE(S) VIA HANGERS ARE TO BE FASTENED PER THE SCHEDULE AND DIAGRAMS AS SHOWN.
(2) SCREWS (OR NAILS) OTHER THAN SIMPSON SDN TRUSS-PLY SCREWS OF TYPE & LENGTH NOTED ARE NOT ACCEPTABLE FOR FASTENING OF WOOD BEAM PLIES


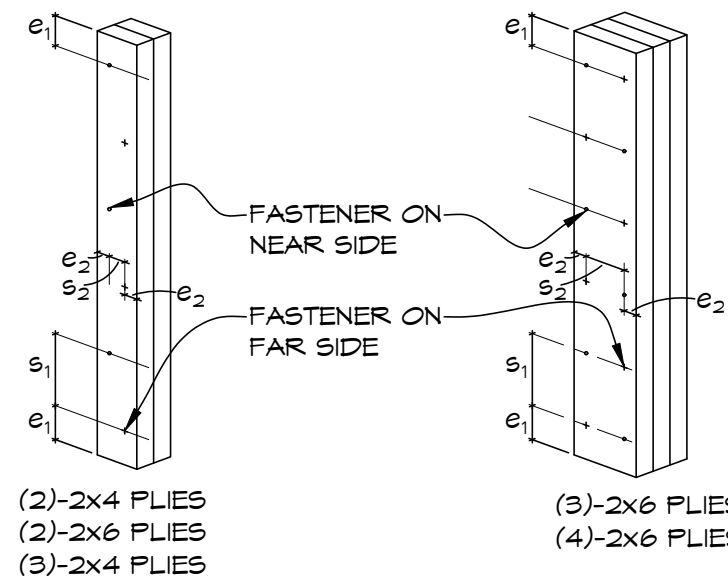


5 TYPICAL MULTI-PLY STUDS FASTENING REQUIREMENTS
S6.1 SCALE: 3/4"=1'-0"

BUILT-UP WOOD COLUMN SCHEDULE					
PLIES	FASTENERS	e ₁	e ₂	s ₁	s ₂
(2)-2x4	0.148" X 9" COMMON WIRE NAILS SIMPSON SDN22300	2 1/2"	1"	6"	N/A
(2)-2x6		3 1/2"	1 1/2"		
(3)-2x4	0.207" X 9" COMMON WIRE NAILS SIMPSON SDN22438	3 1/2"	1 1/2"	8"	N/A
(3)-2x6		3 1/2"	1 1/2"		
(4)-2x6	0.207" X 9" COMMON WIRE NAILS SIMPSON SDN22438	3 1/2"	1 1/2"	8"	2 1/2"
(4)-2x6	SIMPSON SDN22600	3 1/2"	1 1/2"	8"	2 1/2"

NOTES:
(1) BUILT-UP COLUMNS CONSISTING OF 2x WOOD LAMINATIONS MAY BE SUBSTITUTED FOR SOLID WOOD COLUMNS NOTED ON STRUCTURAL DRAWINGS WHEN PLIES ARE FASTENED PER BUILT-UP WOOD COLUMN SCHEDULE SUBSTITUTION NOTE: 4x4 POST = (3)-2x4; 4x6 POST = (3)-2x6; 6x6 POST = (4)-2x6
(2) SCREWS OTHER THAN SIMPSON SDN TRUSS-PLY SCREWS OF TYPE AND LENGTH NOTED ARE NOT ACCEPTABLE FOR FASTENING OF COLUMN PLIES.

1 ADD. #2 0.27.26

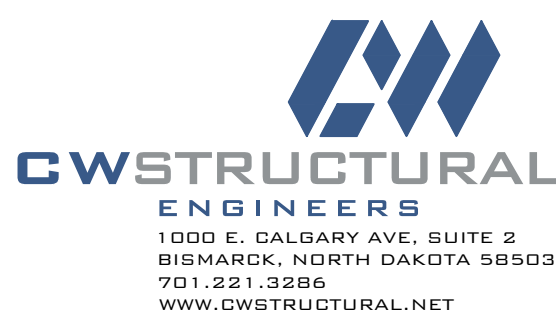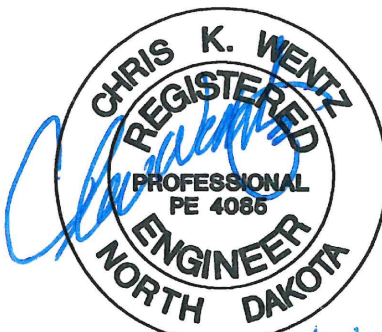

72-185 PAINTERS PATH
SUITE A
PALM DESERT, CA
92260
760.776.4068
INSTRUMENTS OF SERVICE
THESE DRAWINGS ARE AN INSTRUMENT
OF SERVICE AND REMAIN THE PROPERTY
OF KRISTI HANSON ARCHITECTS INC.
THEY ARE NOT TO BE REPRODUCED OR
ALTERED IN ANY WAY, NOR DISCLOSED
OR ASSIGNED TO ANY THIRD PARTY
WITHOUT THE EXPRESS WRITTEN
PERMISSION OF KRISTI HANSON
ARCHITECTS, INC.

CITY APPROVAL:

TRIM RIDING STABLES - GARAGE BUILDING
14532 L-94 Loop East
ND 58645



REVISION LIST	
SCHEMATIC	DESIGN REVIEW
DESIGN DEV.	
CONST. DOCS.	
	BLOG. DEPT.
CITY SUB. 1	
CITY SUB. 2	
	CONSTRUCTION
CONSTR. REV 1	
CONSTR. REV 2	
CONSTR. REV 3	

PROJECT #: C2683A-A
CONTACT: CHRIS
SCALE: AS NOTED
TYPICAL FRAMING
DETAILS

SHEET
S6.1



Q.C. _____

DATE: 8/7/26

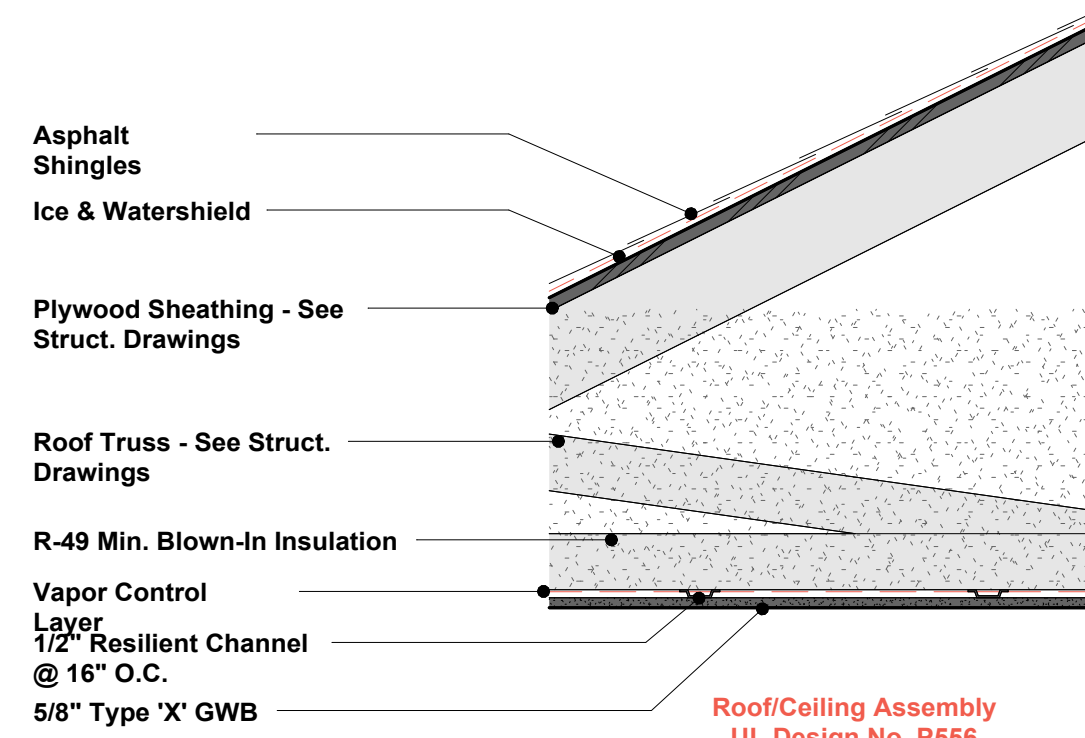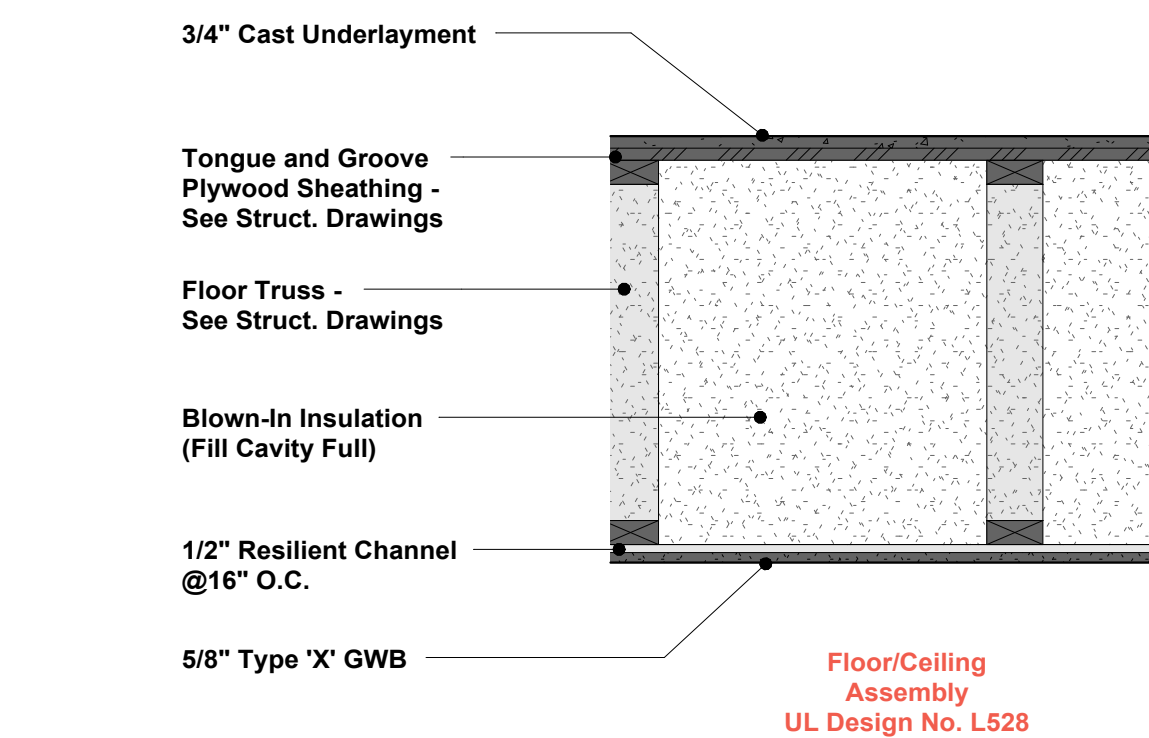

4 Horizontal Assemblies

SCALE 1" = 1'-0"

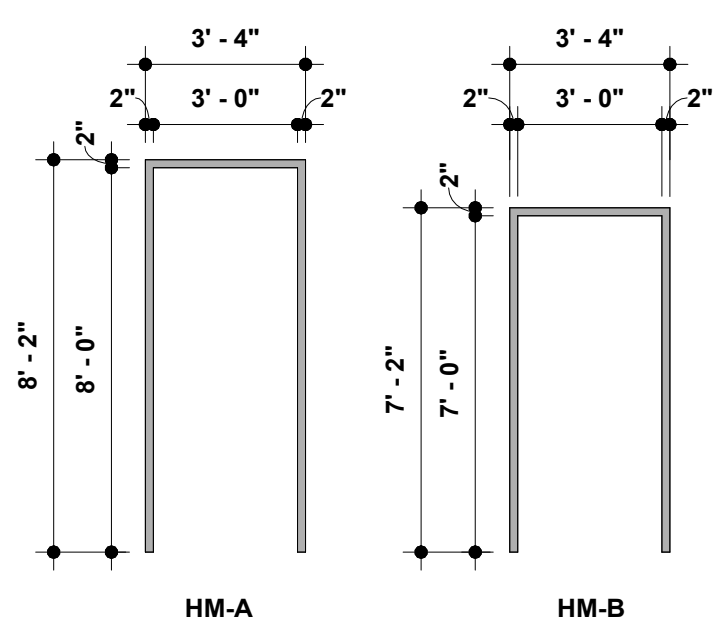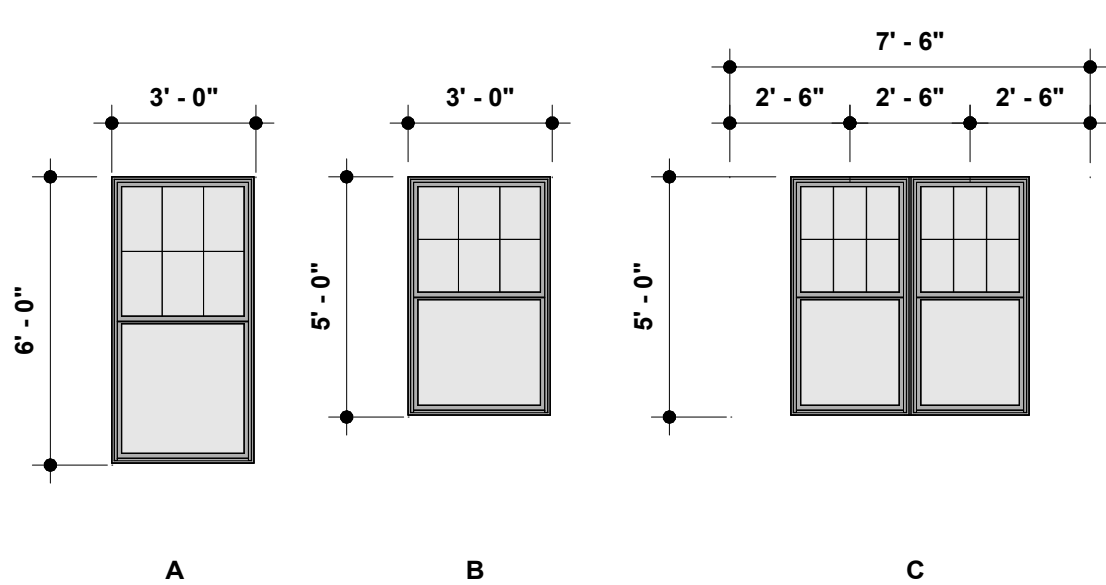


2 Window Elevations

SCALE 1/4" = 1'-0"

3 Frame Types

SCALE 1/4" = 1'-0"

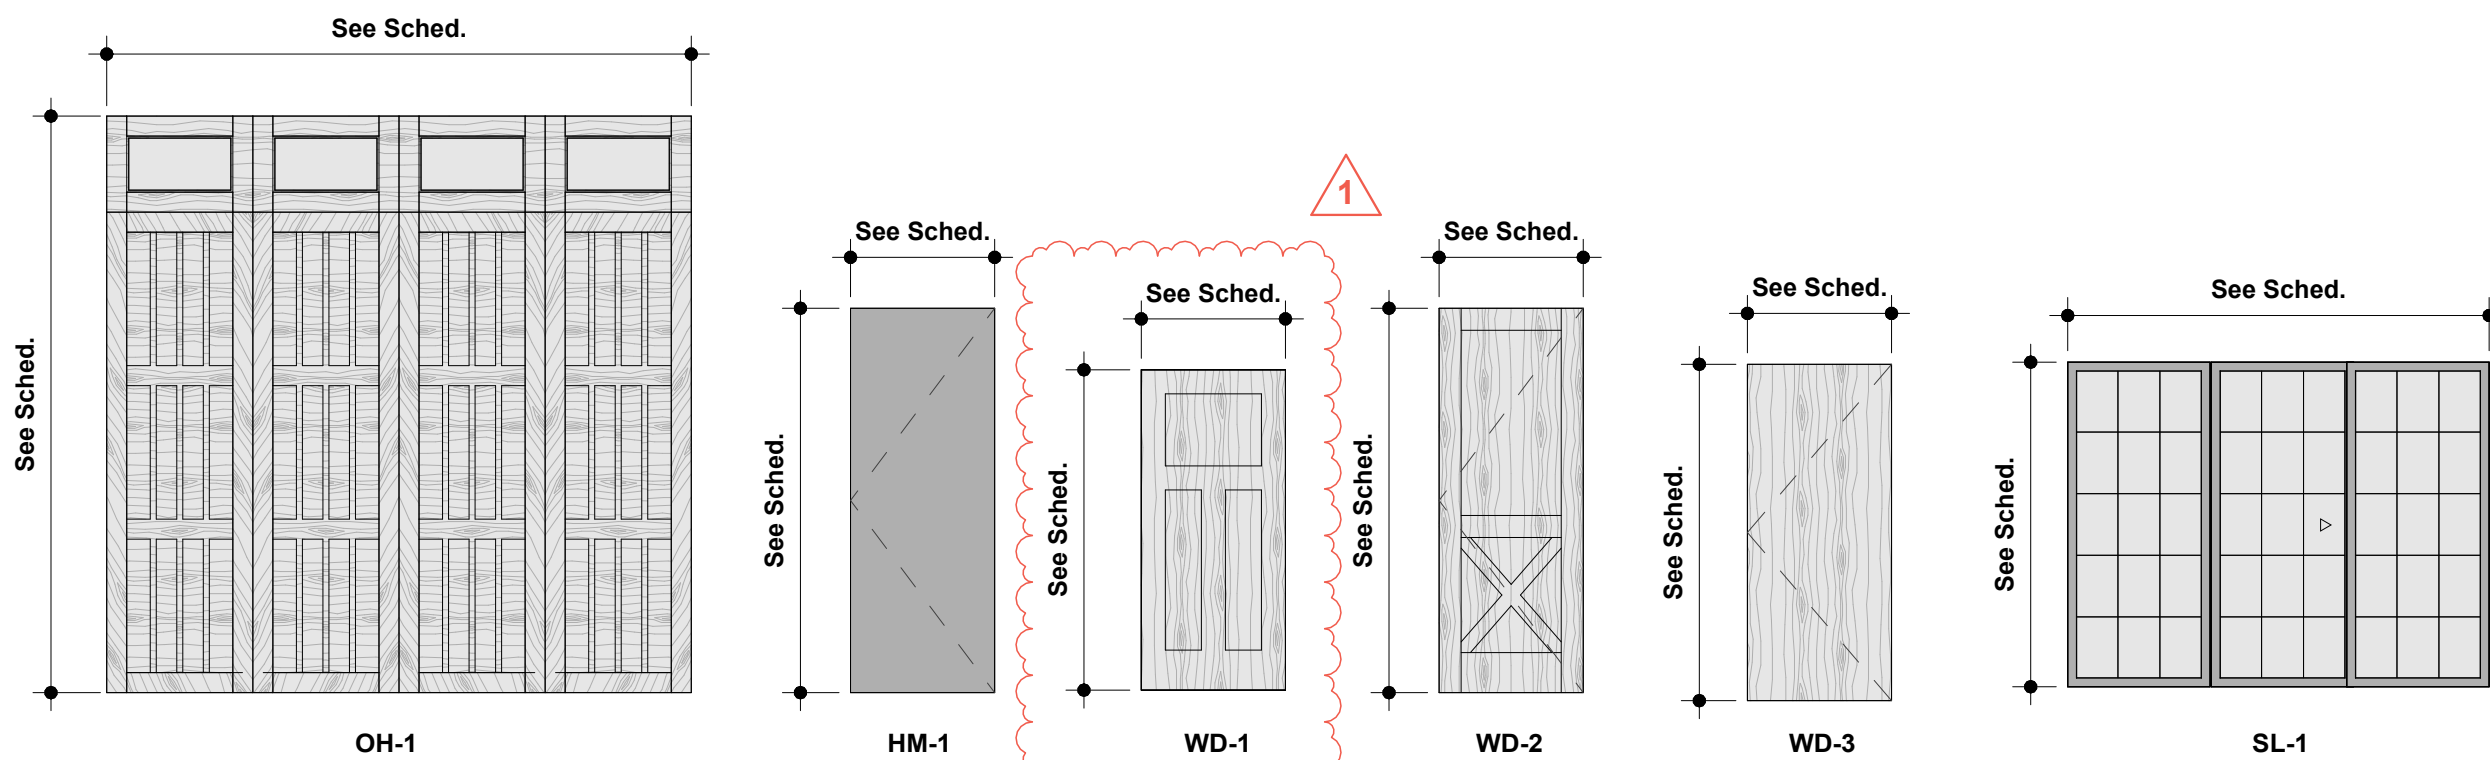

1 Door Elevations

SCALE 1/4" = 1'-0"

DOOR SCHEDULE

Door #	Width	Height	Thickne ss	Door Type	Frame Type	Details		Hardware	Fire Rating	Notes
100A	3' - 0"	8' - 0"	1 3/4"	HM-1	HM-A	3/A3.1	2/A3.1	Group 2		3, 5, Insulate Frame
100B	12' - 0"	12' - 0"	1 3/4"	OH-1	-	2/A3.5	1/A3.5	--		1, 2
100C	12' - 0"	12' - 0"	1 3/4"	OH-1	-	2/A3.5	1/A3.5	Sim		1, 2
100D	12' - 0"	12' - 0"	1 3/4"	OH-1	-	2/A3.5	1/A3.5	--		1, 2
102	3' - 0"	8' - 0"	1 3/4"	HM-1	HM-A	5/A3.1	4/A3.1	Group 5		3, 6
104	3' - 0"	8' - 0"	1 3/4"	HM-1	HM-A	5/A3.1	4/A3.1	Group 4		3, 6
106A	3' - 0"	8' - 0"	1 3/4"	HM-1	HM-A	5/A3.1	4/A3.1	Group 1	60 Min.	3, 6
106B	3' - 0"	8' - 0"	1 3/4"	WD-2	HM-A	3/A3.1	2/A3.1	Group 2		4, Insulate Frame
108	3' - 0"	7' - 0"	1 3/4"	HM-1	HM-B	5/A3.1	4/A3.1	Group 4		3, 6
200	3' - 0"	7' - 0"	1 3/4"	HM-1	HM-B	5/A3.1	4/A3.1	Group 3	60 Min.	3, 6
204A	3' - 0"	7' - 0"	1 3/4"	WD-3	HM-B	5/A3.1	4/A3.1	Group 6		6, 7
204B	4' - 6"	6' - 8"	1 3/8"	WD-1	--	--	--	Group 10		8
206	3' - 0"	6' - 8"	1 3/8"	WD-1	--	--	--	Group 8		8
210	2' - 6"	6' - 8"	1 3/8"	WD-1	--	--	--	Group 8		8
212	3' - 0"	6' - 8"	1 3/8"	WD-1	--	--	--	Group 7		8
214	2' - 6"	6' - 8"	1 3/8"	WD-1	--	--	--	Group 8		8
216	3' - 0"	6' - 8"	1 3/8"	WD-1	--	--	--	Group 7		8
218	2' - 6"	6' - 8"	1 3/8"	WD-1	--	--	--	Group 7		8
220	8' - 11 1/2"	6' - 11 1/2"	1 1/4"	SL-1	--	--	--	--		
224	3' - 0"	6' - 8"	1 3/8"	WD-1	--	--	--	Group 7		8
226	2' - 6"	6' - 8"	1 3/8"	WD-1	--	--	--	Group 8		8
228	2' - 6"	6' - 8"	1 3/8"	WD-1	--	--	--	Group 7		8
230	2' - 6"	6' - 8"	1 3/8"	WD-1	--	--	--	Group 7		8
234	3' - 0"	7' - 0"	1 3/4"	WD-3	HM-B	5/A3.1	4/A3.1	Group 9		3, 6

DOOR NOTES

- Overhead Door - Basis of Design: C.H.I Overhead Doors - Style: Stamped Carriage House 5916 - Finish: Solid Color (Verify w/Architect) - Window Inserts: Madison - Long - Glass Finish: Plain - Exterior Hardware: Permanent Spade
- Overhead Door Opener - Basis of Design: LiftMaster Model T501L5 (Logic 5.0)
- Hollow Metal Door - Basis of Design: Steelcraft - L Series Flush Door - Finish: Paint to Match Frame
- Wood Door - Basis of Design: Rustica Care Taker Front Door - Wood Species: Cedar - Finish: ST-1
- Door and frame to be insulated.
- Hollow Metal Frame - Basis of Design: RediFrame hollow metal frames with standard snap on trim - Finish: RediFrame Brown
- Solid Core Door - Basis of Design: Lynden Doors Laminate Architectural Series - Finish: LAM-1 - See Door Types for Glazing Locations
- Hollow Core Door - Basis of Design: Lynden Doors Molded - Style: Flat Panels Smooth Yarrow - Finish: PT-3

WINDOW SCHEDULE

MARK	WIDTH	HEIGHT	MANUFACTURER	MODEL	DETAIL			NOTES
					HEAD	JAMB	SILL	
A	2' - 11 1/2"	5' - 11 1/2"	Marvin Windows and Doors	ESSH3060 E	6/A3.1	7/A3.1	8/A3.1	
B	2' - 11 1/2"	4' - 11 1/2"	Marvin Windows and Doors	ESSH3050 E	6/A3.1	7/A3.1	8/A3.1	
C	4' - 11 1/2"	4' - 11 1/2"	Marvin Windows and Doors	ESSH2650	6/A3.1	7/A3.1	8/A3.1	

Window Notes

- Contractor to field verify all rough openings prior to procurement.
- Contractor to provide spray foam insulation at shims.
- Contractor to provide self-adhesive flashing membrane at head, jamb and sill locations per manufacturer's recommendation.
- Contractor to provide all required hardware at egress window locations to meet code.
- Second Floor window head heights to be 7'-0" A.F.F.

DOOR HARDWARE

Provide hardware specified or required to make door fully functional and compliant with all applicable codes. Door hardware to be of an approved manufacturer. The following manufacturers are approved: Dorma, Falcon, Ives, LCN, Sargent, and Schlage.

GROUP 1
Each Door shall have:
(3) Butt Hinges
(1) Door Closer
(1) Passage Function Lockset
(1) Wall Stop
(1) Smoke Seal
(1) Door Sweep
(1) Kick Plate (Egress Side)
Finish: 619 (Satin Nickel)
Basis of Design: Schlage ND Series w/Latitude Lever

GROUP 4
Each Door shall have:
(3) Butt Hinges
(1) Storeroom Function Lockset
(1) Wall Stop
(1) Kick Plate
Finish: 619
Basis of Design: Schlage ND Series w/Latitude Lever

GROUP 7
(3) Butt Hinges
(1) Privacy Function Lockset
Finish: 619
Basis of Design: Schlage Latitude w/Collins Trim

GROUP 2
Each Door shall have:
(3) Butt Hinges
(1) Door Closer
(1) Storeroom Function Lockset
(1) Wall Stop
(1) Weather Stripping
(1) Threshold
(1) Gasketing
(1) Door Sweep
(1) Kick Plate (Stair Side)
Finish: 619
Basis of Design: Schlage ND Series w/Latitude Lever

GROUP 5
Each Door shall have:
(3) Butt Hinges
(1) Privacy Function Lockset
(1) Wall Stop
(1) Kick Plate
Finish: 619
Basis of Design: Schlage ND Series w/Default Lever

GROUP 8
(3) Butt Hinges
(1) Passage Function Lockset
Finish: 619
Basis of Design: Schlage Latitude w/Collins Trim

GROUP 3
Each Door shall have:
(3) Butt Hinges
(1) Door Closer
(1) Passage Function Lockset
(1) Wall Stop
(1) Smoke Seal
(1) Kick Plate (Egress Side)
Finish: 619 (Satin Nickel)
Basis of Design: Schlage ND Series w/Latitude Lever


GROUP 6
Each Door shall have:
(3) Butt Hinges
(1) Door Closer
(1) Apartment/Privacy Function Lockset
(1) Wall Stop
(1) Concealed Door Position Sensor
Finish: 619
Basis of Design: Schlage XE360M-D Series w/Latitude Lever

GROUP 9
Each Door shall have:
(3) Butt Hinges
(1) Storeroom Function Lockset
(1) Wall Stop
Finish: 619
Basis of Design: Schlage ND Series w/Latitude Lever

GROUP 10
Each Door shall have:
(1) Heavy-Duty Bypass Track with Fascia: Aluminum track with snap-on primed fascia to be field-painted to match adjoining wall/trim - Basis of Design: Johnson Hardware 138F
(2) Flush Pulls - Basis of Design: Ives 22
(1) Floor-Mounted Center Guide
Finish: 619


FINISHES LEGEND							
PAINT and STAIN:				WALLS:			
PT-1	Interior Paint	Walls	Sherwin Williams - SW 9588 - High Sierra in eg-shel	WT-1	Wall Tile	Apartment Bathroom	MSI - Cabana - Finish: Honey - Size 9" x 47" - Grout: TEC - Sable 925
PT-2	Interior Paint	Ceilings	Sherwin Williams - SW 9588 - High Sierra in flat				
PT-3	Interior Paint	Trim	Sherwin Williams - SW 7005 - Pure White in Satin				
ST-1	Exterior Stain	Exterior Wood	Verify finish w/Architect	BASE:			
ST-2	Interior Stain	Wd. Handrail/Wd. Trim	Verify finish w/Architect	VB-1	Vinyl Base	First Floor	Tarkett - 4" Vinyl Base - Color: 63 Burnt Umber
				WB-1	Wood Base	Units	4 1/4" MDF Flat Stock - Paint: PT- 3
FLOORING:				MOULDINGS and TRIM:			
LVT-1	Luxury Vinyl Tile	Units	J + J Flooring - Retreat V5056 - Finish: Beauty 1185 - Size: 9" x 48"	MT-1	Metal Tile Trim	Apartment Bathroom	Schluter - JOLLY - Finish: Brushed Nickel
CPT-1	Broadloom Carpet	Unit Bedrooms/Closets	J + J Flooring - Fairway II N9117 - Finish: Cypress Point 9785	FT-1	Floor Transition	Unit Floor Transitions	Pin Metal - Finish: Hammered Nickel
DECK-1	Decking	Apartment Balcony	Bison Innovative Products - 4' x 2' Ipe Wood Tile - Ribbed	FIBER REINFORCED PLASTIC:			
CONC-1	Burnished Concrete	First Floor	Matte Finish	FRP-1	Fiber Reinforced Plastic	HVAC/Mech. & Bathroom	Embossed White w/Matching Mouldings
SOLID SURFACE:				WOOD:			
SS-1	Corian Solid Surface	Apartment Countertops	Corian Solid Surface - Limestone Prima	WD-1	Wood Trim	Exterior	Wd. Boards - Stain: ST-1 - Species: Cedar
PVC				METAL:			
PVC-1	PVC	Window Sills	PVC Window Sills - Paint: PT-3	M-1	Fascia, Trim, Etc.	Exterior	EDCO Fascia and Trim - Color: Statuary Bronze
				M-2	Gutter	Exterior	EDCO Rainware - Size: 3" x 4" - Color: Statuary Bronze
Laminate				M-3	Downspout	Exterior	EDCO Rainware - Color: Statuary Bronze
LAM-1	Plastic Laminate	Commercial Int. Doors	Wilsonart - Neowalnut 7991K-28	M-4	Outside Corner Trim	Exterior	MAC Metal Architectural - M21H Molding - Color: Match Siding
EXTERIOR SOFFIT & CLADDING:				M-5	Inside Corner Trim	Exterior	MAC Metal Architectural - M22H Molding - Color: Match Siding
SS-1	Prefinished Stl. Siding	Exterior	MAC Metal Architectural - Board and Batten - Finish: Cork	M-6	Window Sill	Exterior	MAC Metal Architectural - M04H Molding - Color: Match Siding
MS-1	Prefinished Mtl. Soffit	Exterior	EDCO Vented Mtl. Soffit - Color: Statuary Bronze	M-7	Cladding Starter Strip	Exterior	MAC Metal Architectural - M17H Molding - Color: Match Siding
				M-8	Top of Wall Trim	Exterior	MAC Metal Architectural - M04H Molding - Color: Match Siding
				M-9	Door Jamb	Exterior	MAC Metal Architectural - M05H Molding - Color: Match Siding
MASONRY:				CASEWORK:			
SV-1	Stone Veneer	Exterior	Fon Du Lac Stone - Traditional Collection - Color: Fon Du Lac Harvest	CB-1	Laminate Cabinetry	Apartment	Wilsonart - Neowalnut 7991K-28
ROOFING				PULL HARDWARE:			
AS-1	Asphalt Shingles	Exterior	Certainteed Landmark Shingles - Color: Driftwood	PULL-1	Cabinetry Bar Pull	Throughout	Mastercraft - 3" Spoon Style - Satin Nickel
NOTES: 1. All GWB walls slated to receive paint to be finished to a smooth Level '4' 2. Provide Melamine Interior on all casework - Finish: Natural 3. All Materials and Products to be installed per manufacturer's specifications 4. All windows to have drywall returns at the head and jamb.							

FINISH SCHEDULE											
SPACE		FLOORING	BASE	WALLS				CEILING		CABINETRY	NOTES
ROOM	NO.			NORTH	SOUTH	EAST	WEST	FINISH	HEIGHT		
Garage	100	CONC-1	-	PT-1	PT-1	PT-1	PT-1	PT-2	See RCP	-	
Bathroom	102	CONC-1	-	FRP-1	FRP-1	FRP-1	FRP-1	PT-2	See RCP	-	
Mech.	104	CONC-1	-	Unfin.	Unfin.	Unfin.	Unfin.	Unfin.	See RCP	-	
Stair	106	CPT-2	VB-1	PT-1	PT-1	PT-1	PT-1	PT-2	See RCP	-	
Storage	108	CPT-2	-	PT-1	PT-1	PT-1	PT-1	PT-2	See RCP	-	
Stair	200	CPT-2	VB-1	PT-1	PT-1	PT-1	PT-1	PT-2	See RCP	-	
Hallway	202	CPT-2	VB-1	PT-1	PT-1	PT-1	PT-1	PT-2	See RCP	-	
Entry	204	LVT-1	WB-1	PT-1	PT-1	PT-1	PT-1	PT-2	See RCP	-	
Laundry	206	LVT-1	WB-1	PT-1	PT-1	PT-1	PT-1	PT-2	See RCP	CB-1	
Hallway	208	LVT-1	WB-1	PT-1	-	PT-1	PT-1	PT-2	See RCP	-	
Closet	210	CPT-1	WB-1	PT-1	PT-1	PT-1	PT-1	PT-2	See RCP	-	
Bedroom	212	CPT-1	WB-1	PT-1	PT-1	PT-1	PT-1	PT-2	See RCP	-	
Closet	214	CPT-1	WB-1	PT-1	PT-1	PT-1	PT-1	PT-2	See RCP	-	
Bedroom	216	CPT-1	WB-1	PT-1	PT-1	PT-1	PT-1	PT-2	See RCP	-	
Bathroom	218	LVT-1	WB-1	PT-1	PT-1	PT-1	PT-1	PT-2	See RCP	CB-1	
Living Room	220	LVT-1	WB-1	PT-1	-	PT-1	PT-1	PT-2	See RCP	-	
Kitchen	222	LVT-1	WB-1	-	PT-1	PT-1	PT-1	PT-2	See RCP	CB-1	
Primary Bedroom	224	CPT-1	WB-1	PT-1	PT-1	PT-1	PT-1	PT-2	See RCP	-	
Prim. Closet	226	CPT-1	WB-1	PT-1	PT-1	PT-1	PT-1	PT-2	See RCP	-	
Primary Bath.	228	LVT-1	WB-1	PT-1/WT-1	PT-1/WT-1	PT-1/WT-1	PT-1/WT-1	PT-2	See RCP	CB-1	
Toilet	230	LVT-1	WB-1	PT-1	PT-1	PT-1	PT-1	PT-2	See RCP	-	
Closet	232	CPT-1	WB-1	PT-1	PT-1	PT-1	PT-1	PT-2	See RCP	-	
HVAC	234	CPT-2	VB-1	PT-1	PT-1	PT-1	PT-1	PT-2	See RCP	-	

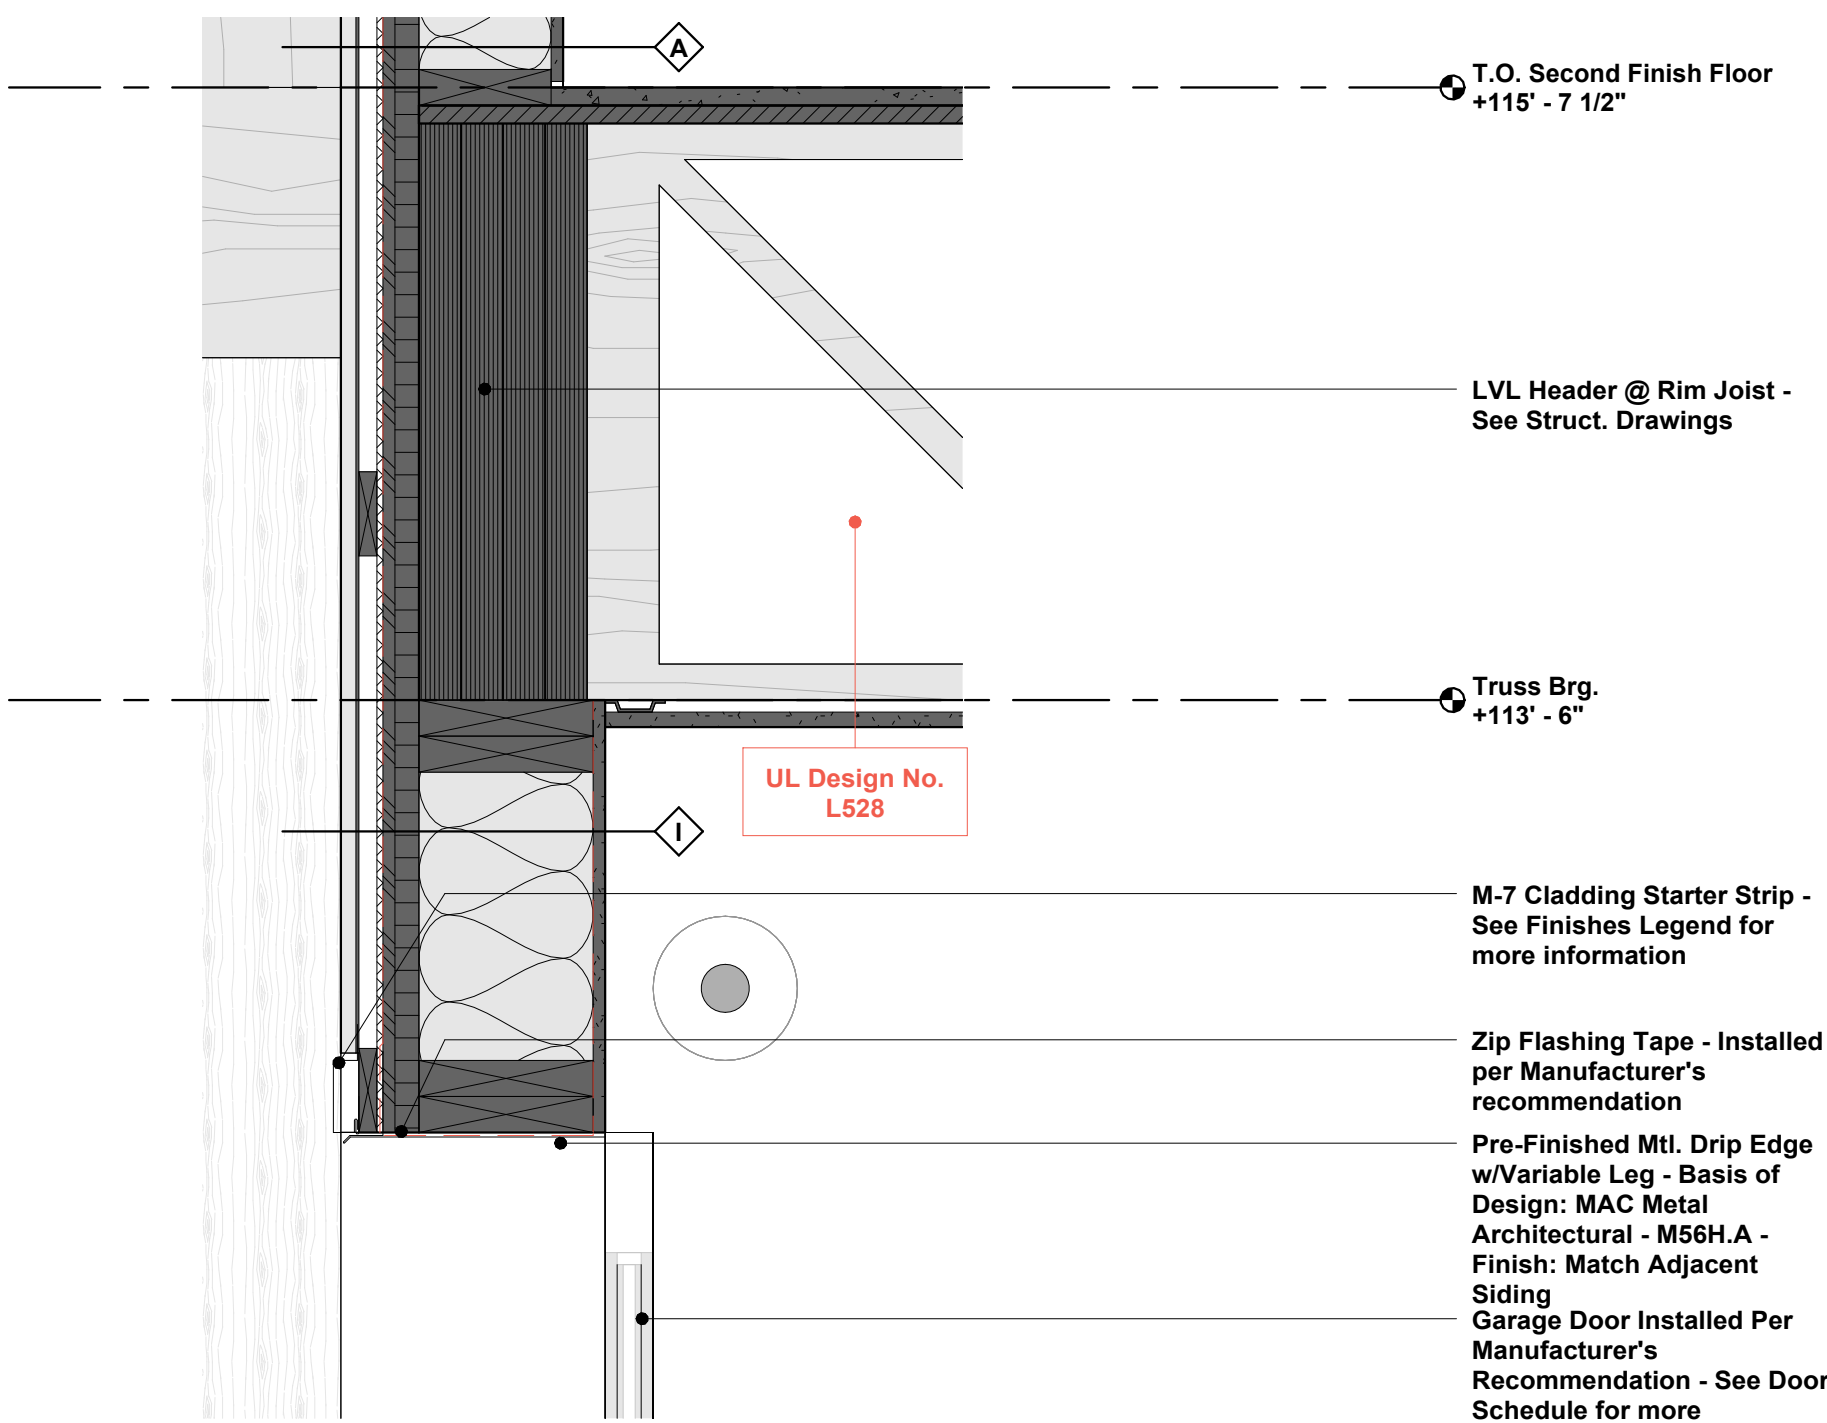


1 Overhead Door Detail - Head

SCALE 1 1/2" = 1'-0"

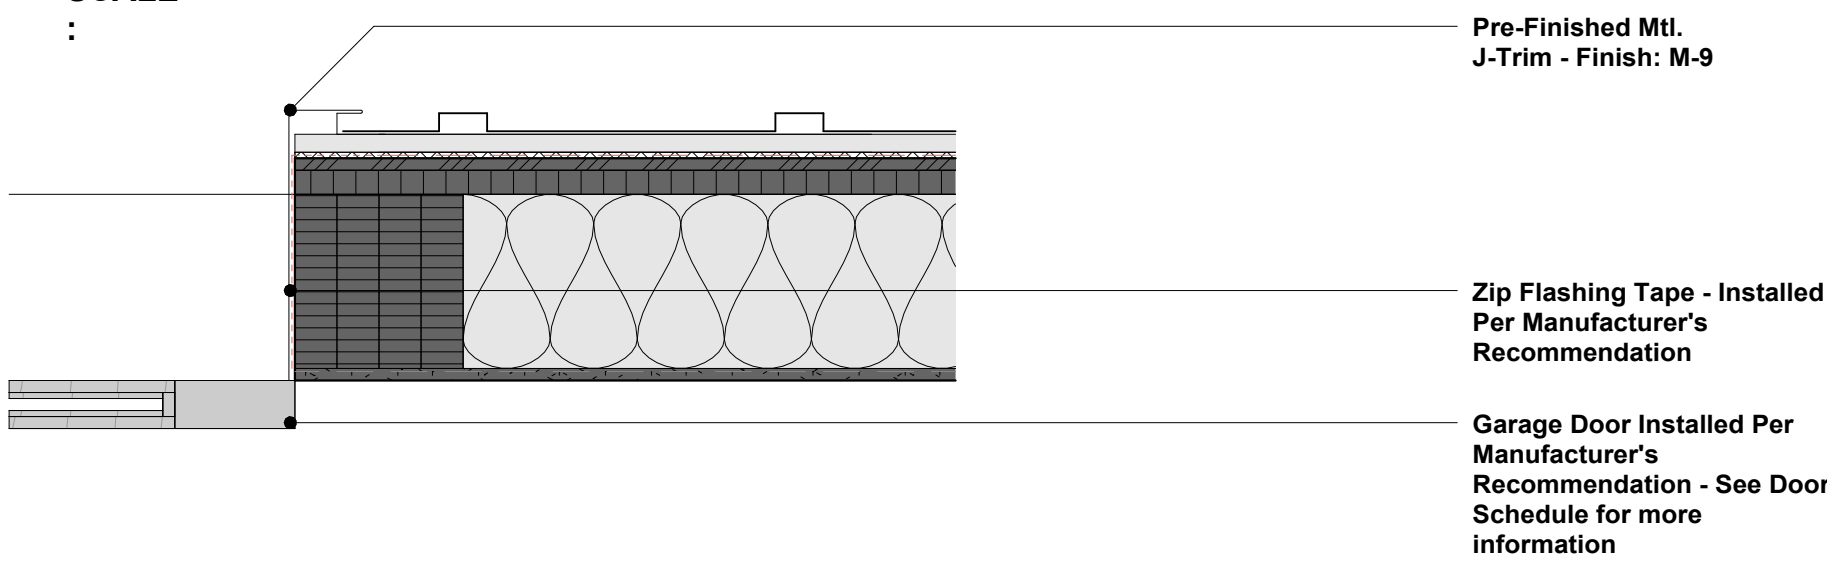


2 Overhead Door Detail - Jamb

SCALE 1 1/2" = 1'-0"

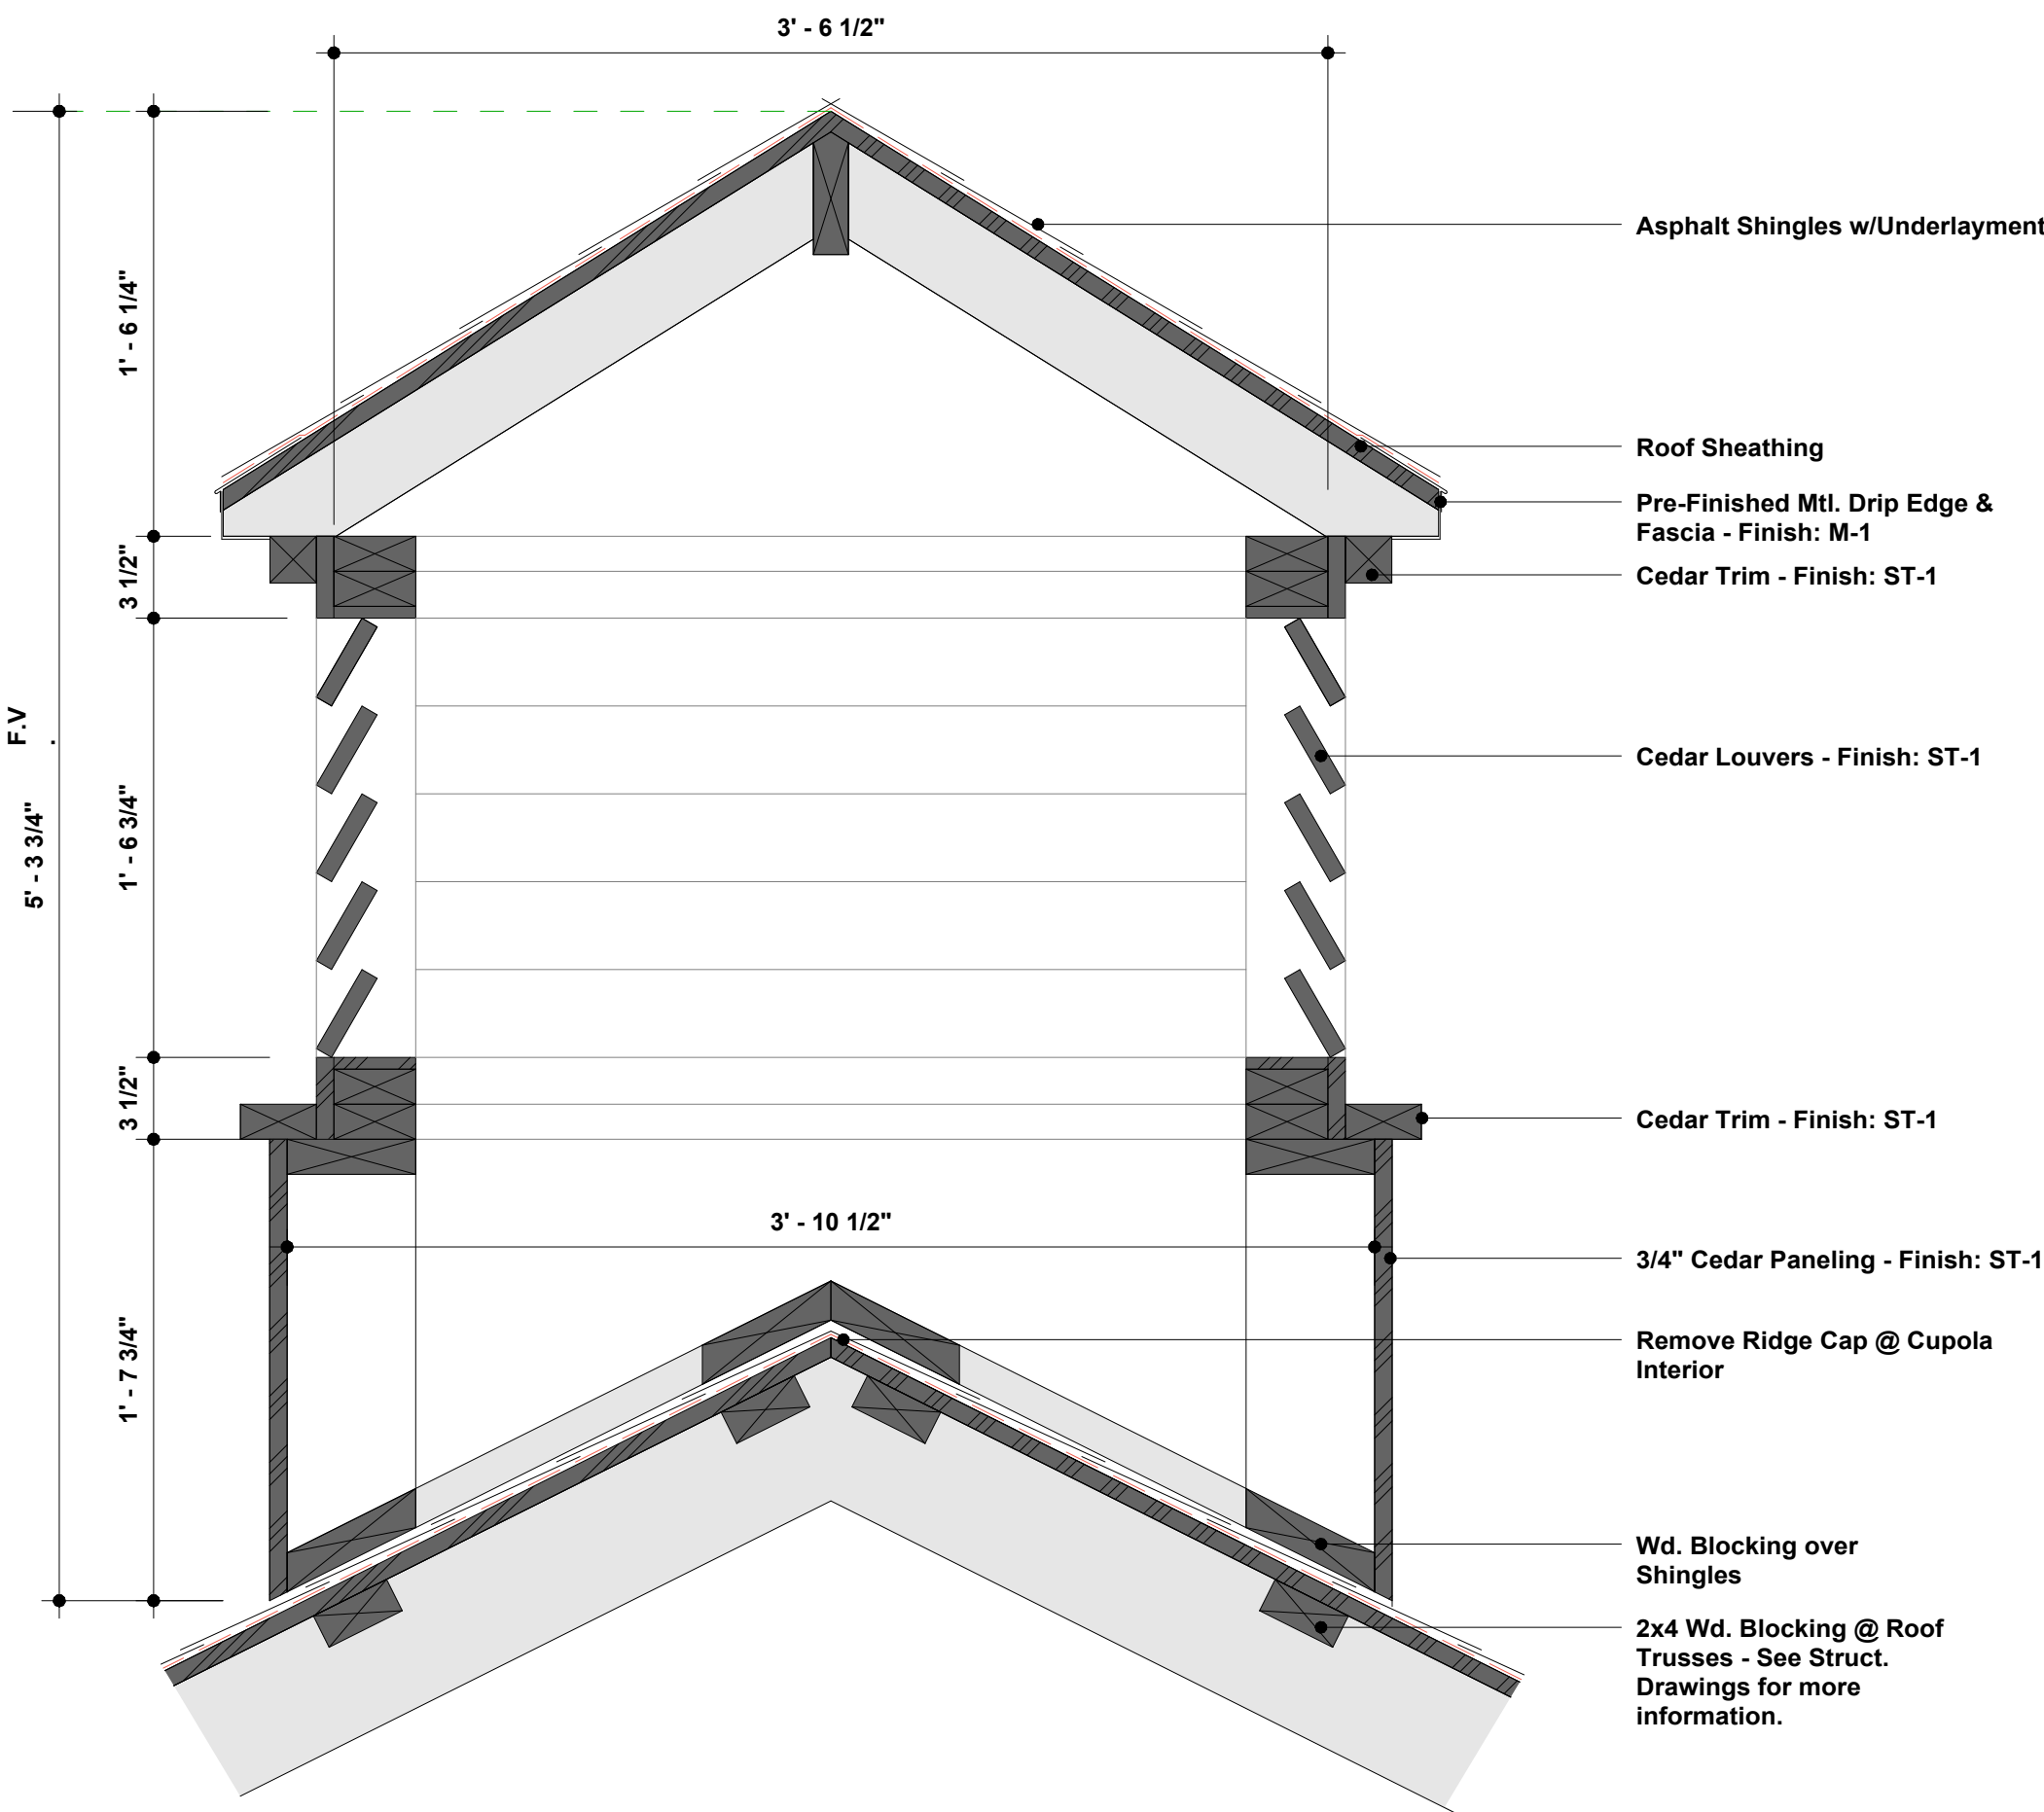

3 Cupola Details

SCALE 1 1/2" = 1'-0"

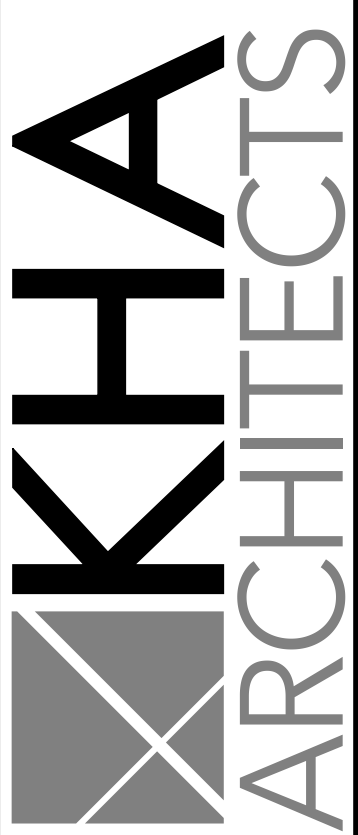

72-185 PAINTERS PATH
SUITE A
PALM DESERT, CA
92260
760.776.4068

INSTRUMENTS OF SERVICE
THESE DRAWINGS ARE AN INSTRUMENT
OF SERVICE AND REMAIN THE PROPERTY
OF KRISTI HANSON ARCHITECTS INC.
THEY ARE NOT TO BE REPRODUCED OR
ALTERED IN ANY WAY, NOR DISCLOSED
OR ASSIGNED TO ANY THIRD PARTY
WITHOUT THE EXPRESS WRITTEN
PERMISSION OF KRISTI HANSON
ARCHITECTS, INC.

CITY APPROVAL:

TRMF RIDING STABLES - GARAGE
14532 L-94 Loop East
ND 58645



REVISION LIST


SCHEMATIC	DESIGN DEV.	CONST. DOCS.	CITY SUB. 1	CITY SUB. 2	ADDENDUM #2 09/01/2026	CONSTR. REV 2	CONSTR. REV 3


PROJECT # : 2515

CONTACT : KRISTI


SCALE: AS NOTED

SCHEDULES

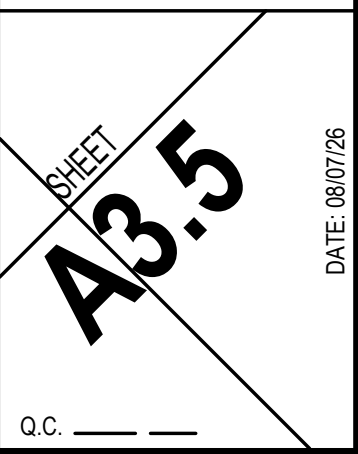

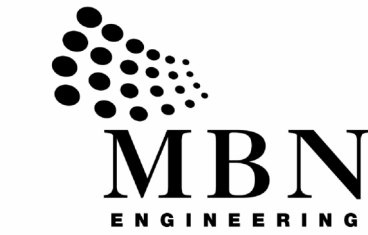

701 MAIN AVENUE
FARGO, ND 58103
PHONE: 701.478.6336
FAX: 701.478.6340

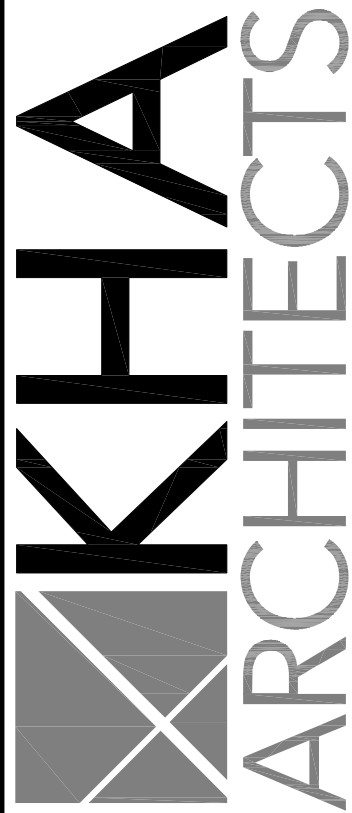

72-185 PAINTERS PATH
SUITE A
PALM DESERT, CA
92260
760.776.4068

INSTRUMENTS OF SERVICE
THESE DRAWINGS ARE AN INSTRUMENT
OF SERVICE AND REMAIN THE PROPERTY
OF KRISTI HANSON ARCHITECTS INC.
THEY ARE NOT TO BE REPRODUCED OR
ALTERED IN ANY WAY, NOR DISCLOSED
OR ASSIGNED TO ANY THIRD PARTY
WITHOUT THE EXPRESS WRITTEN
PERMISSION OF KRISTI HANSON
ARCHITECTS, INC.

CITY APPROVAL:

TRMF RIDING STABLES - GARAGE
14532 L-94 Loop East
ND 58645




REVISION LIST	
SCHEMATIC	DESIGN REVIEW
DESIGN DEV.	
CONST. DOCS.	
	BLDG. DEPT.
CITY SUB. 1	
CITY SUB. 2	
	CONSTRUCTION
CONSTR. REV 1	
CONSTR. REV 2	
CONSTR. REV 3	

PROJECT #: 2515

CONTACT : KRISTI

SCALE: AS NOTED

GARAGE -
SECOND FLOOR
POWER PLAN

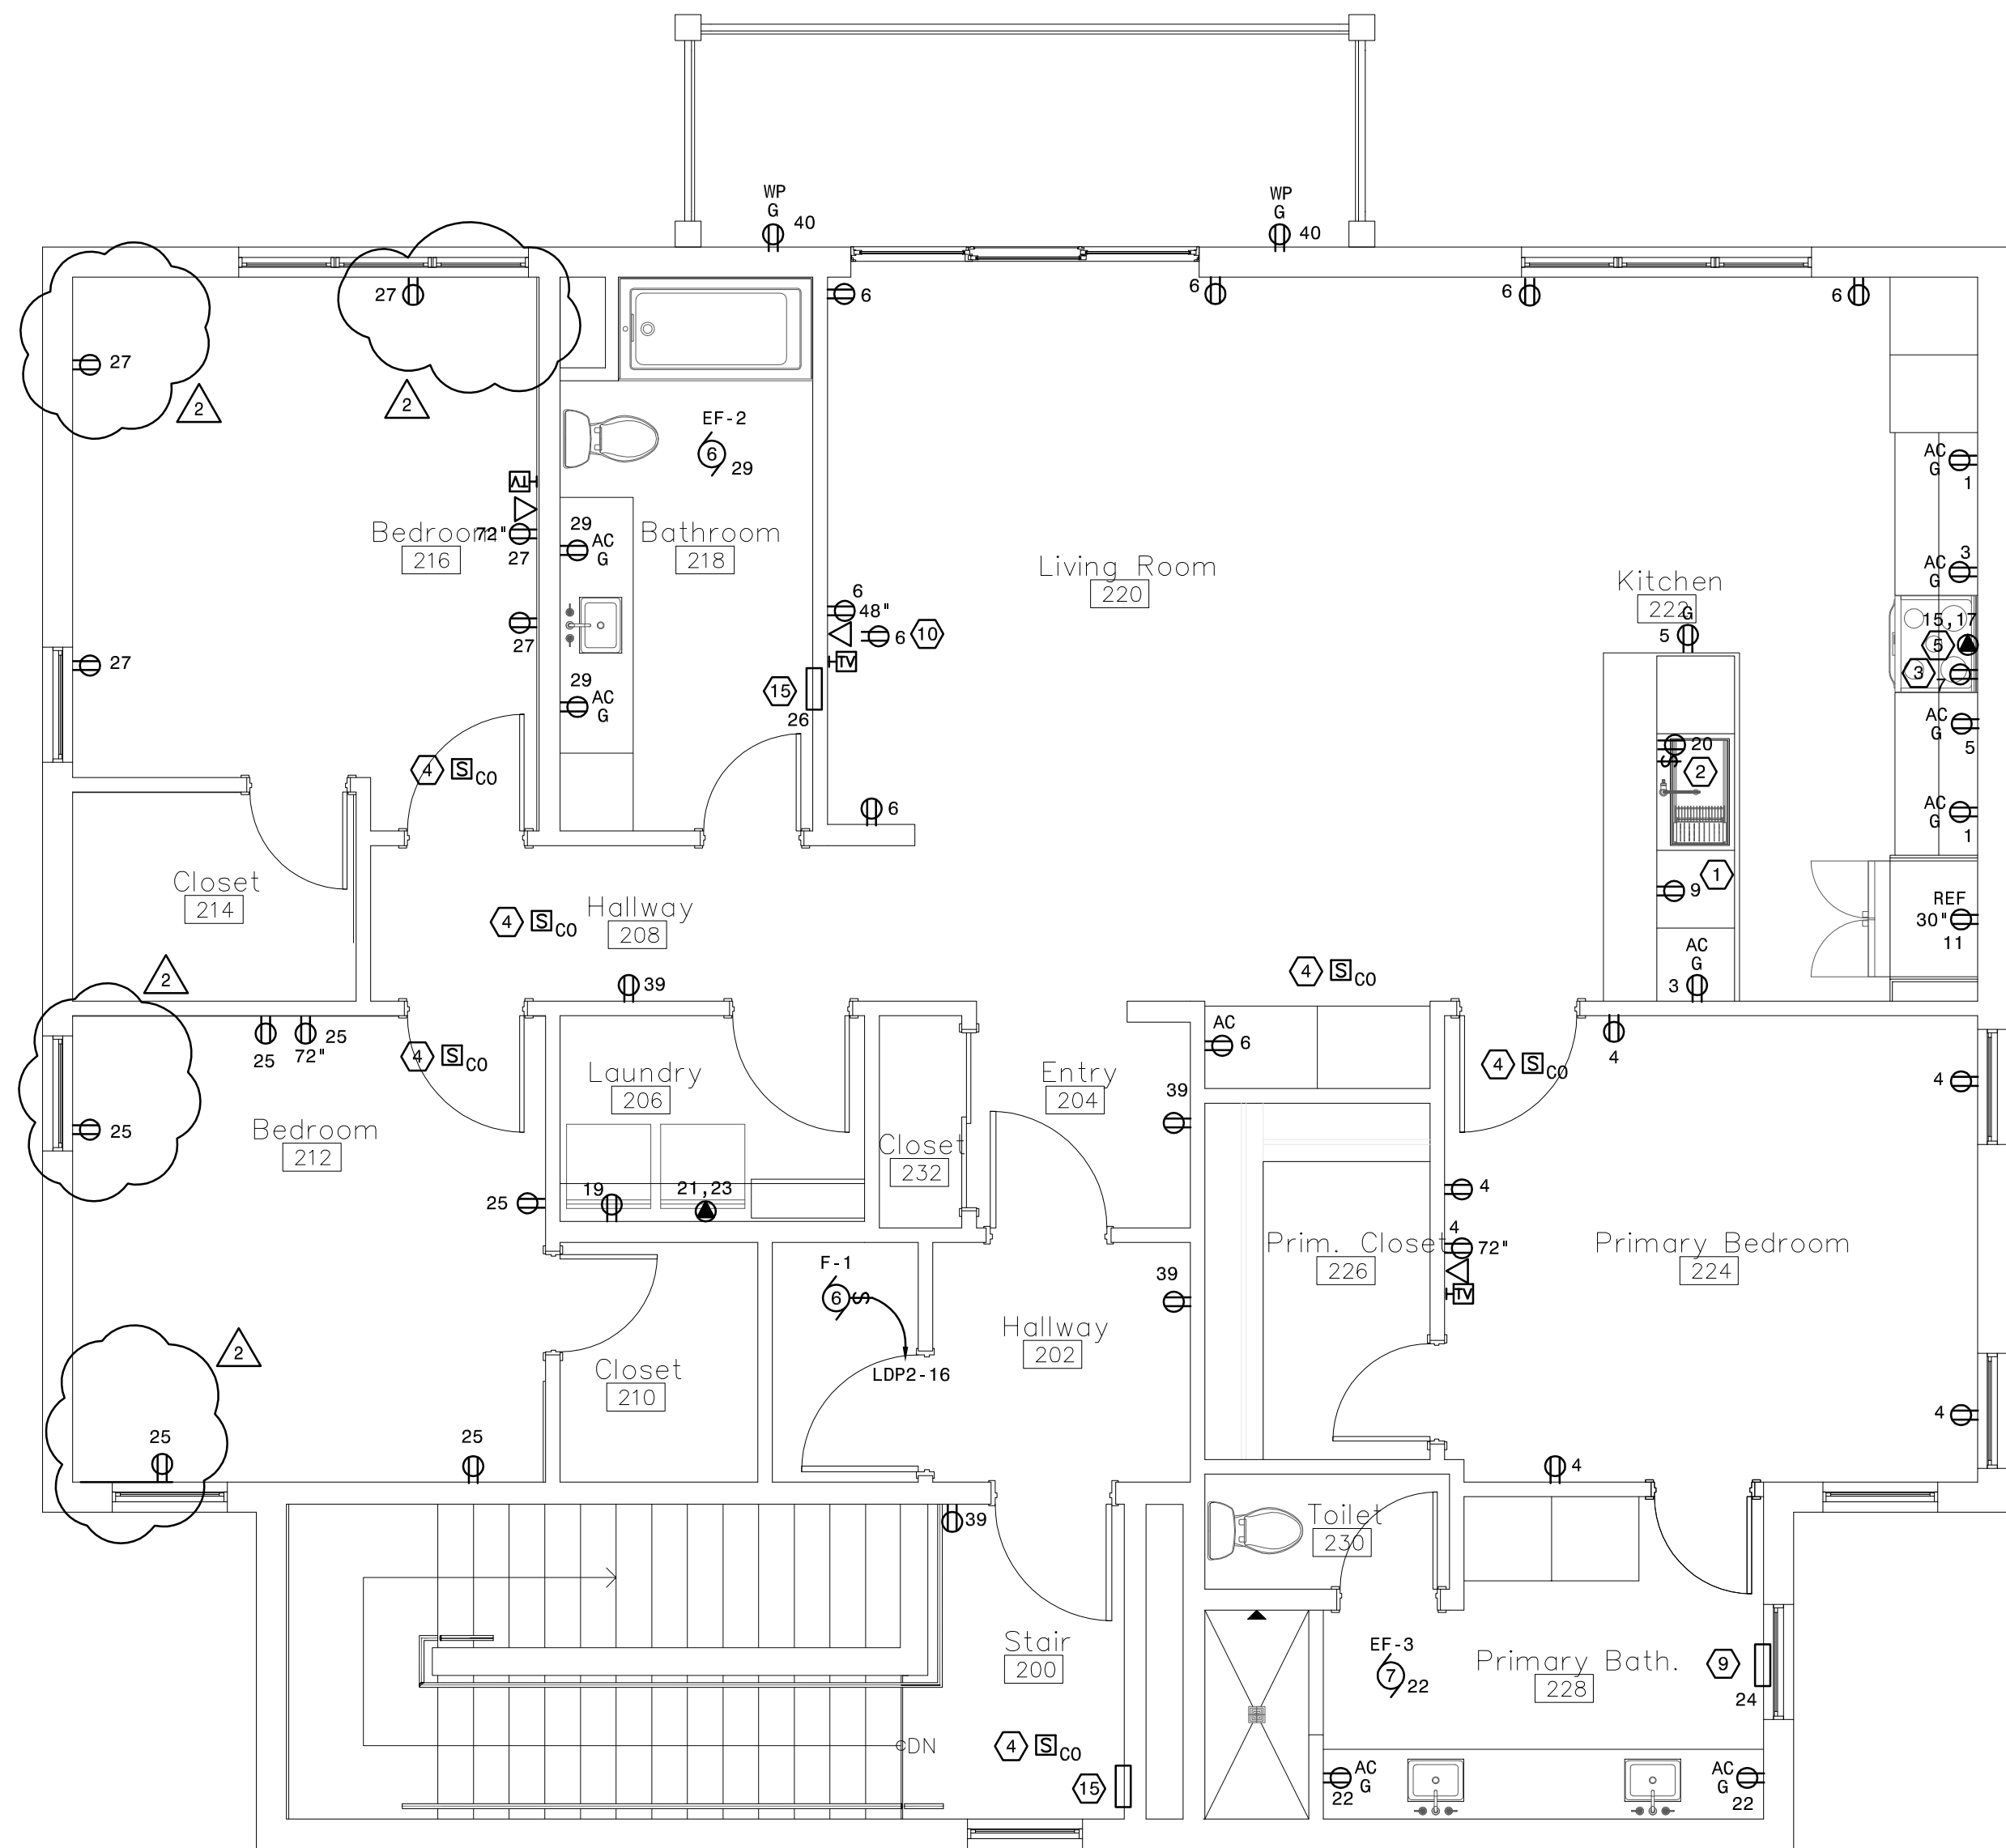

GENERAL NOTES:

1. PROVIDE TAMPER RESISTANT RECEPTACLES FOR ALL 120 VOLT RECEPTACLES SHOWN UNLESS OTHERWISE NOTED.
2. ALL RECEPTACLES DENOTED WITH 'U' SHALL BE DUPLEX WITH INTEGRAL USB EQUAL TO LEVITON T5632 SERIES.
3. WALL SWITCHES DESIGNATED AS D* SHALL BE PROVIDED WITH DIMMING CONTROLS FOR ZONE INDICATED.
4. ALL ADA UNITS SHALL BE PROVIDED WITH HEARING IMPAIRED NOTIFICATION DEVICES INCLUDING VISUAL DOORBELL AND F/A STROBES.

PLAN NOTES:

1. PROVIDE RECEPTACLE IN CABINET BELOW FOR DISHWASHER. CONNECT TO AFCI/GFCI DUAL RATED CIRCUIT BREAKER.
2. PROVIDE RECEPTACLE IN CABINET BELOW SINK FOR DISPOSAL. INSTALL WALL SWITCH OR AIR SWITCH FOR CONTROL, COORDINATE WITH ARCHITECTURAL FOR EXACT STYLE.
3. PROVIDE RECEPTACLE AT MICROWAVE SHELF. VERIFY HEIGHT AND LOCATION PRIOR TO ROUGH-IN.
4. PROVIDE 120 VOLT COMBINATION SMOKE DETECTOR WITH BATTERY BACKUP FOR ALL 120 VOLT DETECTORS. DETECTORS ARE TO BE WIRED TOGETHER SO WHEN ONE ALARMS ALL OF THE DETECTORS WITHIN THE UNIT ALARM. DETECTORS SHALL NOT ACTIVATE GENERAL BUILDING ALARM.
5. PROVIDE NEMA 14-50 RECEPTACLE FOR RANGE. PROVIDE #8 CONDUCTORS.
6. NOTE NOT USED.
7. VERIFY ORIENTATION OF WASHER AND DRYER AND INSTALL POWER CONNECTIONS ACCORDINGLY.
8. NOTE NOT USED.
9. PROVIDE FAN FORCED RECESSED WALL HEATER EQUAL TO BERKO SED SERIES. HEATER TO BE 120 VOLT, 1500 WATTS, INTEGRAL THERMOSTAT, POWER ON/OFF SWITCH, WHITE FINISH.
10. DEVICE (POWER/TELEVISION/DATA) TO BE MOUNTED AT 18 INCHES, CAT6 AND COAX TO BE COMBINED IN (1) SINGLE GANG BOX, PROVIDE BRUSHED NUD RING FOR CABLE ENTRY TO DEVICES ABOVE WHERE LOCATED BELOW RECESSED BOXES IN LIVING ROOM.
11. NOTE NOT USED.
12. NOTE NOT USED.
13. PROVIDE 120 VOLT CONNECTION TO EXHAUST FAN.
14. COORDINATE RECEPTACLE MOUNTING HEIGHT AND LOCATION FOR WALL AIR CONDITIONING UNIT WITH ARCHITECT PRIOR TO ROUGH-IN.
15. PROVIDE FAN FORCED RECESSED WALL HEATER EQUAL TO BERKO SED SERIES. HEATER TO BE 120 VOLT, 1000 WATTS, INTEGRAL THERMOSTAT, POWER ON/OFF SWITCH, WHITE FINISH. COORDINATE EXACT ROUGH IN LOCATION WITH ARCHITECT PRIOR TO INSTALLATION TO ENSURE NO CONFLICTS WITH OTHER WALL MOUNTED ACCESSORIES IN BATHROOMS.