

BID DATE / TIME= 09/03/2026 at 2:00 PM CST

LOCATION = Sports Book, Four Bears Casino, 202 Frontage Rd, New Town, ND 58763

THIS ADDENDUM SHALL BECOME A PART OF THE PLANS AND SPECIFICATIONS AND ITS RECEIPT SHALL BE NOTED ON THE BID FORM. (22 pages total)

GENERAL

1. Bid Date and Location has changed to 09/03/2026 at 2:00 PM CST at the Sports Book Room in the Four Bears Casino in New Town, ND 58763

SPECIFICATIONS:

1. 00 1110 – Advertisement for Bids
 - a. The bid date and location has been updated as attached.

CIVIL

No information to include within Addendum #01

STRUCTURAL

No information to include within Addendum #01

ARCHITECTURAL

SPECIFICATIONS:

1. 10 2800 – Toilet, Bath and Laundry Accessories
 - a. See attached updated section to indicate recessed changing station in lieu of surface mount.
2. See attached Substitution Requests

DRAWINGS:

1. G001 – General Notes / Drawing Index
 - a. See updated Drawing Index with S104 removed from the Index.
2. A601 – Door Schedule & Storefront Elevations
 - a. See updated Door Schedule with clouded corrections made.

FOODSERVICE

DRAWINGS:

1. The following sheets are attached with updated Names and Numbers
 - a. QF101– Foodservice Equipment Plan & Schedule
 - b. QF301– Foodservice Plumbing Rough-In Plan & Schedule
 - c. QF604– Foodservice Equipment Details – Walk-In
 - d. QF801– Foodservice Walk-In Details

MECHANICAL

DRAWINGS:

1. M200 – Plumbing Plans
 - a. Floor sink added beneath cook line.
 - b. Domestic water supply to mop sink cabinet drops down north kitchen wall in lieu of east wall.

ELECTRICAL

DRAWINGS:

2. E000 – Legends and Details
 - a. Updated Fixture Schedule to include additional manufacturer for most Types.
 - b. Added Type G1 fixture.
 - c. Revised Type T44 and T48 to single circuit track.

APPROVED EQUALS:

1. Contingent upon meeting all specifications, following items are acceptable for bidding:

Type:	Manufacturer:	Catalog Number:
B1 & B2	Metalux	CGTS Series
D1 & D2	Metalux	ASL4 Series

ATTACHMENTS:

1. 00 1110 – Advertisement for Bids
2. 10 2800 – Toilet, Bath and Laundry Accessories
3. Substitution Request -ACT 1 -USG
4. Substitution Request -ACT 2 -USG
5. Substitution Request -Electric Hand Dryers -Saniflow

New Town American Legion
Addendum #01
08/21/2026

6. Substitution Request -Changing Stations -BabyMedi
7. Substitution Request -Plastic Lockers -Scranton
8. G001 – Drawing Index
9. A601 – Door Schedule
10. QF101– Foodservice Equipment Plan & Schedule
11. QF301– Foodservice Plumbing Rough-In Plan & Schedule
12. QF604– Foodservice Equipment Details – Walk-In
13. QF801– Foodservice Walk-In Details
14. M200 – Plumbing Plans
15. E000 – Legends and Details

END OF ADDENDUM 01

Advertisement For Bids**American Legion Restaurant; New Town, ND**

Sealed Bids will be received for **New Town American Legion until 2:00 PM CT, Thursday September 3rd, 2026. Bids should be delivered to the Sports Book room in Four Bears Casino & Lodge; 202 Frontage Rd, New Town, ND 58763.** Bids will be publicly opened and read aloud shortly after 2 pm at the same location. Bids shall be bid as Combined Contract (all trades) OR Multiple Contract Project consisting of the following prime contracts: General Construction, Mechanical Construction and Electrical Construction.

The Project is a restaurant/bar which includes a 4,600 sf addition and interior demolition and remodel of a current 3,700 sf space, for a total of 8,300 sf.

Interested Bidders are invited to a Pre-Bid Walkthrough on August 26th 2:00 pm CT at American Legion, 352 Main St, New Town, ND 58763

Drawings and specifications prepared by ICON Architectural Group, and their consultants may be seen and examined at the Architect's office or on the North Dakota Builder's Exchanges at Bismarck, Dickinson, Fargo, Grand Forks, & Minot.

Bids not fully complying with the requirements of North Dakota Century Code Chapter 48-01.2 or the Instructions to Bidders will not be read or considered. Any deficient bid received will be resealed and returned to the Bidder immediately. The Owner reserves the right to reject any and all bids and to waive informalities and irregularities.

Each bid must be accompanied by separate envelope containing the Bidder's Contractor's license and bid security. The Bidder must be licensed for the full amount of the bid. Bid security in the form of a bidder's bond shall be submitted with each bid in the amount of 5 percent of the bid amount. No bids may be withdrawn for a period of 30 days after opening of bids.

All Prime contractors must contact ICON Architectural Group through Jesse Lawrence jessel@iconarchitects.com to be added to the Plan Holders list. Successful bidder shall begin the Work upon receipt of the Notice to Proceed and shall complete the Work within the Contract Time. Substantial Completion is October 1, 2027.

Bidders must be properly licensed under the laws governing their respective trades and be able to obtain insurance and bonds required for the Work. A Performance Bond, separate Labor and Material Payment Bond, and Insurance in a form acceptable to the Owner will be required of the successful Bidder.

Contractor Responsible for TERO Compliance.

END OF SECTION

SECTION 10 2800
TOILET, BATH, AND LAUNDRY ACCESSORIES

PART 1 GENERAL**1.01 SECTION INCLUDES**

- A. Commercial toilet accessories.
- B. Changing stations.
- C. Utility room accessories.

1.02 RELATED REQUIREMENTS

- A. Section 09 3000 - Tiling: Ceramic washroom accessories.
- B. Section 10 2113.19 - Plastic Toilet Compartments.
- C. Division 22 - Plumbing Fixtures.

1.03 ABBREVIATIONS AND ACRONYMS

- A. PETG: Polyethylene Terephthalate Glycol.

1.04 REFERENCE STANDARDS

- A. ADA Standards - 2010 ADA Standards for Accessible Design; 2010.
- B. ASME A112.18.9 - Protectors/Insulators for Exposed Waste and Supplies on Accessible Fixtures; 2011 (Reaffirmed 2022).
- C. ASTM A123/A123M - Standard Specification for Zinc (Hot-Dip Galvanized) Coatings on Iron and Steel Products; 2024.
- D. ASTM A269/A269M - Standard Specification for Seamless and Welded Austenitic Stainless Steel Tubing for General Service; 2025.
- E. ASTM A480/A480M - Standard Specification for General Requirements for Flat-Rolled Stainless and Heat-Resisting Steel Plate, Sheet, and Strip; 2025b.
- F. ASTM A653/A653M - Standard Specification for Steel Sheet, Zinc-Coated (Galvanized) or Zinc-Iron Alloy-Coated (Galvannealed) by the Hot-Dip Process; 2025a.
- G. ASTM A666/A666M - Standard Specification for Annealed or Cold-Worked Austenitic Stainless Steel Sheet, Strip, Plate, and Flat Bar; 2024.
- H. ASTM B86 - Standard Specification for Zinc and Zinc-Aluminum (ZA) Alloy Foundry and Die Castings; 2023.
- I. ASTM B456 - Standard Specification for Electrodeposited Coatings of Copper Plus Nickel Plus Chromium and Nickel Plus Chromium; 2017 (Reapproved 2022).
- J. ASTM C1036 - Standard Specification for Flat Glass; 2025.
- K. ASTM C1048 - Standard Specification for Heat-Strengthened and Fully Tempered Flat Glass; 2025.
- L. ASTM C1503 - Standard Specification for Silvered Flat Glass Mirror; 2024.
- M. ASTM D4802 - Standard Specification for Poly(Methyl Methacrylate) Acrylic Plastic Sheet; 2016 (Reapproved 2024).
- N. ASTM E84 - Standard Test Method for Surface Burning Characteristics of Building Materials; 2026a.
- O. ASTM F2285 - Standard Consumer Safety Performance Specification for Diaper Changing Tables for Commercial Use; 2022.

- P. ICC A117.1 - Accessible and Usable Buildings and Facilities; 2017.

1.05 ADMINISTRATIVE REQUIREMENTS

- A. Coordinate the work with the placement of internal wall reinforcement, concealed ceiling supports, and reinforcement of toilet partitions to receive anchor attachments.
- B. Coordinate accessory locations with other work to prevent interference with clearances required for access by people with disabilities, and for proper installation, adjustment, operation, cleaning, and servicing of accessories.
- C. Deliver inserts and anchoring devices set into concrete or masonry as required to prevent delaying the Work.
- D. Coordinate accessories with electrical engineer as needed.

1.06 SUBMITTALS

- A. See Section 01 3000 - Administrative Requirements, for submittal procedures.
- B. Product Data: For each type of product.
 - 1. Include construction details, material descriptions, dimensions of individual components and profiles, and finishes.
 - 2. Include anchoring and mounting requirements, including requirements for cutouts in other work and substrate preparation.
- C. Samples: Submit one full-sized sample(s) of each accessory, illustrating color and finish, upon request.
- D. Manufacturer's Installation Instructions: Indicate special procedures and conditions requiring special attention.

PART 2 PRODUCTS

2.01 MATERIALS

- A. Accessories - General: Shop assembled, free of dents and scratches and packaged complete with anchors and fittings, steel anchor plates, adapters, and anchor components for installation.
- B. Keys: Provide 2 keys for each applicable accessory to Owner; master key lockable accessories.
- C. Fasteners, Screws, and Bolts: Hot dip galvanized; tamper-proof; security type.

2.02 FINISHES

- A. Stainless Steel: Satin finish, unless otherwise noted.
- B. Back paint components where contact is made with building finishes to prevent electrolysis.

2.03 COMMERCIAL TOILET ACCESSORIES

- A. Toilet Paper Dispenser (TPD) : Owner-furnished, Vendor-installed.
- B. Paper Towel Dispenser (PTD) : Owner-furnished, Vendor-installed.
- C. Soap Dispenser (SD): Owner-furnished, Vendor-installed.
- D. Mirrors (MIR): Stainless steel framed, 1/4 inch thick annealed float glass; ASTM C1036.
 - 1. Annealed Float Glass: Silvering, protective and physical characteristics in compliance with ASTM C1503.
 - 2. Size: As indicated on Drawings.
 - 3. Frame: 0.05 inch angle shapes, with mitered , welded and ground corners, and tamperproof hanging system; satin finish.
 - 4. Backing: Full-mirror sized, minimum 0.03 inch galvanized steel sheet and nonabsorptive filler material.

5. Products:
 - a. Bradley Corporation; 7B1: www.bradleycorp.com/
 - b. Substitutions: Section 01 6000 - Product Requirements.
- E. Grab Bars (GB): Stainless steel, peened surface.
 1. Standard Duty Grab Bars:
 - a. Push and Pull Point Load: Minimum 250 lbf.
 - b. Dimensions: 1-1/2 inch outside diameter, concealed flange mounting, 1-1/2 inch clearance between wall and inside of grab bar.
 - c. Finish: Smooth, ASTM A480/A480M No. 4 finish Satin on ends and slip-resistant texture in grip area.
 - d. Length and Configuration: As indicated on Drawings.
 - e. Frame: Stainless steel channel with concealed mounting.
 - f. Products:
 - 1) Bradley Corporation.; Model 812 : www.bradleycorp.com/
 - 2) Substitutions: Section 01 6000 - Product Requirements.
- F. Sanitary Napkin Disposal Unit (SND): Owner-furnished, Vendor-installed.
- G. Hook: Heavy-duty stainless steel, double-prong, rectangular-shaped bracket and backplate for concealed attachment, satin finish.
 1. Products:
 - a. Bradley Corporation.; Model 9124: www.bradleycorp.com/
 - b. Substitutions: Section 01 6000-Product Requirements.

2.04 CHANGING STATIONS

- A. Baby Changing Station(BCS) : Wall-mounted folding diaper changing station for use in commercial toilet facilities, meeting or exceeding ASTM F2285.
 1. Material: ~~Stainless steel.~~
 2. Mounting: ~~Recessed~~; horizontal.
 3. Color: ~~Selected by Architect~~ from full range..
 4. Minimum Rated Load: 250 pounds.
 5. Products:
 - a. Koala Kare; Model ~~KB310-SSRE~~ : <https://www.koalabear.com/>
 - b. Substitutions: ~~01 6000 - Product Requirements.~~

2.05 UTILITY ROOM ACCESSORIES

- A. Combination Utility Shelf/Mop and Broom Holder: 0.05 inch thick stainless steel, Type 304, with 1/2 inch returned edges, 0.06 inch steel wall brackets.
 1. Drying rod: Stainless steel, 1/4 inch diameter.
 2. Hooks: Two, 0.06 inch stainless steel rag hooks at shelf front.
 3. Mop/broom holders: Three spring-loaded rubber cam holders at shelf front.
 4. Length: 30 inches.
 5. Products:
 - a. American Specialties, Inc; 1315-3: www.americanspecialties.com/#sle.
 - b. Substitutions: 01 6000 - Product Requirements.

PART 3 EXECUTION

3.01 EXAMINATION

- A. Verify existing conditions before starting work.
- B. Verify exact location of accessories for installation.

- C. Verify that field measurements are as indicated on drawings.

3.02 PREPARATION

- A. Deliver inserts and rough-in frames to site for timely installation.

3.03 INSTALLATION

- A. Install accessories in accordance with manufacturers' written instructions in locations indicated on drawings, using fasteners appropriate to substrate indicated and recommended by unit manufacturer.
- B. Install plumb and level, securely and rigidly anchored to substrate in locations and at heights indicated.
- C. Mounting Heights: As required by accessibility regulations, unless otherwise indicated.

3.04 PROTECTION, ADJUST

- A. Protect installed accessories from damage due to subsequent construction operations.
- B. Adjust accessories for unencumbered, smooth operation. Replace damaged or defective items.
- C. Remove temporary labels and protective coatings.
- D. Clean and polish exposed surfaces in accordance with manufacturer's written instructions.

END OF SECTION 10 2800

CSI Form 1.5C

SUBSTITUTION REQUEST

(During the Bid Period)

Project: American Legion - New Town Substitution Request Number: 1
 From: Golden Valley Supply
 To: ICON Architects Date: 8/19/26
 A/E Project Number: 23-108
 Re: Jesse Lawrence Contract For: _____
 Specification Title: Acoustical Ceilings Description: Armstrong Calla - 2x2, 15/16" tegular
 Section: 095100 Page: A610 Article/Paragraph: ACT-1

Proposed Substitution: USG Mars High-NRC #88135
 Manufacturer: _____ Address: _____ Phone: _____
 Trade Name: _____ Model No.: _____

Attached data includes product description, specifications, drawings, photographs, and performance and test data adequate for evaluation of the request; applicable portions of the data are clearly identified.

Attached data also includes a description of changes to the Contract Documents that the proposed substitution will require for its proper installation.

The Undersigned certifies:

- Proposed substitution has been fully investigated and determined to be equal or superior in all respects to specified product.
- Same warranty will be furnished for proposed substitution as for specified product.
- Same maintenance service and source of replacement parts, as applicable, is available.
- Proposed substitution will have no adverse effect on other trades and will not affect or delay progress schedule.
- Proposed substitution does not affect dimensions and functional clearances.
- Payment will be made for changes to building design, including A/E design, detailing, and construction costs caused by the substitution.

Submitted by: Tara Garbe
 Signed by: Tara Garbe
 Firm: Golden Valley Supply
 Address: 1000 Zane Ave N
Minneapolis, MN 55422
 Telephone: 763-544-8907

A/E's REVIEW AND ACTION

- ☒ Substitution approved - Make submittals in accordance with Specification Section 01 25 00 Substitution Procedures.
☐ Substitution approved as noted - Make submittals in accordance with Specification Section 01 25 00 Substitution Procedures.
☐ Substitution rejected - Use specified materials.
☐ Substitution Request received too late - Use specified materials.

Signed by: J. H. Date: 8-19-26

Supporting Data Attached: ☐ Drawings ☒ Product Data ☐ Samples ☐ Tests ☐ Reports ☐ _____

CSI Form 1.5C

SUBSTITUTION REQUEST (During the Bid Period)

Project: American Legion - New Town Substitution Request Number: 2
 To: ICON Architects From: Golden Valley Supply
 Re: Jesse Lawrence Date: 8/19/26
 A/E Project Number: 23-108
 Contract For: _____
 Specification Title: Acoustical Ceilings Description: Armstrong Kitchen Zone - 2x2
 Section: 095100 Page: A610 Article/Paragraph: ACT-2

Proposed Substitution: USG Kitchen Lay-In #3210
 Manufacturer: _____ Address: _____ Phone: _____
 Trade Name: _____ Model No.: _____

Attached data includes product description, specifications, drawings, photographs, and performance and test data adequate for evaluation of the request; applicable portions of the data are clearly identified.

Attached data also includes a description of changes to the Contract Documents that the proposed substitution will require for its proper installation.

The Undersigned certifies:

- Proposed substitution has been fully investigated and determined to be equal or superior in all respects to specified product.
- Same warranty will be furnished for proposed substitution as for specified product.
- Same maintenance service and source of replacement parts, as applicable, is available.
- Proposed substitution will have no adverse effect on other trades and will not affect or delay progress schedule.
- Proposed substitution does not affect dimensions and functional clearances.
- Payment will be made for changes to building design, including A/E design, detailing, and construction costs caused by the substitution.

Submitted by: Tara Garbe
 Signed by: Tara Garbe
 Firm: Golden Valley Supply
 Address: 1000 Zane Ave N
Minneapolis, MN 55422
 Telephone: 763-544-8907

A/E's REVIEW AND ACTION

- ☒ Substitution approved - Make submittals in accordance with Specification Section 01 25 00 Substitution Procedures.
☐ Substitution approved as noted - Make submittals in accordance with Specification Section 01 25 00 Substitution Procedures.
☐ Substitution rejected - Use specified materials.
☐ Substitution Request received too late - Use specified materials.

Signed by: [Signature] Date: 8-19-26

Supporting Data Attached: ☐ Drawings ☒ Product Data ☐ Samples ☐ Tests ☐ Reports ☐ _____



SUBSTITUTION REQUEST

(During the Bidding/Negotiating Stage)

Project: American Legion Restaurant

Substitution Request Number: _____

352 Main St, New Town, ND, 58763 (Mountrail
County)

From: Saniflow Corp. / Attn: Tyler Rose

Date: 8/20/2026

To: ICON Architectural Group

A/E Project Number: 23-018

Re: Substitution/ Equal

Specification: TOILET, BATH, AND LAUNDRY ACCESSORIES

Description: ELECTRIC HAND DRYER

Section: 102814

Page: 2

Article/Paragraph: 2.02

Proposed Substitution :Speedflow Plus

Manufacturer: Saniflow Corp. Address:3325 NW 70th Ave., Miami FL, 33122 Phone: Trade 305-424-2433

Name: Saniflow, a Mediclinics Company Model No.: M17A-UL

Attached data includes product description, specifications, drawings, photographs, and performance and test data adequate for evaluation of the request; applicable portions of the data are clearly identified.

Attached data also includes a description of changes to the Contract Documents that the proposed substitution will require for its proper installation.

The Undersigned certifies:

- Proposed substitution has been fully investigated and determined to be equal or superior in all respects to specified product.
- Same warranty will be furnished for proposed substitution as for specified product.
- Same maintenance service and source of replacement parts, as applicable, is available.
- Proposed substitution will have no adverse effect on other trades and will not affect or delay progress schedule.
- Proposed substitution does not affect dimensions and functional clearances.
- Payment will be made for changes to building design, including A/E design, detailing, and construction costs caused by the substitution.

Submitted by: Tyler Rose

Signed by: Tyler Rose

Firm: Saniflow Corp

Address: 3325 NW 70th Ave, Miami, FL, 3312

Telephone: 305-424-2433 x. 2021

A/E's REVIEW AND ACTION

- ☒ Substitution approved - Make submittal in accordance with Specification Section 01 25 00 Substitution Procedures.
- ☐ Substitution approved as noted - Make submittal in accordance with Specification Section 01 25 00 Substitution Procedures.
- ☐ Substitution rejected - Use specified materials.
- ☐ Substitution Request received too late - Use specified materials.

Signed by: _____

Date: 8-21-26

Supporting Data Attached: ☐ Drawings ☒ Product Data ☐ Samples ☐ Tests ☒ Reports ☐ _____



SUBSTITUTION REQUEST

(During the Bidding/Negotiating Stage)

Project: American Legion Restaurant

Substitution Request Number:

From: Saniflow Corp. / Attn: Tyler Rose

352 Main St, New Town, ND, 58763 (Mountrail
County)

Date: 8/20/2026

To: ICON Architectural Group

A/E Project Number: 23-018

Re: Substitution/ Equal

Contract

Specification: TOILET, BATH, AND LAUNDRY ACCESSORIES

Description: Baby Changing Station

Section: 102800

Page: 3

Paragraph: 2.4

*Include Recess
K14*

Proposed Substitution: Babymedi (recessed)
Manufacturer: Saniflow Corp. Address: 3325 NW 70th Ave., Miami FL, 33122 Phone: 305-424-2433
Trade Name: Saniflow, a Mediclinics Company Model No.: CP0016HCS-ASTM

Attached data includes product description, specifications, drawings, photographs, and performance and test data adequate for evaluation of the request; applicable portions of the data are clearly identified.

Attached data also includes a description of changes to the Contract Documents that the proposed substitution will require for its proper installation.

The Undersigned certifies:

- Proposed substitution has been fully investigated and determined to be equal or superior in all respects to specified product.
- Same warranty will be furnished for proposed substitution as for specified product.
- Same maintenance service and source of replacement parts, as applicable, is available.
- Proposed substitution will have no adverse effect on other trades and will not affect or delay progress schedule.
- Proposed substitution does not affect dimensions and functional clearances.
- Payment will be made for changes to building design, including A/E design, detailing, and construction costs caused by the substitution.

Submitted by: Tyler Rose

Signed by: Tyler Rose

Firm: Saniflow Corp

Address: 3325 NW 70th Ave, Miami, FL, 33122

Telephone: 305-424-2433 x. 2003

A/E's REVIEW AND ACTION

- ☐ Substitution approved - Make submittal in accordance with Specification Section 01 25 00 Substitution Procedures.
- ☒ Substitution approved as noted - Make submittal in accordance with Specification Section 01 25 00 Substitution Procedures.
- ☐ Substitution rejected - Use specified materials.
- ☐ Substitution Request received too late - Use specified materials.

Signed by: [Signature]

Date: 8-21-26

Supporting Data Attached: ☐ Drawings ☒ Product Data ☐ Samples ☐ Tests ☒ Reports ☐

SUBSTITUTION REQUEST
(During the Bidding/Negotiating Stage)

Project: <u>American Legion Restaurant</u>	Substitution Request Number: <u>Spec-0011916</u>
<u>NEW TOWN, ND</u>	From: <u>Courtney Smith, Scranton Products</u>
To: <u>Jesse Lawrence, Icon Architects (Watford City, ND)</u>	Date: <u>08/20/2026</u>
<u>jessel@iconarchitects.com, (701) 772-4266</u>	A/E Project Number: _____
Re: <u>PLASTIC LOCKERS</u>	Contract For: <u>American Legion Post 290</u>

Specification Title: <u>PLASTIC LOCKERS</u>	Description: <u>Manufacturers</u>
Section: <u>105126</u> Page: <u>1</u>	Article/Paragraph: <u>2.01</u>

Proposed Substitution: Duralife Lockers

Manufacturer: <u>Scranton Products</u>	Address: <u>801 E Corey St. #3523 Scranton, PA 18505</u>	Phone: <u>(704) 426-3354</u>
Trade Name: <u>Duralife Lockers</u>	Model No. : <u>N/A</u>	

Attached data includes product description, specifications, drawings, photographs, and performance and test data adequate for evaluation of the request; applicable portions of the data are clearly identified.

Attached data also includes a description of changes to the Contract Documents that the proposed substitution will require for its proper installation.

The Undersigned certifies:

- Proposed substitution has been fully investigated and determined to be equal or superior in all respects to specified product.
- Same warranty will be furnished for proposed substitution as for specified product.
- Same maintenance service and source of replacement parts, as applicable, is available.
- Proposed substitution will have no adverse effect on other trades and will not affect or delay progress schedule.
- Proposed substitution does not affect dimensions and functional clearances.

Submitted by: Courtney Smith

Signed by: Courtney Smith

 
Firm: Scranton Products

Address: 801 E Corey St
Scranton, Pennsylvania 18505

Telephone: (570) 348-0997, csmith@scrantonproducts.com

A/E' s REVIEW AND ACTION

- ☒ Substitution approved - Make submittals in accordance with Specification Substitution Procedures.
- ☐ Substitution approved as noted - Make submittals in accordance with Specification Substitution Procedures.
- ☐ Substitution rejected - Use specified materials.
- ☐ Substitution Request received too late - Use specified materials.

Signed by:  8-20-26 Date:

Supporting Data Attached: ☐ Drawings ☐ Product Data ☐ Samples ☐ Tests ☐ Reports ☐

G001 - LIST OF ABBREVIATIONS

LIST OF ABBREVIATIONS DESCRIPTION	
ACM - ASBESTOS CONTAINING MATERIAL	
ACT - ACOUSTICAL CEILING TILE	
ADA - AMERICANS W/IDISABILITIES ACT	
AFF - ABOVE FINISH FLOOR	
AHU - AIR HANDLING UNIT	
ALT - ALTERNATE	
AC - ALTERNATING CURRENT	
ALUM - ALUMINUM	
ACI - AMERICAN CONCRETE INSTITUTE	
AISC - AMERICAN INSTITUTE OF STEEL CONSTRUCTION	
ANSI - AMERICAN NATIONAL STANDARDS INSTITUTE	
ASHRAE - AMERICAN SOCIETY OF HEATING REF. AND AIR CONDITIONING ENGINEERS	
ARCH - ARCHITECT	
A/E - ARCHITECT/ENGINEER	
ASI - ARCHITECTURAL SUPPLEMENTAL INSTRUCTION	
AWI - AMERICAN WOODWORKING INSTITUTE	
BM - BEAM	
BRG - BEARING	
BD - BOARD	
BOT - BOTTOM	
BTU - BRITISH THERMAL UNITS	
BLDG - BUILDING	
BUR - BUILT UP ROOFING	
CAB - CABINET	
CB - CATCH BASIN	
CPT - CARPET	
CSMT - CASEMENT	
CSWK - CASEWORK	
CIP - CAST IN PLACE	
CI - CAST IRON	
CLG - CEILING	
CT - CERAMIC TILE	
CO - CLEAN OUT	
CLR - CLEAR	
CONC - CONCRETE	
CMU - CONCRETE MASONRY UNIT	
CJ - CONTROL JOINT	
CG - CORNER GUARD	
CUH - CABINET UNIT HEATER	
DEMO - DEMOLITION	
DEPT - DEPARTMENT	
DTL - DETAIL	
DIAG - DIAGONAL	
DIA - DIAMETER	
DIM - DIMENSION	
DW - DISHWASHER	
DIST - DISTANCE	
DOC - DOCUMENT	
DR - DOOR	
DWG - DRAWING	
DF - DRINKING FOUNTAIN	
EA - EACH	
ELEC - ELECTRIC	
ELEV - ELEVATOR/ELEVATION	
EWV - ELECTRIC WATER COOLER	
EQ - EQUAL	
EQUIP - EQUIPMENT	
EXIST - EXISTING	
EP - EPOXY PAINT	
EJ - EXPANSION JOINT	
EIFS - EXTERIOR INSULATION FINISH SYSTEM	
FIN - FINISH	
FLR - FLOOR	
FEC - FIRE EXTINGUISHER CABINET	
FHC - FIRE HOSE CABINET	
FD - FLOOR DRAIN	
FTG - FOOTING	
FF - FINISH FLOOR	
FFE - FURNITURE, FIXTURE, AND EQUIPMENT	
FND - FOUNDATION	
FWC - FABRIC WALL COVERING	
GC - GENERAL CONTRACTOR	
GALV - GALVANIZED	
GEN - GENERAL	
GL - GLASS/ GLAZING	
GWB - GYPSUM WALL BOARD	
HCP - HANDICAP	
HDW - HARDWARE	
HDWD - HARDWOOD	
HM - HOLLOW METAL	
HORZ - HORIZONTAL	
HT - HEIGHT	
HB - HOSE BIB	
INSUL - INSULATION	
IBC - INTERNATIONAL BUILDING CODE	
JAN - JANITOR	
LAM - LAMINATE	
LAV - LAVATORY	
MAS - MASONRY	
MB - MARKER BOARD	
MDF - MEDIUM DENSITY FIBERBOARD	
ML - MATCHLINE	
MTL STD - METAL STUD	
MTL - METAL	
MH - MANHOLE	
MECH - MECHANICAL	
NIC - NOT IN CONTRACT	

G001 - LIST OF ABBREVIATIONS

LIST OF ABBREVIATIONS DESCRIPTION	
NC - NON COMBUSTIBLE	
NOM - NOMINAL	
NTS - NOT TO SCALE	
OH - OVERHEAD	
OC - ON CENTER	
OFCI - OWNER FURNISHED CONTRACTOR INSTALLED	
OFOI - OWNER FURNISHED OWNER INSTALLED	
OSB - ORIENTED STRAND BOARD	
PT - PAINT	
PB - PARTICLE BOARD	
PC - PRECAST	
PLYWD - PLYWOOD	
PLAM - PLASTIC LAMINATE	
PLAST - PLASTER	
PTD - PAPER TOWEL DISPENSER	
PREV - PREVIOUS	
REINF - REINFORCEMENT	
REQD - REQUIRED	
REV - REVERSE	
RM - ROOM	
RO - ROUGH OPENING	
RAD - RADIUS	
RTU - ROOF TOP UNIT	
SD - SOAP DISPENSER	
SIM - SIMILAR	
SHT - SHEET	
SPEC - SPECIFICATIONS	
SECT - SECTION	
SD - SMOKE DETECTOR	
SQ - SQUARE	
SUSP - SUSPEND	
TC - THIN COAT	
TPD - TOILET PAPER DISPENSER	
TP - TOILET PARTITION	
TRTD - TREATED	
TS - TRANSITION STRIP	
TYP - TYPICAL	
TEMP - TEMPORARY/TEMPERATURE	
TO - TOP OF	
UL - UNDERWRITERS LABORATORIES	
UNO - UNLESS NOTED OTHERWISE	
VCT - VINYL COMPOSITION TILE	
WDW - WINDOW	
W - WITH	
WD - WOOD	
CPT-T - CARPET TILE	
QT - QUARRY TILE	
VB - VINYL BASE	
VWC - VINYL WALL COVERING	
SV - SHEET VINYL	
OTS - OPEN TO STRUCTURE	
CBB - CEMENT BACKER BOARD	
MIR - MIRROR	
BO - BY OWNER	
BRK - BRICK	
CMU-G - CONCRETE MASONRY UNIT (GLAZED)	
CMU-S - CONCRETE MASONRY UNIT (STANDARD 8"x8" SCORED)	
CMU-B - CONCRETE MASONRY UNIT (BURNISHED)	
CONC-S - SEALED CONCRETE	
PRF - PREFINISHED	
CS - CAST STONE	
EXP - EXPOSED	
FRP - FIBERGLASS REINFORCED PANEL	
PT-E - PAINT- EPOXY	
LVT - LUXURY VINYL TILE	
FRT - FRY REGLET REVEAL TRIM	
SDT - STATIC DISSIPATIVE TILE	
RSTR - RUBBER STAIR TREADS -RISERS	
SC - SPECIAL COATING-SEE SPECS	
OWB - OPERABLE WALL PANEL	
RB - RUBBER BASE	
WOM - WALK-OFF MAT	
SLT - SLATE	
SS - SOLID SURFACE	
ST - STONE	
SWU - SOUND-ABSORBING WALL UNIT	
STN - STAIN	
VP - VINYL PLANK FLOORING	
VT - VINYL TILE FLOORING	
WRS - WINDOW ROLLER SHADES	
CPT-AS - CARPET -ANT-STATIC	
CPT-ESD - CARPET -ELECTROSTATIC DISCHARGE	
MTLP - METAL PROFILE TRIM	
PWP - PREFINISHED WALL PANEL	
CTR - COUNTER	
TBWP - TRAFFIC BEARING WATER PROOFING	
RAF - RESILIENT RUBBER FLOORING	
GB - GRAB BAR	
EHD - ELECTRIC HAND DRYER	
WR - WASTE RECEPTACLE	
SND - SANITARY NAPKIN DISPOSAL	
SCD - SEAT COVER DISPENSER	
SNV - SANITARY NAPKIN VENDING MACHINE	
MBH - MOP/ BROOM HOLDER	
RH - ROBE HOOK	
BCS - BABY CHANGING STATION	
SCR - SHOWER CURTAIN ROD	
LVR - LOUVER	

G001 - GENERAL NOTES

- PROJECT GENERAL NOTES DESCRIPTION
- SEE SPECIFICATION DIVISION 00 AND 01 FOR GENERAL NOTES
 - VERIFY ALL PENETRATIONS THRU FOUNDATION W/APPROPRIATE TRADES.
 - CONTRACTOR SHALL VERIFY AND PROVIDE ANY ROUGH-IN CONSTRUCTION REQUIRED FOR OWNER-INSTALLED EQUIPMENT CALLED OUT IN DRAWINGS OR SPECIFICATIONS UNLESS OTHERWISE NOTED
 - ALL DIRECTIONAL REFERENCES IN DRAWINGS SHALL REFER TO PLAN NORTH.
 - ALL JOINTS & PENETRATIONS SHALL BE FIRE SAFED & FIRE SEALED AS REQUIRED TO COMPLY WITH APPLICABLE BUILDING CODES
 - KEYNOTES ARE USED TO ASSIST IN NOTING AND INDICATE REPETITIVE INSTANCES.
 - SUSPENDED CEILING HEIGHTS ARE DIMENSIONED FROM FINISHED FLOOR.

SYMBOLS LEGEND

	CENTER LINE		MATCHLINE REFERENCE		NORTH NORTH ARROW W/ TRUE NORTH
	DOOR TAG				
	KEYNOTE TAG		DEMO TAG / INTERIOR SIGNAGE		
	EXTERIOR MATERIAL TAG		View Name		DETAIL CALLOUT
	WALL TAG				WALL SECTION
	WINDOW TAG				BUILDING SECTION
	SPOT ELEVATION TAG		FLOORING TRANSITION		ACCENT WALL FINISH LOCATION
	LEVEL HEAD		CEILING TAG W/ FINISH OR ASSEMBLY INFO		
	HORIZONTAL ASSEMBLY TAG				
	REVISION TAG				
	ROOM TAG				
	ROOM TAG w/ AREA				
	ROOM TAG w/ AREA & OCCUPANT LOAD				
	ROOM TAG w/ ROOM FINISH INFO AT PLANS (NOT ALL MAY BE SHOWN)				
	ROOM TAG w/ CEILING FINISH INFO ONLY AT RCPs				

MATERIAL LEGEND

	ALUMINUM		RIGID INSULATION
	CONCRETE		SAND
	EARTH		SAND - DENSE
	GRAVEL		STEEL
	GYPSUM		WOOD - FINISHED CARPENTRY
	MASONRY - BRICK		WOOD - ROUGH CARPENTRY
	MASONRY - CMU		WOOD - PLYWOOD

DRAWING INDEX

SHEET #	SHEET NAME
GENERAL	
G001	General Notes / Drawing Index
G002	Code Study
G004	ANSI 117.1 - 2017 Standards
CIVIL	
C-001	Civil Legend & Notes
C-002	Civil Notes
C-003	Civil Notes
C-201	Civil Details
C-601	Existing Conditions & Removals Plan
C-602	Site & Utility Plan
C-603	Grading & Erosion Control Plan
STRUCTURAL	
S001	Structural Notes
S002	Structural Notes
S003	Special Inspections & Testing
S101	Foundation Plan
S102	Roof Framing Plan
S301	Foundation Details
S302	Standard Foundation Details
S303	Foundation Details
S601	Framing Details
S602	Framing Details
S603	Framing Details
S604	Cold-Formed Framing Standards
ARCHITECTURAL DEMOLITION	
AD101	Demolition Plans & Elevations
ARCHITECTURAL	
A001	Architectural Site Plan
A002	Architectural Site Details
A092	Wall & Horizontal Assemblies
A101	First Floor Plan
A105	Roof Plan
A111	First Floor Reflected Ceiling Plan
A201	Exterior Elevations
A301	Building Sections
A311	Wall Sections
A312	Wall Sections
A321	Circulation Sections & Enlarged Plans
A401	Enlarged Plans & Interior Elevations
A411	Interior Elevations
A412	Interior Elevations
A421	Interior Details / Casework Sections
A520	Head, Jamb, & Sill Details
A530	Wall Base, Elevated Floor Line, Parapet Details
A601	Door Schedule & Storefront Elevations
A610	Finish Schedule
A701	Finish Plan
A801	Furniture & Signage Plan
FOODSERVICE	
QF001	Foodservice Equipment Title Sheet
QF101	Foodservice Equipment Plan & Schedule
QF201	Foodservice Equipment Elevations - Bar
QF202	Foodservice Equipment Elevations
QF203	Foodservice Equipment Elevations - Kitchen
QF301	Foodservice Plumbing Rough-in Plan & Schedule
QF401	Foodservice Electrical Rough-in Plan & Schedule
QF501	Foodservice Special Conditions Plan
QF601	Foodservice Equipment Details
QF602	Foodservice Equipment Details
QF603	Foodservice Equipment Details - Walk-in
QF801	Foodservice Walk-in Details
MECHANICAL	
M001	Reference Sheet
M100	Demolition Plan
M200	Plumbing Plan
M300	Mechanical Plans
M400	Plumbing Details
M401	HVAC Details
M402	Mechanical Schedules
ELECTRICAL	
E000	Legends and Details
E001	Existing First Floor Plan
E100	Lighting First Floor Plan
E200	Power First Floor Plan
E201	Electrical Roof Plan
E202	Panel Schedules
E203	Power Details
E300	Systems First Floor Plan
E301	Systems Details



American Legion
352 Main St.
New Town, ND 58763

STRUCTURAL

ICON ARCHITECTURAL GROUP
222 EAST MAIN STREET, SUITE B
MANDAN, ND 58554
(701) 751.0430 OFFICE

MECHANICAL

PRAIRIE ENGINEERING
1905 17TH ST SE
MINOT, ND 58701
(701) 852.6363 OFFICE

ELECTRICAL

PRAIRIE ENGINEERING
1905 17TH ST SE
MINOT, ND 58701
(701) 852.6363 OFFICE

CIVIL

MOORE ENGINEERING
1411 W DAKOTA PKWY SUITE 1B
WILLISTON, ND 58801
(701) 212.3937 OFFICE

FOODSERVICE

FOODSERVICE CONCEPT DESIGN
7900 INTERNATIONAL DRIVE
SUITE 300 -7043
BLOOMINGTON, MN 55425
(612) 325.1494 OFFICE



DRAWING HISTORY

NO.	DESCRIPTION	DATE
1	Construction Documents	08/12/26
2	Addendum 1	08/21/26

DRAWN BY: JLU/AN/BC

JN: 23-018

General Notes / Drawing
Index

SHEET

G001



ICON ARCHITECTURAL GROUP
222 EAST MAIN STREET, SUITE B
MANDAN, ND 58554
(701) 751.0430 OFFICE

PRAIRIE ENGINEERING
1905 17TH ST SE
MINOT, ND 58701
(701) 852.6363 OFFICE

PRAIRIE ENGINEERING
1905 17TH ST SE
MINOT, ND 58701
(701) 852.6363 OFFICE

MOORE ENGINEERING
1411 W DAKOTA PKWY SUITE 1B
WILLISTON, ND 58801
(701) 212.3937 OFFICE



FOODSERVICE CONCEPT DESIGN
7900 INTERNATIONAL DRIVE
SUITE 300 -7043
BLOOMINGTON, MN 55425
(612) 325.1494 OFFICE

1. ALL EXTERIOR GLAZING GL-1 UNLESS OTHERWISE NOTED. ALL INTERIOR GLAZING GL-2 UNLESS OTHERWISE NOTED.

GLAZING TYPES:
SEE SPEC FOR MORE INFORMATION
GL-1: TYPICAL EXTERIOR LOW-E TINTED INSULATING GLASS
GL-2: TYPICAL INTERIOR MONOLITHIC INTERIOR VISION GLAZING

GLASS MARK

DOOR SCHEDULE																
Door Number	Room	Exterior Door	Door Pair	Door							Hardware	Frame				Comments
				Width	Height	Thickness	Type	Material	Finish	Glazing		Type	Material	Finish		
101.1	VEST.		Y	6'-0"	7'-0"	1 3/4"	FG	AL	AL		09	S1	AL	AL	ACCESS CONTROL BY OWNER'S VENDOR	
101.2	VEST.		Y	6'-0"	7'-0"	1 3/4"	FG	AL	AL		11	S1	AL	AL		
103	STOR.		N	3'-0"	7'-0"	1 3/4"	F	WOOD	PLAM-1		01	1	HM	PT-4		
107	BAR		Y	6'-0"	7'-0"	1 3/4"	FG	WOOD	PLAM-1		13	1	HM	PT-4		
108.1	KITCHEN		N	3'-6"	7'-0"	1 1/2"	F	HM	PT-6		07	1	HM	PT-6	ACCESS SCHEDULE BY OWNER'S VENDOR	
108.2	KITCHEN		Y	5'-0"	7'-0"	3/4"	N	WOOD	SEE SPEC		06	1	HM	PT-4		
108.3	KITCHEN		N	2'-6"	7'-0"	3/4"	N	WOOD	SEE SPEC		06	1	HM	PT-4		
108A	OFFICE		N	3'-0"	7'-0"	1 3/4"	F	WOOD	PLAM-1		01	1	HM	PT-4		
108B	RR		N	3'-0"	7'-0"	1 3/4"	F	WOOD	PLAM-1		05	1	HM	PT-4		
110	BAR		Y	6'-0"	7'-0"	1 3/4"	FG	WOOD	PLAM-1		13	1	HM	PT-4		
111.1	VEST		N	3'-4"	7'-0"	1 3/4"	F	HM	PT-6		10	1	HM	PT-6	ACCESS CONTROL BY OWNER'S VENDOR	
111.2	VEST		N	3'-0"	7'-0"	1 3/4"	F	WOOD	PLAM-1		12	1	HM	PT-4		
112	MECH.		N	3'-0"	7'-0"	1 3/4"	F	WOOD	PLAM-1		02	1	HM	PT-4		
113	PRIVATE DINING		Y	6'-0"	7'-0"	1 3/4"	FG	WOOD	PLAM-1		03	1	HM	PT-4	FILM-1. SEE FINISH SCHEDULE	
116.1	VEST.		N	3'-0"	7'-0"	1 3/4"	G	AL	AL			S4	AL	AL	ACCESS CONTROL BY OWNER'S VENDOR	
116.2	VEST.		Y	5'-0"	7'-0"	1 3/4"	F	WOOD	PLAM-1		04		S6	AL		AL
116.3	VEST.		Y	6'-0"	7'-0"	1 3/4"	FG	WOOD	PLAM-1		14	1	HM	PT-4		

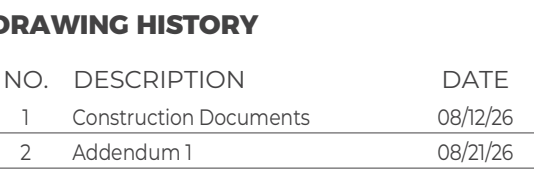 


RAWN BY: JL/AN/BC JN: 23-018

Door Schedule & Storefront Elevations


SHEET

A601

Autodesk Docs: 025-018 American Legion - New Town, ND American Legion Post 290 - FS Equip Plan_QF01.vit 9/21/2026 3:32:36 PM

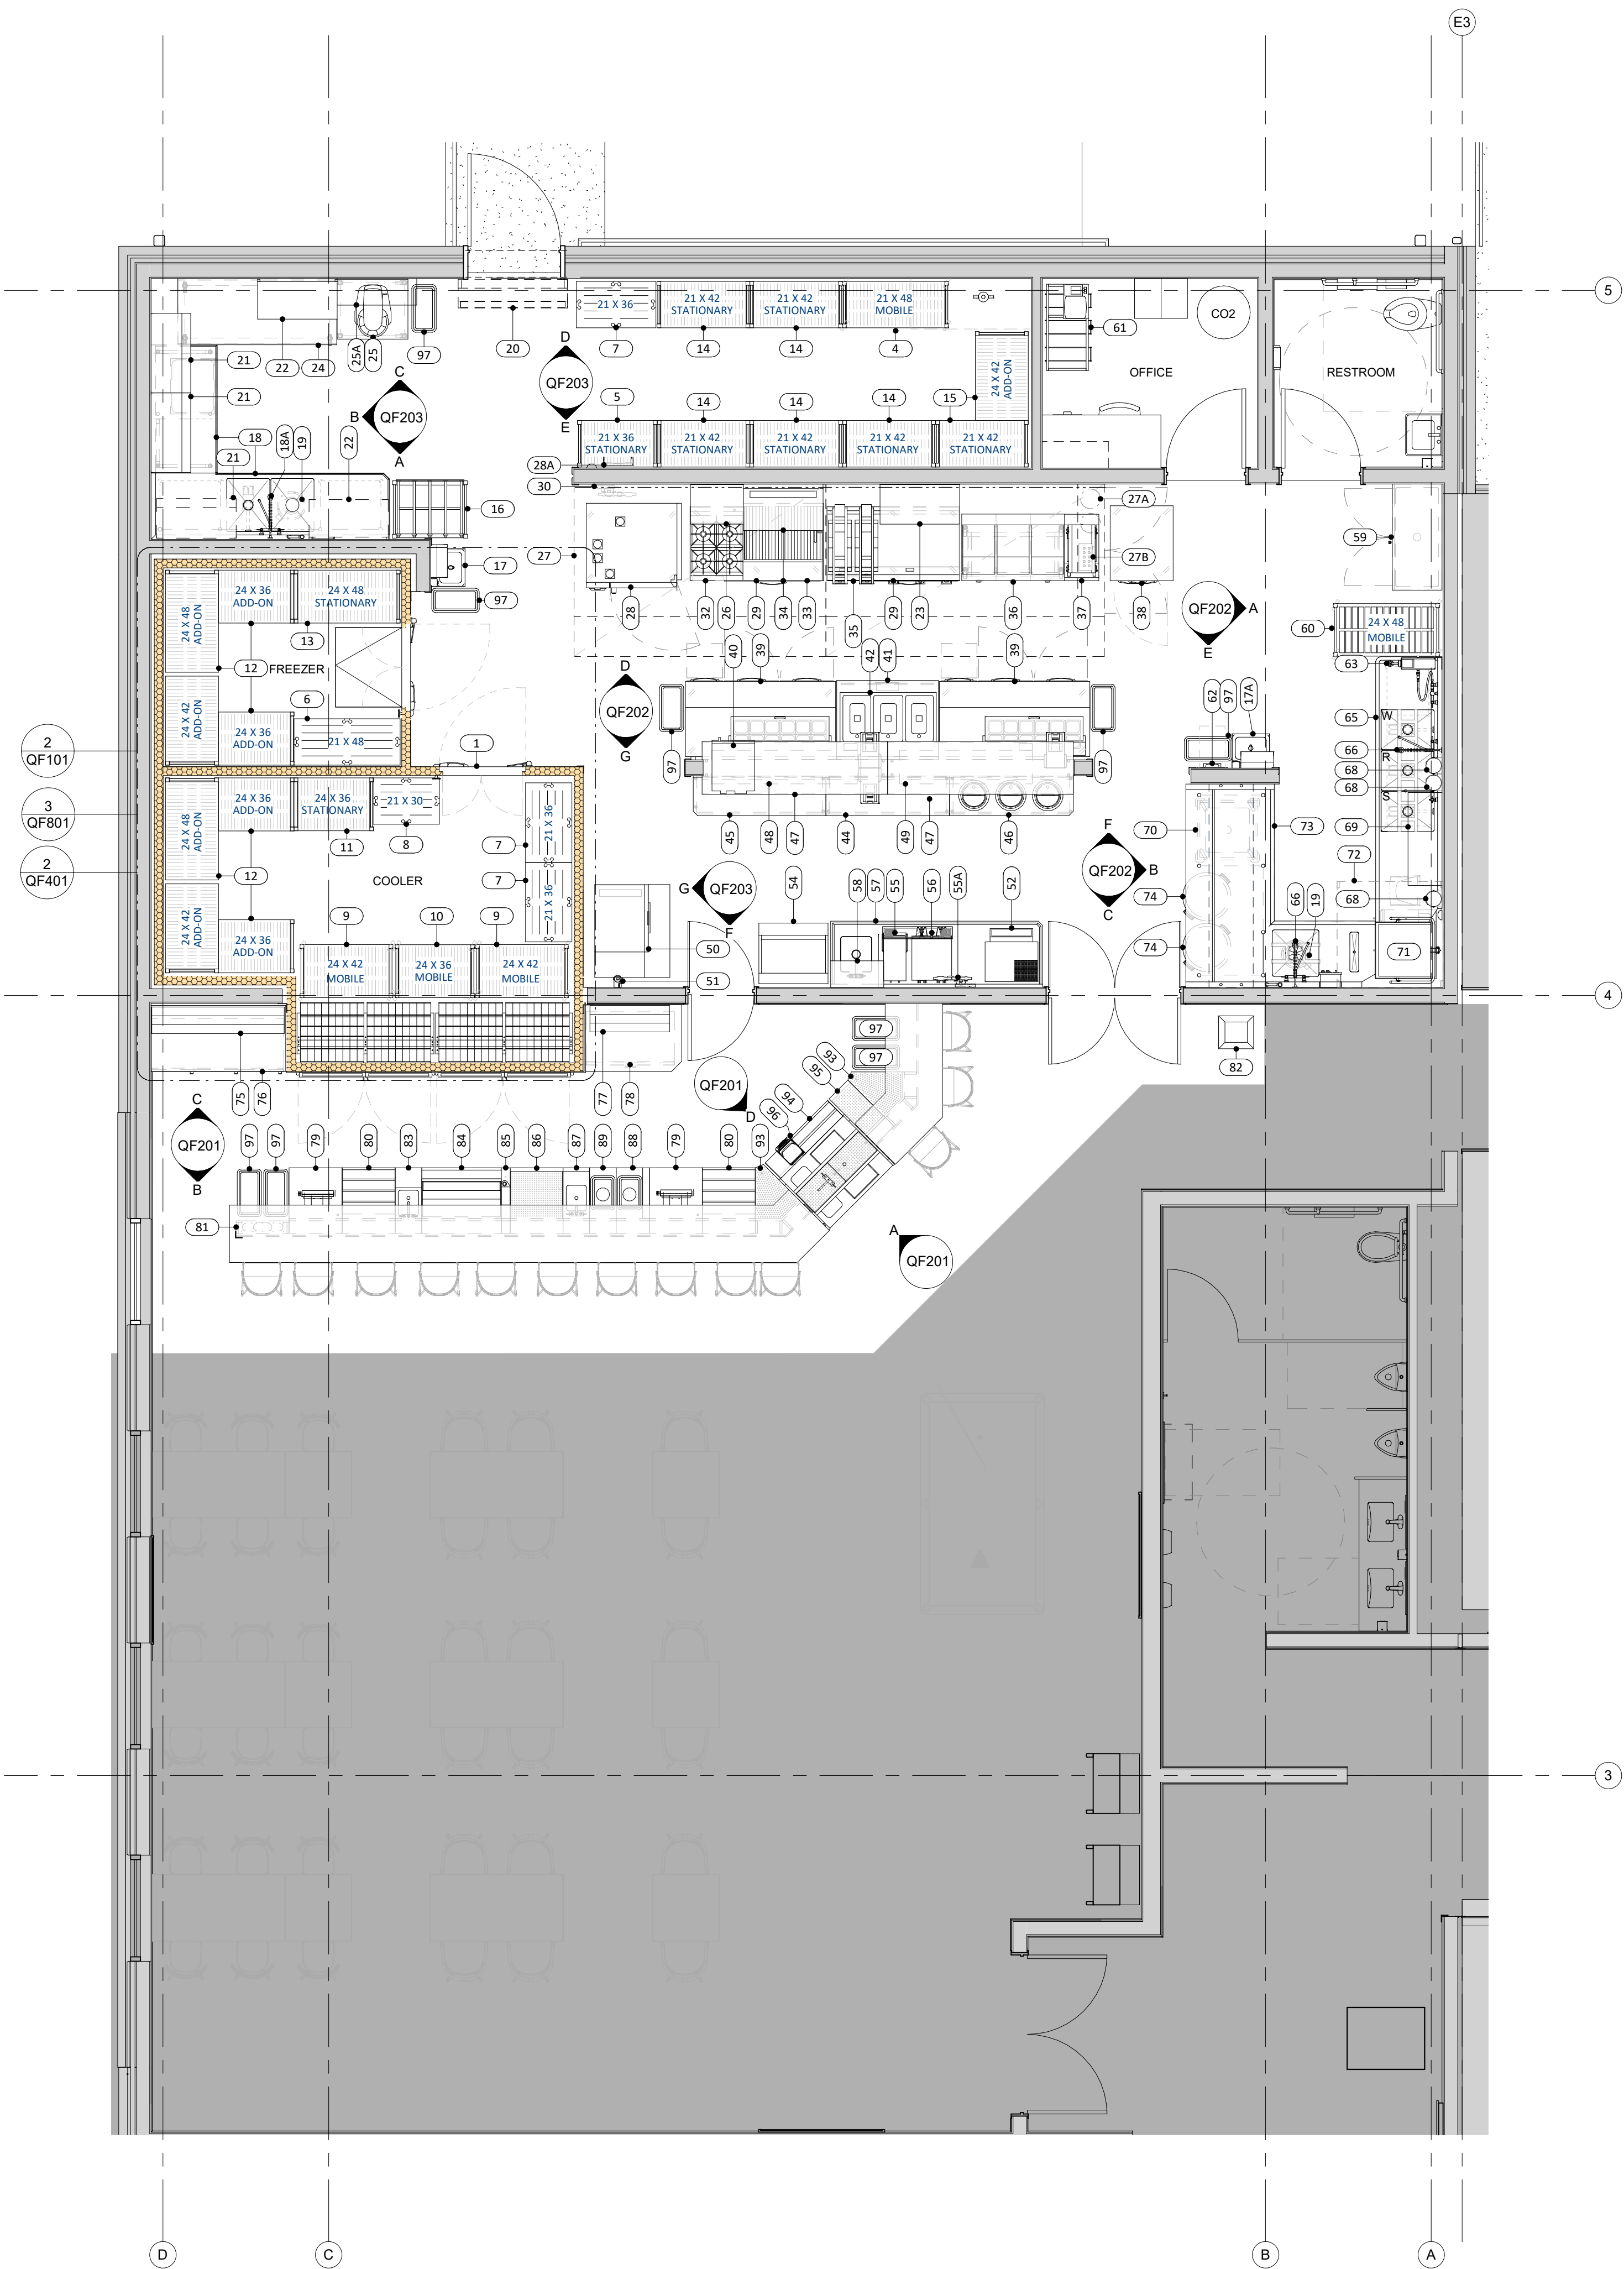

1 FOODSERVICE EQUIPMENT PLAN
1/4" = 1'-0"

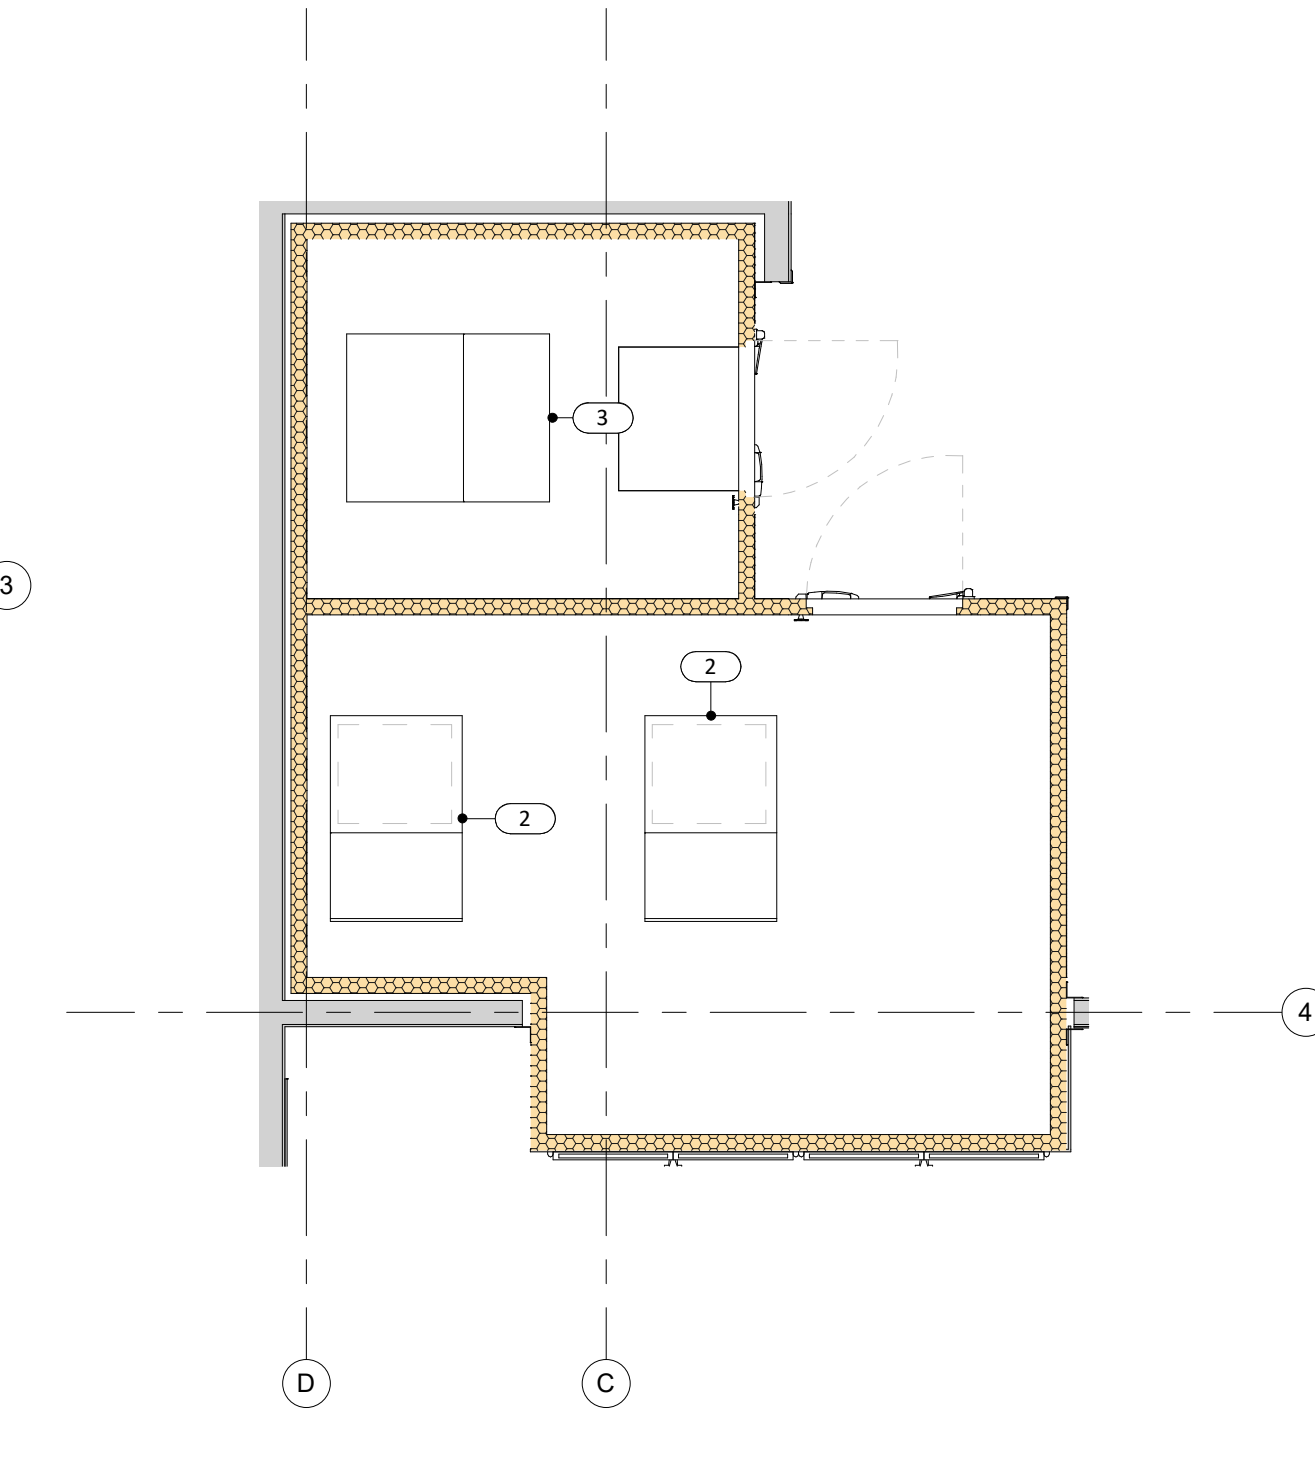

2 FOODSERVICE EQUIPMENT PLAN - T.O. WALK-IN 1
1/4" = 1'-0"

- EQUIPMENT NOTES**
1. THE FOODSERVICE EQUIPMENT PLANS ARE FOR REFERENCE ONLY TO ASSIST THE LICENSED GENERAL CONTRACTOR (GC) & OTHER TRADES IN THEIR WORK. THE OWNER IS RESPONSIBLE FOR ADDITIONAL SUBMITTALS REQUIRED BY THE LOCAL AUTHORITIES HAVING JURISDICTION (AHS). THE FOODSERVICE EQUIPMENT PLANS ARE NOT INTENDED TO BE COMPLETE CONSTRUCTION PLANS.
 2. ALL TRADES SHALL VERIFY THE REQUIREMENTS OF THE NATIONAL, STATE AND LOCAL BUILDING CODES PRIOR TO INSTALLING.
 3. THE GC SHALL FURNISH & INSTALL REINFORCEMENT ABOVE THE FINISHED CEILING FOR HANGING FSEC FURNISHED EQUIPMENT INCLUDING KITCHEN EXHAUST HOODS. THE GC SHALL COORDINATE THE EXACT SIZE & REQUIREMENTS WITH FSEC & CORRESPONDING MANUFACTURER SHOP DRAWINGS.
 4. GC FIRE-RATED SHAFTS WHERE REQUIRED FOR KITCHEN EXHAUST DUCTS IN ACCORDANCE WITH NATIONAL, STATE, & LOCAL BUILDING CODES.
 5. GC SHALL FURNISH & INSTALL STRUCTURAL SUPPORT FOR ROOFTOP EQUIPMENT WHERE REQUIRED. GC SHALL COORDINATE WITH THE ARCHITECT & ENGINEER TO VERIFY THE STRUCTURAL CALCULATIONS FOR ROOF LOADS.
 6. THE FSEC SHALL NOTIFY THE DESIGNER OF CHANGES TO THE FOODSERVICE EQUIPMENT PLANS & COORDINATE WITH GC & OTHER TRADES.
 7. FSEC SHALL VERIFY ALL EQUIPMENT SIZES & FIELD VERIFY THE LOCATIONS & REQUIREMENTS OF ROUGH-INS IN THE EVENT OF CHANGES TO FOODSERVICE EQUIPMENT PLANS.

FOODSERVICE EQUIPMENT SCHEDULE

ITEM NO.	QTY.	DESCRIPTION	STATUS	FURNISHED BY	INSTALLED BY
1	1	WALK-IN COMBINATION COOLER FREEZER	NEW	FSEC	FSEC
2	2	COOLER REFRIGERATOR SYSTEM	NEW	FSEC	FSEC
3	1	FREEZER REFRIGERATION SYSTEM	NEW	FSEC	FSEC
4	1	48" X 21" X 75"H, 5-TIER MOBILE SHELVING UNIT	NEW	FSEC	FSEC
5	1	36" X 21" X 84"H, 4-TIER SHELVING UNIT	NEW	FSEC	FSEC
6	1	48" X 21" DUNNAGE RACK	NEW	FSEC	FSEC
7	3	36" X 21" DUNNAGE RACK	NEW	FSEC	FSEC
8	1	30" X 21" DUNNAGE RACK	NEW	FSEC	FSEC
9	2	42" X 24" X 78"H, 5-TIER MOBILE SHELVING UNIT	NEW	FSEC	FSEC
10	1	36" X 24" X 78"H, 5-TIER MOBILE SHELVING UNIT	NEW	FSEC	FSEC
11	1	36" X 24" X 84"H, 5-TIER SHELVING UNIT	NEW	FSEC	FSEC
12	2	36" X 88" X 48" X 84"H 5-TIER L-SHAPED SHELVING UNIT	NEW	FSEC	FSEC
13	1	48" X 24" X 84"H, 5-TIER SHELVING UNIT	NEW	FSEC	FSEC
14	5	42" X 21" X 84"H, 5-TIER SHELVING UNIT	NEW	FSEC	FSEC
15	1	42" X 63" X 84"H 5-TIER L-SHAPED SHELVING UNIT	NEW	FSEC	FSEC
16	1	CAN RACK	NEW	FSEC	FSEC
17	1	HAND SINK WITH SIDE SPLASH & KNEE VALVE APRON	NEW	FSEC	FSEC
17A	1	HAND SINK WITH KNEE VALVE APRON	NEW	FSEC	DIV. 22
18	1	108" X 88" L-SHAPED WORKTABLE WITH PREP SINKS	NEW	FSEC	FSEC
18A	1	PREP PRE-RINSE FAUCET ASSEMBLY WITH ADD-ON FAUCET & ULTRARINSE	NEW	FSEC	DIV. 22
19	2	2 HP DISPOSER	NEW	FSEC	FSEC
20	1	42" AIR CURTAIN	NEW	FSEC	FSEC
21	3	36" X 18" 3-TIER WALL SHELF	NEW	FSEC	FSEC
22	2	36" X 18" WALL GRID SHELF	NEW	FSEC	FSEC
23	1	36" X 18" WALL SHELF	NEW	FSEC	FSEC
24	1	60" X 30" MOBILE WORK TABLE	NEW	FSEC	FSEC
25	1	20 QT PLANETARY MIXER WITH MOBILE STAND	NEW	FSEC	FSEC
25A	1	36" X 12" MIXER WALL SHELF	NEW	FSEC	FSEC
26	1	24" X 18" WALL SHELF	NEW	FSEC	FSEC
27	1	228" X 60" EXHAUST HOOD WITH SUPPLY PLENUM	NEW	FSEC	DIV. 23
27A	1	FIRE SUPPRESSION SYSTEM	NEW	FSEC	FSEC
27B	1	VARIABLE VOLUME HOOD CONTROL	NEW	FSEC	DIV. 23
27C	1	UPBLAST EXHAUST FAN (NOT SHOWN)	NEW	DIV. 23	DIV. 23
27D	1	MAKE-UP AIR UNIT (NOT SHOWN)	NEW	DIV. 23	DIV. 23
28	1	COMBI OVEN WITH STAND	NEW	FSEC	FSEC
28A	1	WATER SOFTENER SYSTEM FOR COMBI OVEN	NEW	FSEC	DIV. 22
29	2	60" REFRIGERATED EQUIPMENT STAND	NEW	FSEC	FSEC
30	1	COMBI WATER FILTRATION SYSTEM	NEW	FSEC	DIV. 22
31		SPARE NUMBER			
32	1	24" 4-BURNER COUNTERTOP HOT PLATE WITH STEP-UP REAR	NEW	FSEC	FSEC
33	1	36" COUNTERTOP CHARBROILER	NEW	FSEC	FSEC
34	1	36" WALL MOUNTED SALAMANDER BROILER	NEW	FSEC	FSEC
35	1	60" COUNTERTOP GRIDDLE WITH 2 CLAMSHELLS	NEW	FSEC	FSEC
36	1	TRIPLE FRYER BATTERY WITH BUILT-IN FILTRATION	NEW	FSEC	FSEC
37	1	FRY DUMP STATION WITH WARMER	NEW	FSEC	FSEC
38	1	1-SEC. REACH-IN FREEZER WITH 1 DOOR & 2 DRAWERS	NEW	FSEC	FSEC
39	2	68" SANDWICH REFRIGERATED PREP TABLE	NEW	FSEC	FSEC
40	1	2200W MICROWAVE OVEN	NEW	FSEC	FSEC
41	1	46" X 36" OPEN FRONT WORKTABLE CABINET BASE	NEW	FSEC	FSEC
42	1	3-WELL HOT FOOD DROP-IN UNIT	NEW	FSEC	FSEC
43		SPARE NUMBER			
44	1	60" X 18" DISH CABINET	NEW	FSEC	FSEC
45	1	60" X 18" DISH CABINET	NEW	FSEC	FSEC
46	1	60" X 18" DISH CABINET WITH SOUP WELLS	NEW	FSEC	FSEC
47	2	84" X 24" PASS-THRU SHELF WITH PRINTER SHELVES	NEW	FSEC	FSEC
48	1	60" DUAL HEAT LAMP WITH LIGHTS	NEW	FSEC	FSEC
49	1	60" DUAL HEAT LAMP WITH LIGHTS	NEW	FSEC	FSEC
50	1	582LB ICE MACHINE WITH 42" BIN	NEW	FSEC	FSEC
51	1	ICE MACHINE WATER FILTRATION SYSTEM	NEW	FSEC	FSEC
52	1	WALL MOUNTED LETTUCE CRISPER	NEW	FSEC	FSEC
53		SPARE NUMBER			
54	1	SODA DISPENSER, IN-COUNTER	NEW	BY VENDOR	BY VENDOR
55	1	ICED TEA BREWER	NEW	FSEC	FSEC
55A	1	TEA & COFFEE BREWER WATER FILTRATION SYSTEM	NEW	FSEC	FSEC
56	1	DUAL COFFEE BREWER	NEW	FSEC	FSEC
57	1	96" X 30" BEVERAGE COUNTER	NEW	FSEC	FSEC
58	1	24" X 12" WALL SHELF	NEW	FSEC	FSEC
59	1	MOP SINK CABINET	NEW	FSEC	FSEC
60	1	48" X 24" MOBILE DRYING RACK	NEW	FSEC	FSEC
61	1	BAG-IN-BOX SYSTEM	NEW	OTHER	OTHER
62	1	RECESSED EYE WASH STATION	NEW	FSEC	DIV. 22
63	1	HOSE REEL	NEW	FSEC	DIV. 22
64		SPARE NUMBER			
65	1	120" X 30" 3-COMP CLEAN DISHTABLE	NEW	FSEC	FSEC
66	2	WAREWASHING PRE-RINSE WITH ADD ON FAUCET	NEW	FSEC	DIV. 22
67		SPARE NUMBER			
68	3	DETERGENT DISPENSER	NEW	OTHER	OTHER
69	1	42" SLANTED SORTING SHELF	NEW	FSEC	FSEC
70	1	MOBILE SOAK SINK	NEW	FSEC	FSEC
71	1	DOOR TYPE DISHWASHER	NEW	FSEC	FSEC
72	1	48" X 48" CONDENSATE HOOD	NEW	FSEC	DIV. 23
72A	1	CONDENSATE FAN (NOT SHOWN)	NEW	DIV. 23	DIV. 23
73	1	92" X 84" L-SHAPED SOILED DISHTABLE	NEW	FSEC	FSEC
74	2	BRUTE TRASH CAN	NEW	OTHER	OTHER
75	1	60" LIQUOR BOTTLE DISPLAY	NEW	FSEC	FSEC
76	1	60" BACK BAR DRY STORAGE	NEW	FSEC	FSEC
77	1	36" LIQUOR BOTTLE DISPLAY	NEW	FSEC	FSEC
78	1	40" BACK BAR DRY STORAGE	NEW	FSEC	FSEC
79	2	24" UNDERBAR POS WORK CENTER	NEW	FSEC	FSEC
80	2	24" UNDERBAR BOTTLE STORAGE	NEW	FSEC	FSEC
81	28	MODULAR BAR DIE WALL	NEW	FSEC	FSEC
82	1	MINI JETSTAR POPCORN POPPER	NEW	FSEC	FSEC
83	1	12" UNDERBAR BLENDER STATION	NEW	FSEC	FSEC
84	1	36" UNDERBAR ICE BIN	NEW	FSEC	FSEC
85	1	4" UNDERBAR SODA CHASE	NEW	FSEC	FSEC
86	1	24" UNDERBAR DRAINBOARD	NEW	FSEC	FSEC
87	1	12" UNDERBAR HAND SINK	NEW	FSEC	FSEC
88	1	15" UNDERBAR WASTE BIN - RIGHT	NEW	FSEC	FSEC
89	1	15" UNDERBAR WASTE BIN - LEFT	NEW	FSEC	FSEC
90-92		SPARE NUMBER			
93	2	45 DEGREE UNDERBAR DRAINBOARD	NEW	FSEC	FSEC
94	1	42" PASS-THRU COCKTAIL STATION	NEW	FSEC	FSEC
95	1	12" UNDERBAR DRAINBOARD	NEW	FSEC	FSEC
96	1	64 OZ. BAR DRINK BLENDER	NEW	FSEC	FSEC
97	9	SLIM JIM TRASH CAN	NEW	OWNER	OWNER

214 N 4TH STREET, SUITE 208
GRAND FORKS, ND 58203
(701) 772.4266 OFFICE
WWW.ICONARCHITECTS.COM

**American Legion
Post 290**
352 Main St.
New Town, ND 58763

STRUCTURAL
ICON ARCHITECTURAL GROUP
222 EAST MAIN STREET, SUITE B
MANDAN, ND 58554
(701) 751.0430 OFFICE

MECHANICAL
PRAIRIE ENGINEERING
1905 17TH ST SE
MINOT, ND 58701
(701) 852.6363 OFFICE

ELECTRICAL
PRAIRIE ENGINEERING
1905 17TH ST SE
MINOT, ND 58701
(701) 852.6363 OFFICE

CIVIL
MOORE ENGINEERING
1411 W DAKOTA PKWY SUITE 1B
WILLISTON, ND 58801
(701) 212.3937 OFFICE

FOODSERVICE
FOODSERVICE CONCEPT DESIGN
7900 INTERNATIONAL DRIVE
SUITE 300 -7043
BLOOMINGTON, MN 55425
(612) 325.1494 OFFICE

**BID
DOCUMENTS**

DRAWING HISTORY


NO.	DESCRIPTION	DATE
1	Construction Documents	08/12/26
2	Addendum 1	08/21/26

DRAWN BY: MJH JN: 23-018

**FOODSERVICE EQUIPMENT
PLAN & SCHEDULE**

SHEET
QF101

Autodesk Docs: 022-018 American Legion - New Town, ND American Legion Post 290 - FS Equip Plan_2023.vit 8/21/2025 3:32:36 PM

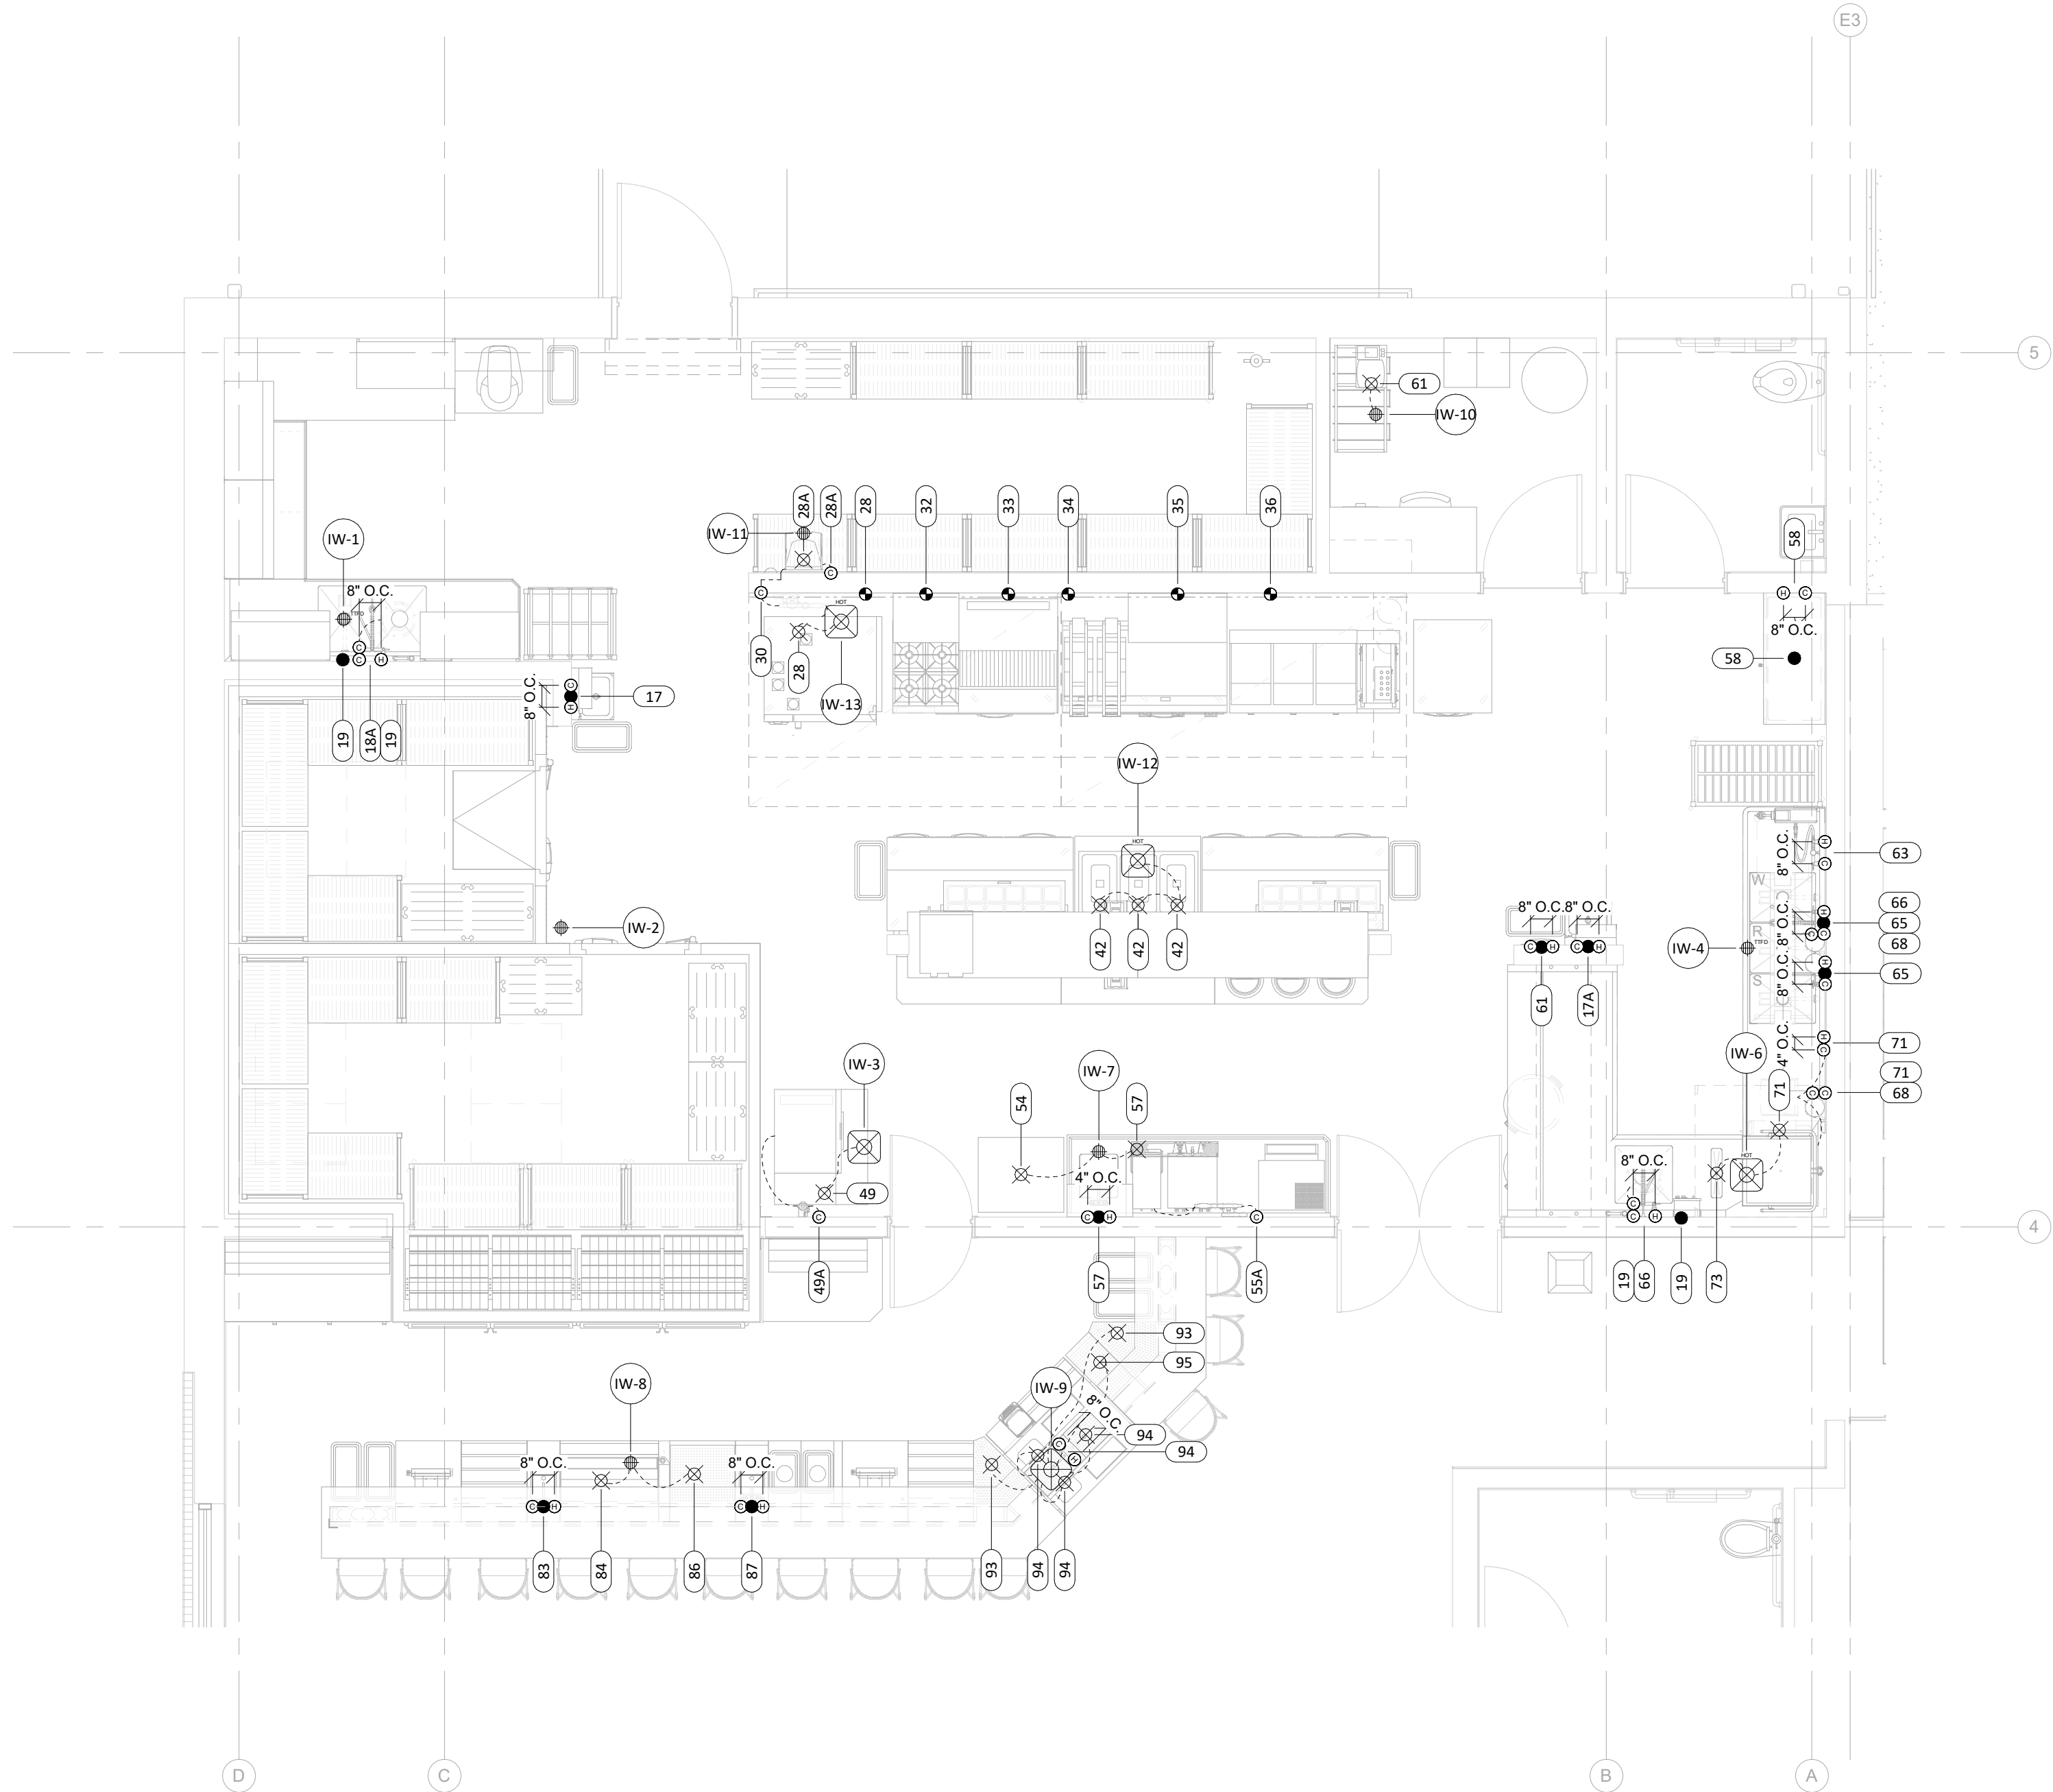

1 FOODSERVICE PLUMBING ROUGH-IN PLAN
1/4" = 1'-0"

FOODSERVICE EQUIPMENT PLUMBING ROUGH-IN SCHEDULE																
ITEM NO.	QTY.	DESCRIPTION	COLD WATER		HOT WATER		FILTERED WATER		DIRECT WASTE		INDIRECT WASTE		GAS		PLUMBING REMARKS	
			SIZE	R.I. HEIGHT	SIZE	R.I. HEIGHT	SIZE	R.I. HEIGHT	SIZE	R.I. HEIGHT	SIZE	TAG NO.	SIZE	MBTU		R.I. HEIGHT
17	1	HAND SINK WITH SIDE SPLASH & KNEE VALVE APRON	1/2"	24"	1/2"	24"			1 1/2"	20"					PLUMBING NOTE 1, 5, 6	
17A	1	HAND SINK WITH KNEE VALVE APRON	1/2"	24"	1/2"	24"			1 1/2"	20"					PLUMBING NOTE 1, 5, 6	
18	1	108" X 88" L-SHAPED WORKTABLE WITH PREP SINKS							2"	12"		TTFD / IW-1			PLUMBING NOTE 1, 3, & 5	
18A	1	PREP PRE-RINSE FAUCET ASSEMBLY WITH ADD-ON FAUCET & ULTRARINSE	1/2"	18"	1/2"	18"									PLUMBING NOTE 5, 9	
19	2	2 HP DISPOSER	1/2"	18"					2"	10"					PLUMBING NOTE 1, 9, 13	
27A	1	FIRE SUPPRESSION SYSTEM													PLUMBING NOTE 21	
28	1	COMBI OVEN WITH STAND					3/4"	#30			1"	HFS / IW-13	3/4"	143.3	30"	PLUMBING NOTE 2, 4, 8, 9; FW FROM #30
28A	1	WATER SOFTENER SYSTEM FOR COMBI OVEN	3/4"	18"							3/8"	FD / IW-11				PLUMBING NOTE 2, 4, 9; SUPPLIES SOFTEN WATER TO #30
30	1	COMBI WATER FILTRATION SYSTEM	3/4"	24"												PLUMBING NOTE 4, 9; SOFTEN WATER FROM #28A
32	1	24" 4-BURNER COUNTERTOP HOT PLATE WITH STEP-UP REAR											3/4"	110	30"	PLUMBING NOTE 8
33	1	36" COUNTERTOP CHARBROILER											3/4"	66	30"	PLUMBING NOTE 8
34	1	36" WALL MOUNTED SALAMANDER BROILER											3/4"	50	30"	PLUMBING NOTE 8
35	1	60" COUNTERTOP GRIDDLE WITH 2 CLAMSHELLS											3/4"	135	30"	PLUMBING NOTE 8
36	1	TRIPLE FRYER BATTERY WITH BUILT-IN FILTRATION											1/2"	120	30"	PLUMBING NOTE 8
42	1	3-WELL HOT FOOD DROP-IN UNIT									3/4"	HFS / IW-12				PLUMBING NOTE 2
50	1	582LB ICE MACHINE WITH 42" BIN					3/8"	#49A			3/4"	FS / IW-3				PLUMBING NOTE 2, 4, 9, 10; FW FROM #49A
51	1	ICE MACHINE WATER FILTRATION SYSTEM	3/8"	72"												PLUMBING NOTE 4, 9, 10; SUPPLIES FW TO ITEM #49
54	1	SODA DISPENSER, IN-COUNTER									1/2"	FD / IW-7				PLUMBING NOTE 2, 22
55	1	ICED TEA BREWER					1/4"	#55A								PLUMBING NOTE 4, 9, 10; FW FROM #55A
55A	1	TEA & COFFEE BREWER WATER FILTRATION SYSTEM	3/4"	72"												PLUMBING NOTE 4, 9, 10; SUPPLIES FW TO ITEM #55 and ITEM #56
56	1	DUAL COFFEE BREWER					1/2"	#55A								PLUMBING NOTE 4, 9, 10; FW FROM #55A
59	1	MOP SINK CABINET	1/2"	36"	1/2"	36"			3 1/2"	0"						PLUMBING NOTE 1, 5, 9
61	1	BAG-IN-BOX SYSTEM									1/2"	FD / IW-11				PLUMBING NOTE 2
62	1	RECESSED EYE WASH STATION	1/2"	18"					2"	18"						PLUMBING NOTE 1, 4, 9, & RECESS IN WALL
63	1	HOSE REEL	1/2"	18"	1/2"	18"										PLUMBING NOTE 4, 5, 9, 13
65	1	120" X 30" 3-COMP CLEAN DISHTABLE							2"	12"		TTFD / IW-4				PLUMBING NOTE 1, 3, 5, & 7
66	2	WAREWASHING PRE-RINSE WITH ADD ON FAUCET	1/2"	18"	1/2"	18"										PLUMBING NOTE 5, 9
68	3	DETERGENT DISPENSER	1/2"	50"												PLUMBING NOTE 22
71	1	DOOR TYPE DISHWASHER	3/4"	18"	3/4"	18"					1 1/2"	HFS / IW-6				PLUMBING NOTE 2, 4, 16, & 17
73	1	92" X 84" L-SHAPED SOILED DISHTABLE									1"	HFS / IW-6				PLUMBING NOTE 2
83	1	12" UNDERBAR BLENDER STATION	3/8"	18"	3/8"	18"					1 1/2"					PLUMBING NOTE 5, 9
84	1	36" UNDERBAR ICE BIN									3/4"	FD / IW-8				PLUMBING NOTE 2
86	1	24" UNDERBAR DRAINBOARD									1/2"	FD / IW-8				PLUMBING NOTE 2
87	1	12" UNDERBAR HAND SINK	3/8"	18"	3/8"	18"			1 1/2"	12"						PLUMBING NOTE 1, 5
93	2	45 DEGREE UNDERBAR DRAINBOARD									1/2"	FS / IW-9				PLUMBING NOTE 2
94	1	42" PASS-THRU COCKTAIL STATION	3/8"	18"	3/8"	18"					1 1/2"	FS / IW-9				PLUMBING NOTE 2, 5, 9
95	1	12" UNDERBAR DRAINBOARD									1/2"	FS / IW-9				PLUMBING NOTE 2

- PLUMBING NOTES**
- DIVISION 22 SHALL EXTEND & CONNECT DRAIN(S) TO DW.
 - DIVISION 22 SHALL EXTEND DRAIN(S) TO IW.
 - DIVISION 22 SHALL MANIFOLD DRAINS TO THE MINIMUM CODE-APPROVED NUMBER OF CONNECTIONS & CONNECT TO DW.
 - DIV. 22 SHALL FURNISH AND INSTALL A BACKFLOW PREVENTION DEVICE IF REQUIRED BY THE AHJ.
 - DIVISION 22 SHALL INSTALL FSEC FURNISHED PLUMBING FIXTURES, SUCH AS FAUCETS & WASTE DRAINS FOR FSEC FURNISHED EQPM.
 - DIVISION 22 SHALL INSTALL & CONNECT FSEC FURNISHED WALL-MOUNTED HAND SINK(S) & CORRESPONDING FIXTURE(S) PER THE MFR'S REQUIREMENTS.
 - DIVISION 22 SHALL CONNECT WASTE TO PC FURNISHED & INSTALLED GREASE INTERCEPTOR, COORDINATE LOCATION WITH FSEC & OTHER TRADES.
 - DIVISION 22 SHALL INSTALL (GAS & WATER) QUICK DISCONNECT(S) & RESTRAINING DEVICES FOR EQPM FURNISHED BY FSEC PER THE MFR'S REQUIREMENTS.
 - DIVISION 22 SHALL EXTEND & CONNECT WATER SUPPLY TO FSEC FURNISHED EQPM &/OR FIXTURES.
 - DIVISION 22 SHALL INSTALL & CONNECT FSEC FURNISHED WATER FILTER(S). PC SHALL FURNISH & INSTALL PIPING FROM FILTER OUTLET TO EQPM CONNECTIONS CONCEALED WITHIN WALLS & CLNG.
 - NOT USED
 - NOT USED
 - DIVISION 22 SHALL INSTALL & CONNECT FSEC FURNISHED SOLENOID VALVE(S), VACUUM BREAKER(S), FLOW CONTROL(S), PRESSURE REGULATOR(S), & WATER INLET(S). COORDINATE WITH EC.
 - NOT USED
 - NOT USED
 - DIVISION 22 SHALL CONNECT 110°F MINIMUM HOT WATER SUPPLY TO (70°F RISE) BOOSTER HEATER & CONNECT BOOSTER HEATER TO DISHMACHINE, IF SEPARATE.
 - DIVISION 22 SHALL INSTALL FSEC FURNISHED DRAIN WATER TEMPERING KIT OR DRAIN QUENCH KIT PER MFR'S REQUIREMENTS.
 - NOT USED
 - FSEC SHALL FURNISH & INSTALL SLEEVES THROUGH COLD-STORAGE ROOM(S) & BLDG WALLS FOR CONDENSATE DRAIN LINES. FOAM & FULLY SEAL PENETRATIONS. PC SHALL WRAP CONDENSATE DRAIN LINES WITH INSULATION AFTER FSEC INSTALLS DRAIN LINE HEATER WHERE CONDENSATE DRAIN LINE WILL BE EXPOSED TO FREEZING TEMPS. COORDINATE WITH EC.
 - FSEC SHALL CONNECT DRAIN(S) WITH REFRIGERATION-GRADE HARD COPPER & FURNISH & INSTALL 1" ST&OFFS & P-TRAP IW OUTSIDE COLD-STORAGE ROOM(S).
 - DIVISION 22 SHALL INSTALL FSEC FURNISHED FIRE SUPPRESSION SYSTEM GAS SHUT-OFF VALVE PER MFR'S REQUIREMENTS CONCEALED IN WALL OR CEILING.
 - VERIFY UTILITY REQUIREMENTS FOR EQPM THAT IS NOT INCLUDED IN SECT. 11 40 00 CONTRACT INCLUDING EXISTING EQPM.

PLUMBING LEGEND		
SYMB	DESCRIPTION	ABBREV.
○	COLD/HOT WATER SUPPLY	CW/HW
○	FILTERED WATER CONN.	FW
●	DIRECT WASTE	DW
○	INDIRECT WASTE	IW
○	GAS	NGALP
○	FLOOR DRAIN	FD
○	TELLTALE FLOOR DRAIN	TTFD
○	FUNNEL FLOOR DRAIN	FFD
○	HUB FLOOR DRAIN	HFD
○	FLOOR SINK	FS
○	HOT FLOOR SINK	HFS
○	FIELD PIPING BY PC	FP

DRAWING HISTORY		
NO.	DESCRIPTION	DATE
1	Construction Documents	08/12/26
2	Addendum 1	08/21/26

DRAWN BY: MJH JN: 23-018

FOODSERVICE PLUMBING
ROUGH-IN PLAN & SCHEDULE

SHEET

QF301



**American Legion
Post 290**

352 Main St.
New Town, ND 58763

STRUCTURAL

ICON ARCHITECTURAL GROUP
222 EAST MAIN STREET, SUITE B
MANDAN, ND 58554
(701) 751.0430 OFFICE

MECHANICAL

PRAIRIE ENGINEERING
1905 17TH ST SE
MINOT, ND 58701
(701) 852.6363 OFFICE

ELECTRICAL

PRAIRIE ENGINEERING
1905 17TH ST SE
MINOT, ND 58701
(701) 852.6363 OFFICE

CIVIL

MOORE ENGINEERING
1411 W DAKOTA PKWY SUITE 1B
WILLISTON, ND 58801
(701) 212.3937 OFFICE

FOODSERVICE

FOODSERVICE CONCEPT DESIGN
7900 INTERNATIONAL DRIVE
SUITE 300 -7043
BLOOMINGTON, MN 55425
(612) 325.1494 OFFICE



**BID
DOCUMENTS**

DRAWING HISTORY


NO.	DESCRIPTION	DATE
1	Construction Documents	08/12/26
2	Addendum 1	08/21/26

DRAWN BY: MJH JN: 23-018


**FOODSERVICE EQUIPMENT
DETAILS - WALK-IN**

SHEET

QF604

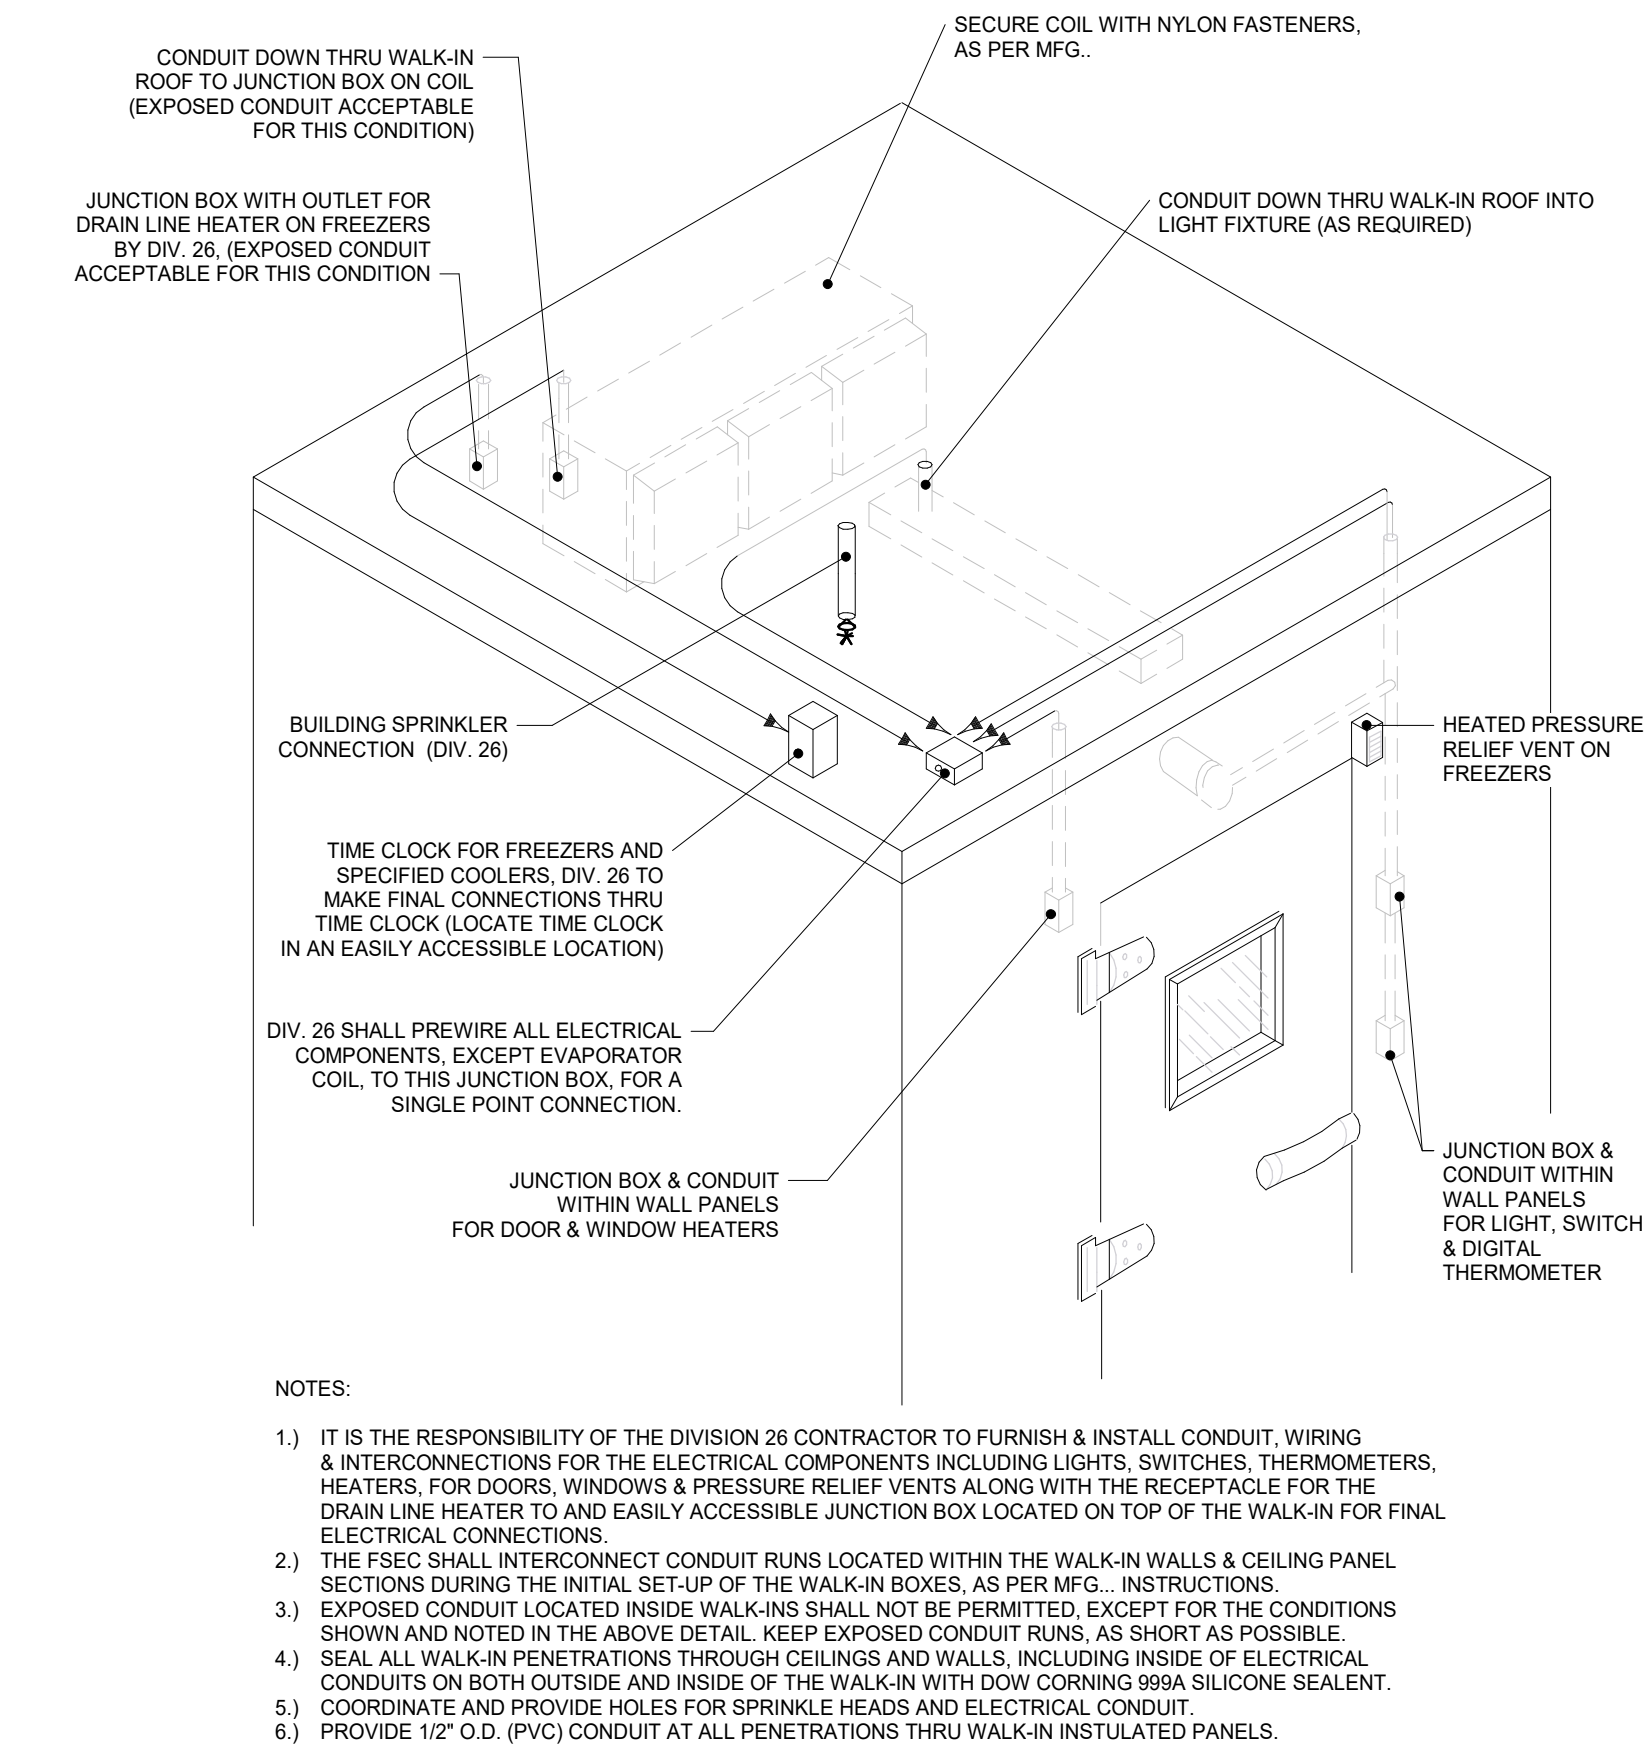


1 CD-06 - COLD STORAGE ROOM
NTS

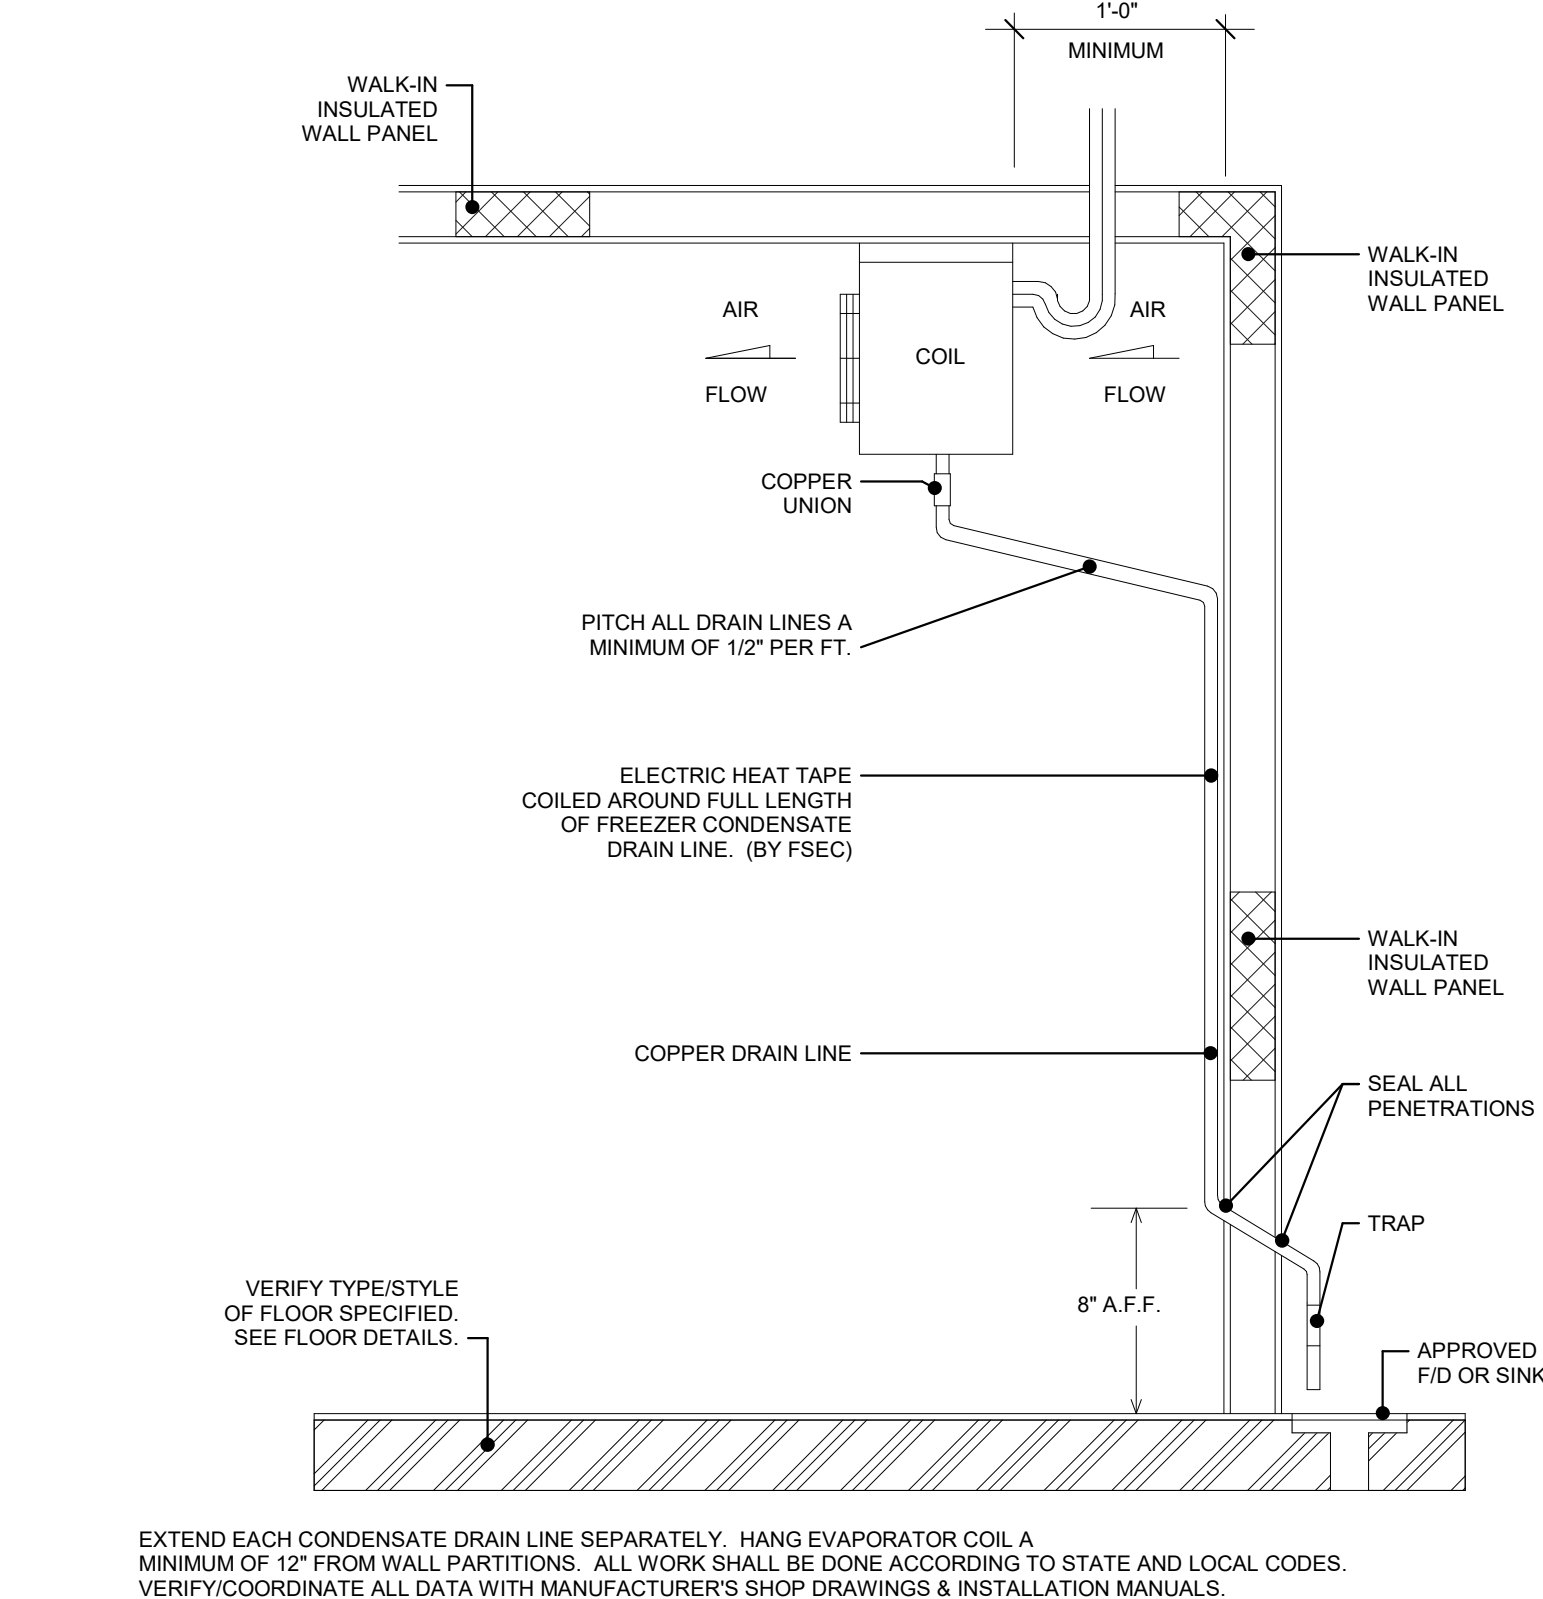


4 CD-13 - WIC CONDENSATE DRAIN LINE
NTS

STANDARD 1000PSF FLOOR (NON-RECESSED) - LOCK TO WALLS FOAM RAIL

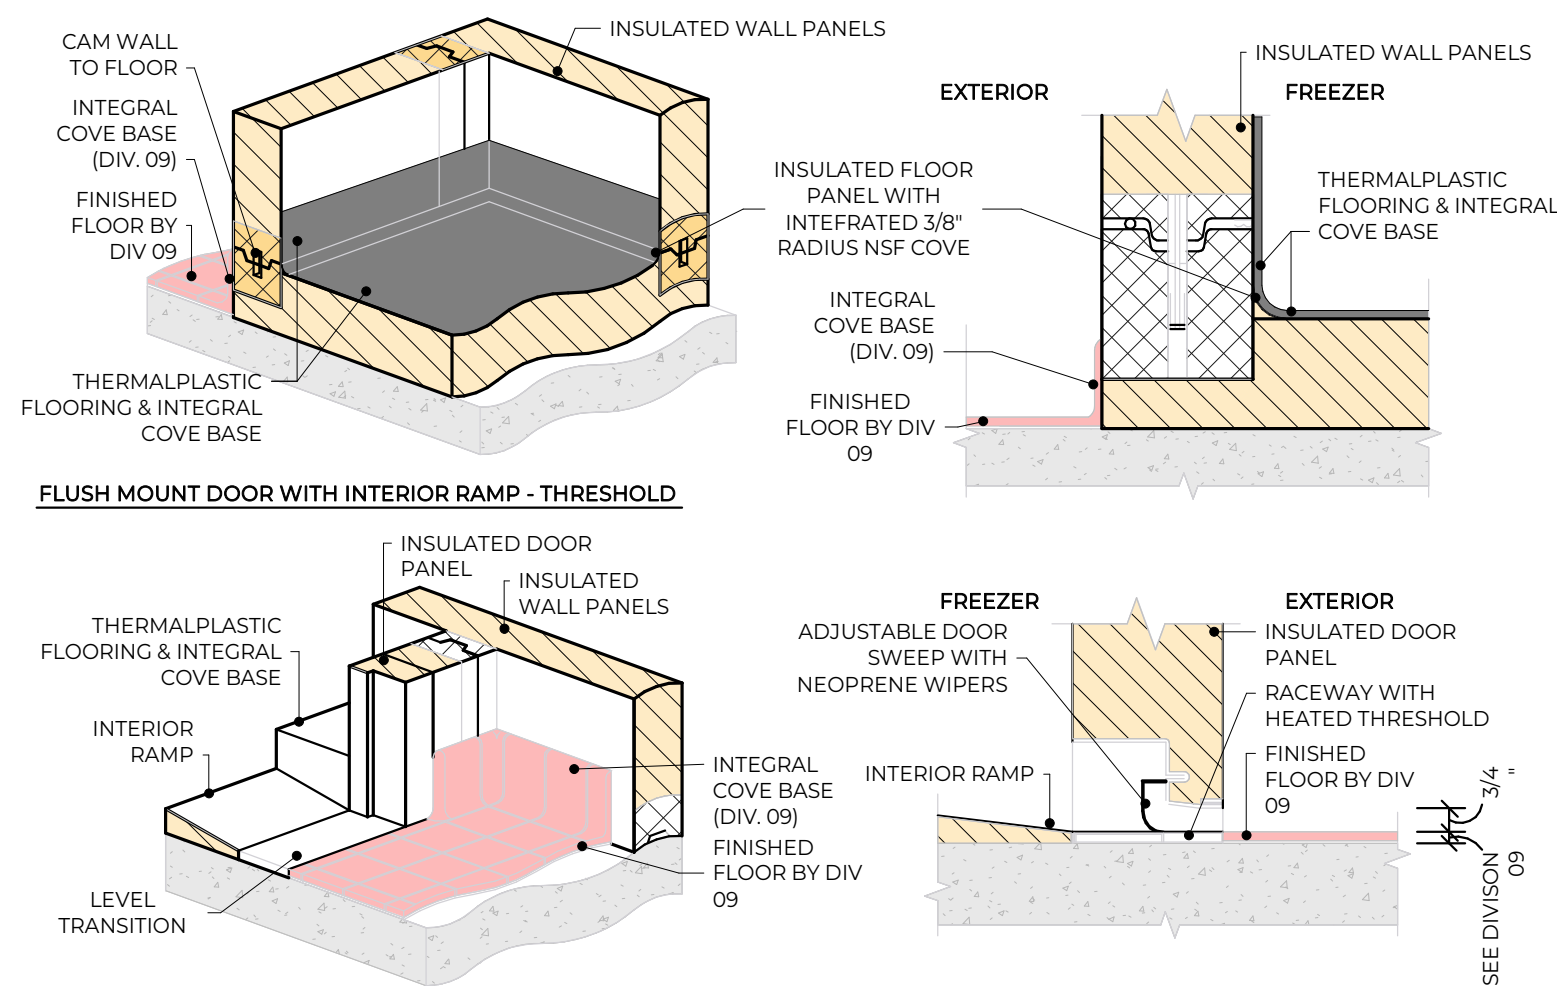

- NOTES:
1. THE FSEC SHALL PROVIDE CRITICAL HOLD-TO-DIMENSIONS IN THEIR COORDINATION DRAWING SUBMITTAL WITH AT LEAST 2" OF CLEARANCE FROM ADJACENT BUILDING WALLS ON ALL SIDES. THE FSEC SHALL VERIFY THESE CRITICAL DIMENSIONS IN THE FIELD PRIOR TO INSTALLATION.
 2. THE FSEC SHALL FURNISH AND INSTALL THE WALK-IN COOLER/FREEZER COMPLEX INCLUDING ALL INSULATED FLOOR PANELS PER SECTION 11 40.00. URETHANE SHALL BE UL APPROVED FOAMED-IN-PLACE AND BIND COMPLETELY TO THE METAL SKINS TO FORM A RIGID 4" THICK INSULATED PANEL WHEN COMPLETELY CURED.
 3. THE FSEC SHALL ADJUST THE DOOR HEIGHTS AND GASKET SWEEPS TO ENSURE A FUNCTIONAL SEAL.

3 CD-07 - TYPE D - COOLER/FREEZER FLOOR WITH RAMP & THRESHOLD
NTS

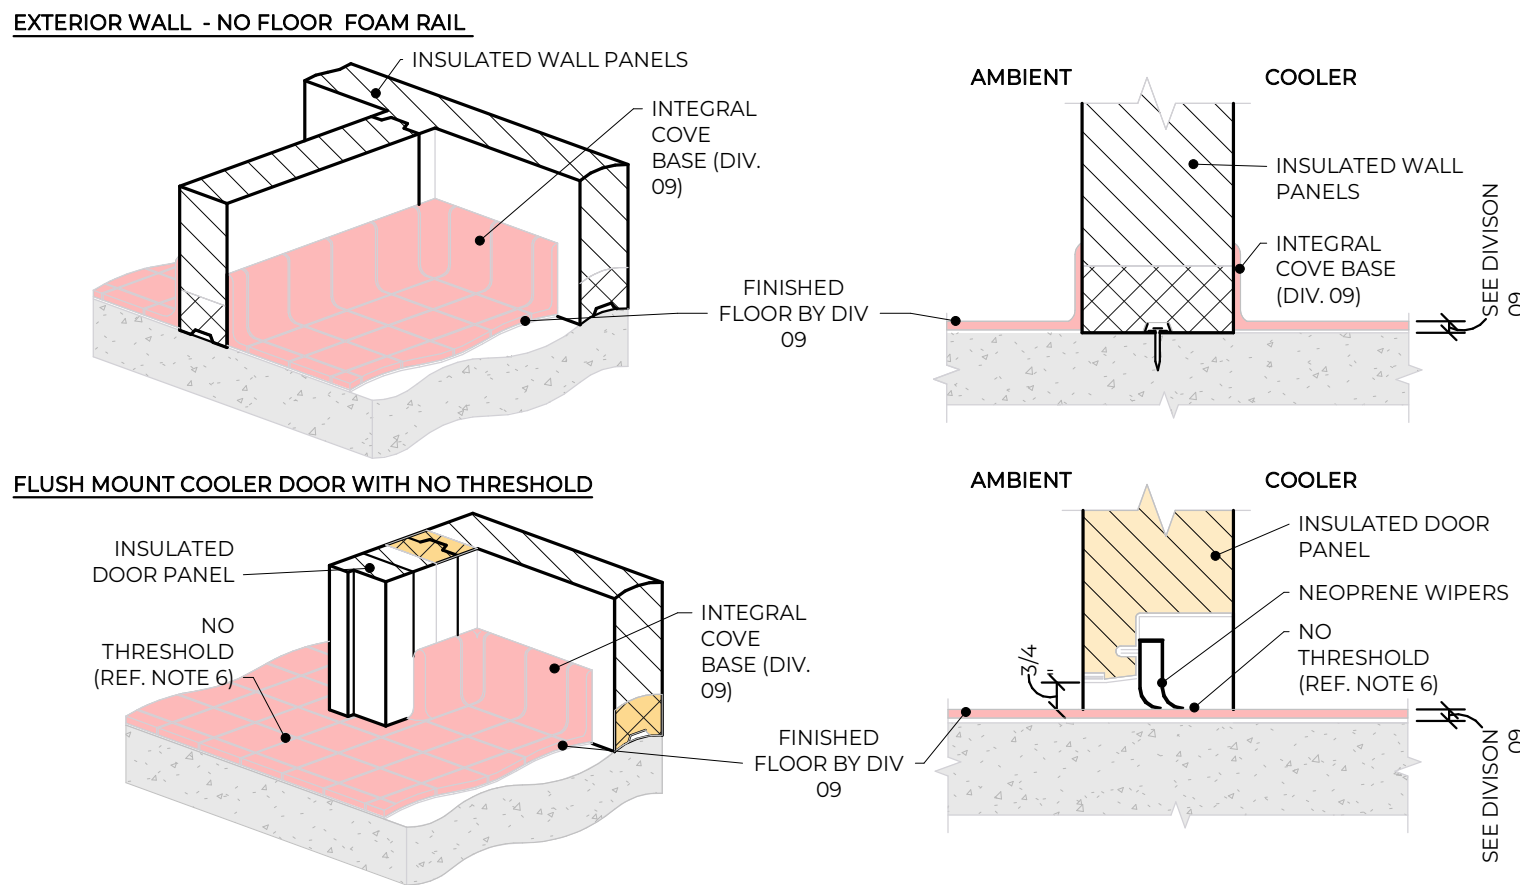

- NOTES:
1. THE FSEC SHALL PROVIDE CRITICAL HOLD-TO-DIMENSIONS IN THEIR COORDINATION DRAWING SUBMITTAL WITH AT LEAST 2" OF CLEARANCE FROM ADJACENT BUILDING WALLS ON ALL SIDES. THE FSEC SHALL VERIFY THESE CRITICAL DIMENSIONS IN THE FIELD PRIOR TO INSTALLATION.
 2. THE FSEC SHALL FURNISH AND INSTALL THE WALK-IN COOLER/FREEZER COMPLEX INCLUDING ALL INSULATED FLOOR PANELS PER SECTION 11 40.00. URETHANE SHALL BE UL APPROVED FOAMED-IN-PLACE AND BIND COMPLETELY TO THE METAL SKINS TO FORM A RIGID 4" THICK INSULATED PANEL WHEN COMPLETELY CURED.
 3. FINISHED FLOOR BY DIV. 09. THE FINISHED FLOOR SHALL BE CONTINUOUS THROUGH THE COLD STORAGE ROOM OPENINGS TO ENSURE A SMOOTH TRANSITION WITH NO THRESHOLD.
 4. THE FSEC SHALL ADJUST THE DOOR HEIGHTS AND GASKET SWEEPS TO ENSURE A FUNCTIONAL SEAL.

2 CD-07 - TYPE C - COOLER - COMMON WALL - NO FLOOR - DOOR WITH NO THRESHOLD
NTS



**American Legion
Post 290**

352 Main St.
New Town, ND 58763

STRUCTURAL

ICON ARCHITECTURAL GROUP
222 EAST MAIN STREET, SUITE B
MANDAN, ND 58554
(701) 751.0430 OFFICE

MECHANICAL

PRAIRIE ENGINEERING
1905 17TH ST SE
MINOT, ND 58701
(701) 852.6363 OFFICE

ELECTRICAL

PRAIRIE ENGINEERING
1905 17TH ST SE
MINOT, ND 58701
(701) 852.6363 OFFICE

CIVIL

MOORE ENGINEERING
1411 W DAKOTA PKWY SUITE 1B
WILLISTON, ND 58801
(701) 212.3937 OFFICE

FOODSERVICE

FOODSERVICE CONCEPT DESIGN
7900 INTERNATIONAL DRIVE
SUITE 300 -7043
BLOOMINGTON, MN 55425
(612) 325.1494 OFFICE



**BID
DOCUMENTS**

DRAWING HISTORY


NO.	DESCRIPTION	DATE
1	Construction Documents	08/12/26
2	Addendum 1	08/21/26

DRAWN BY: MJH JN: 23-018


**FOODSERVICE WALK-IN
DETAILS**

SHEET


QF801

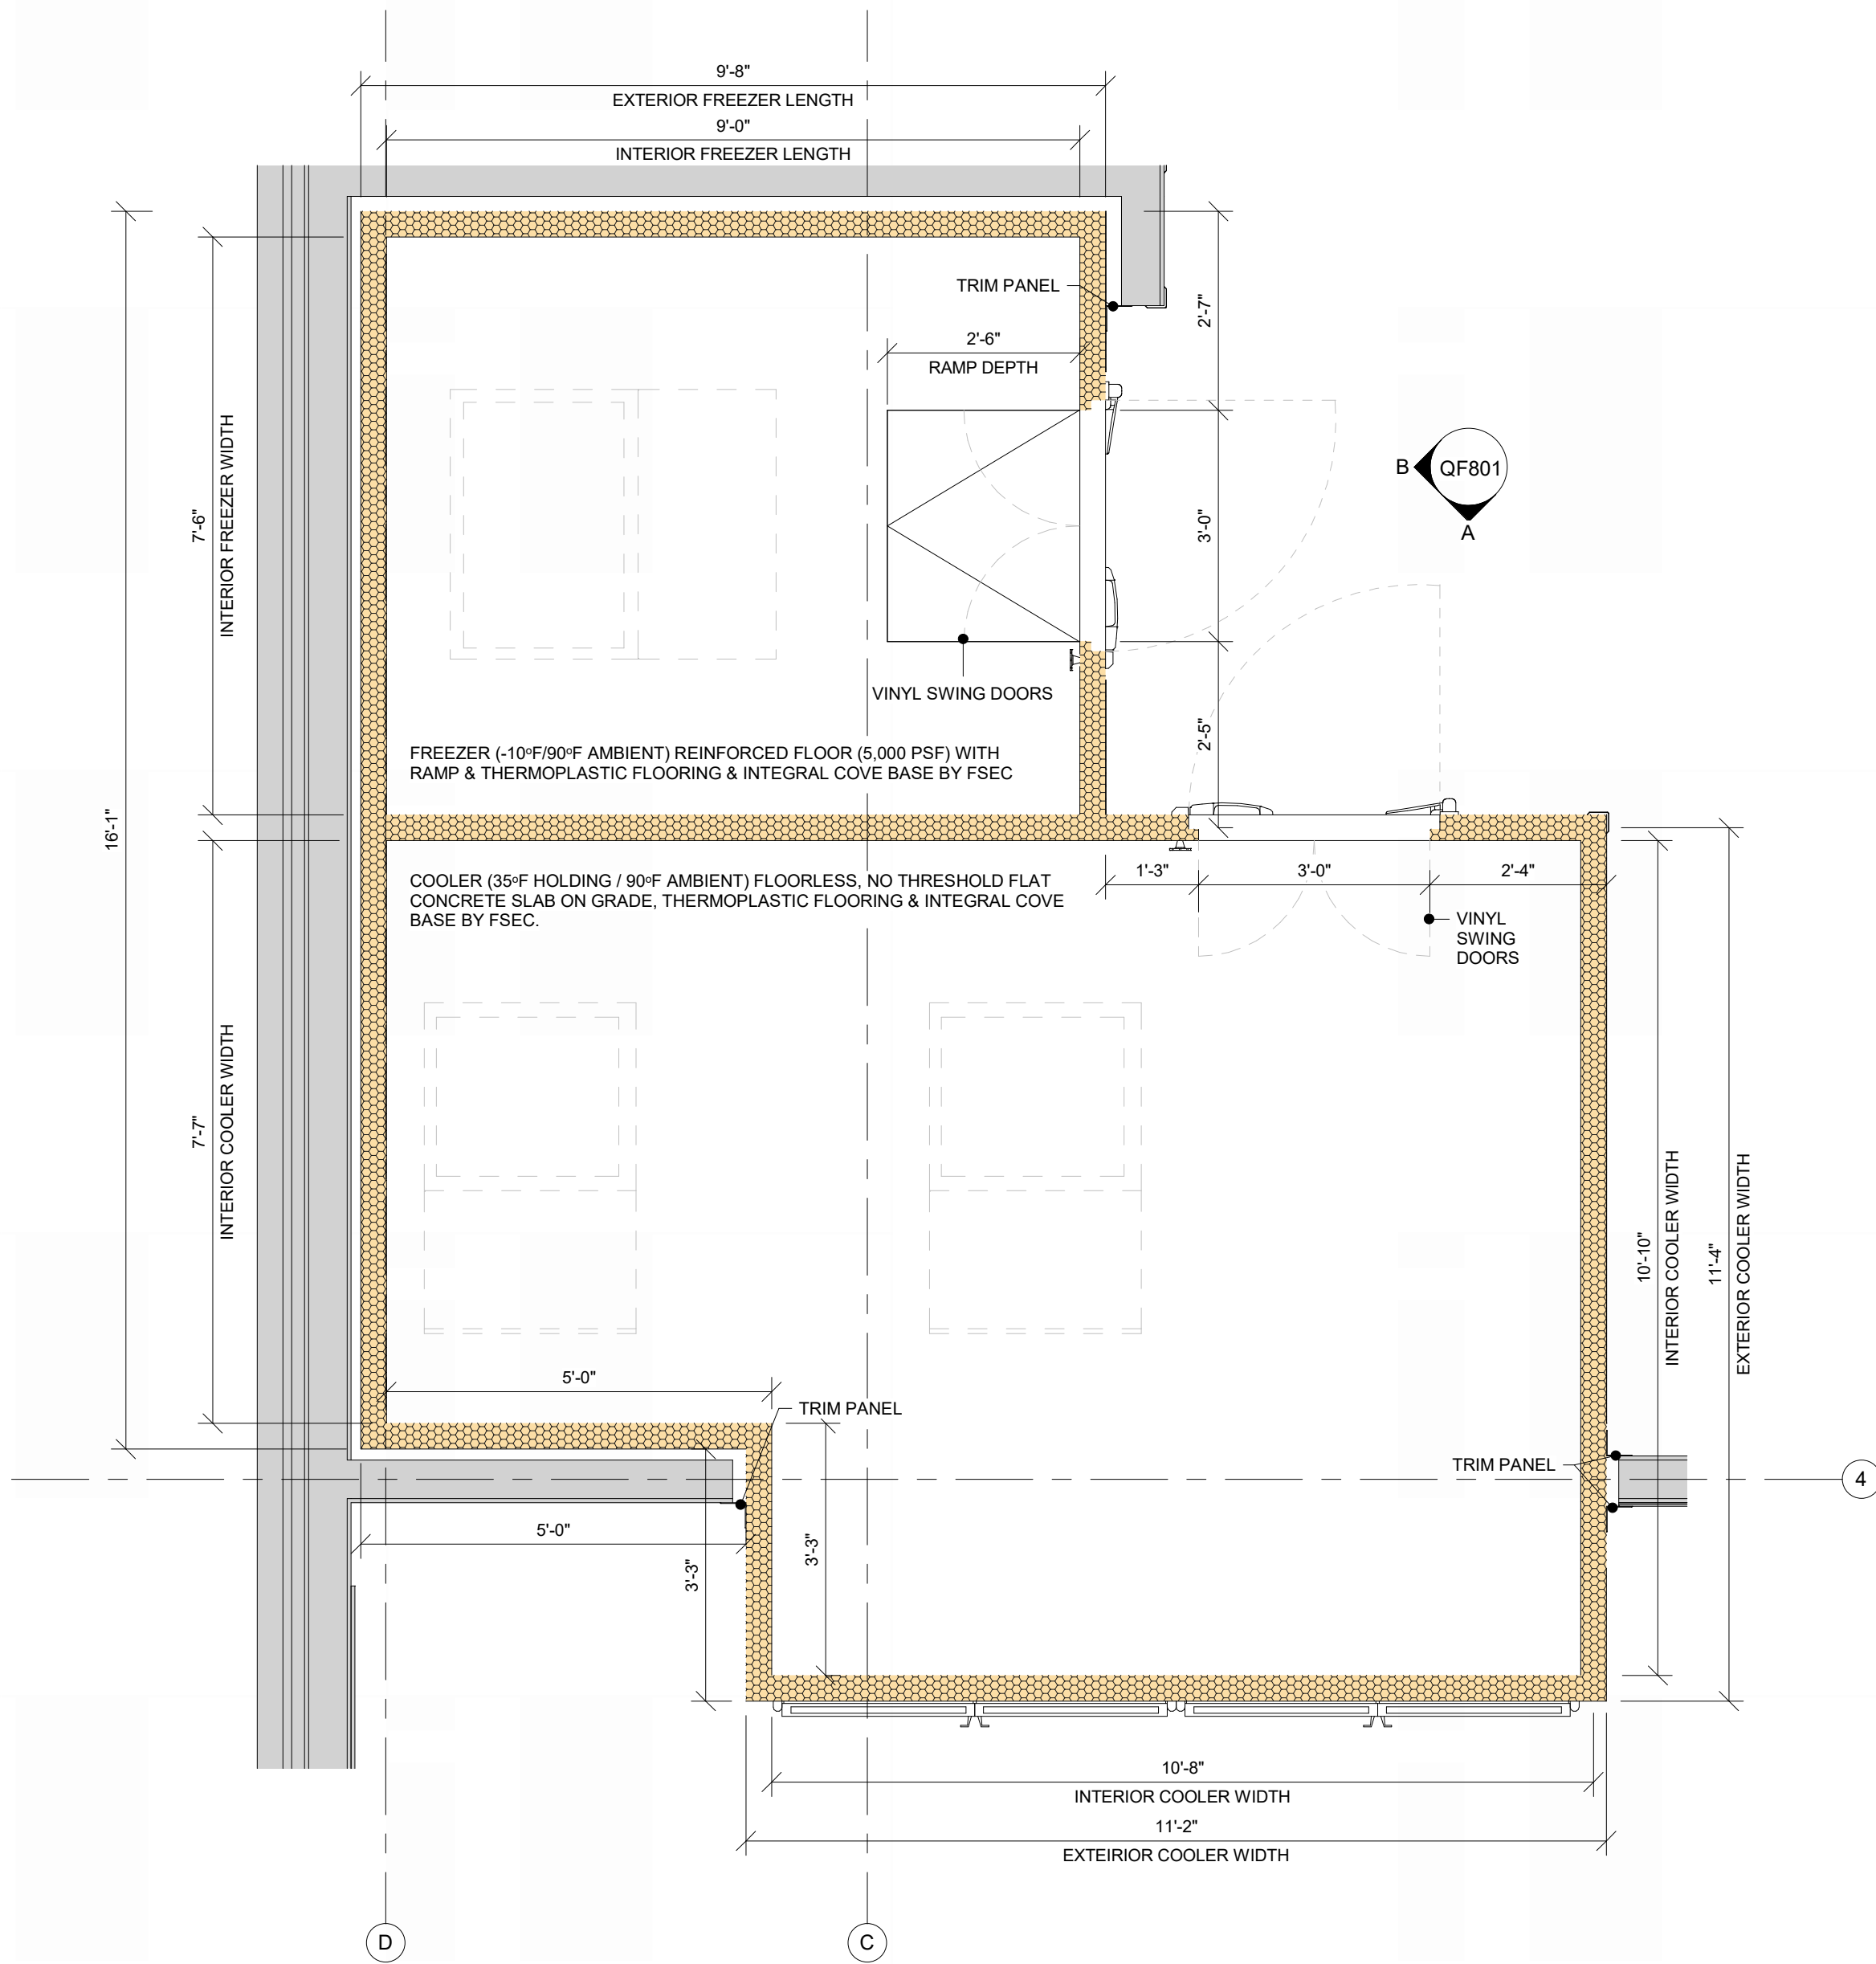

1 FOODSERVICE WALK-IN PLAN
1/2" = 1'-0"

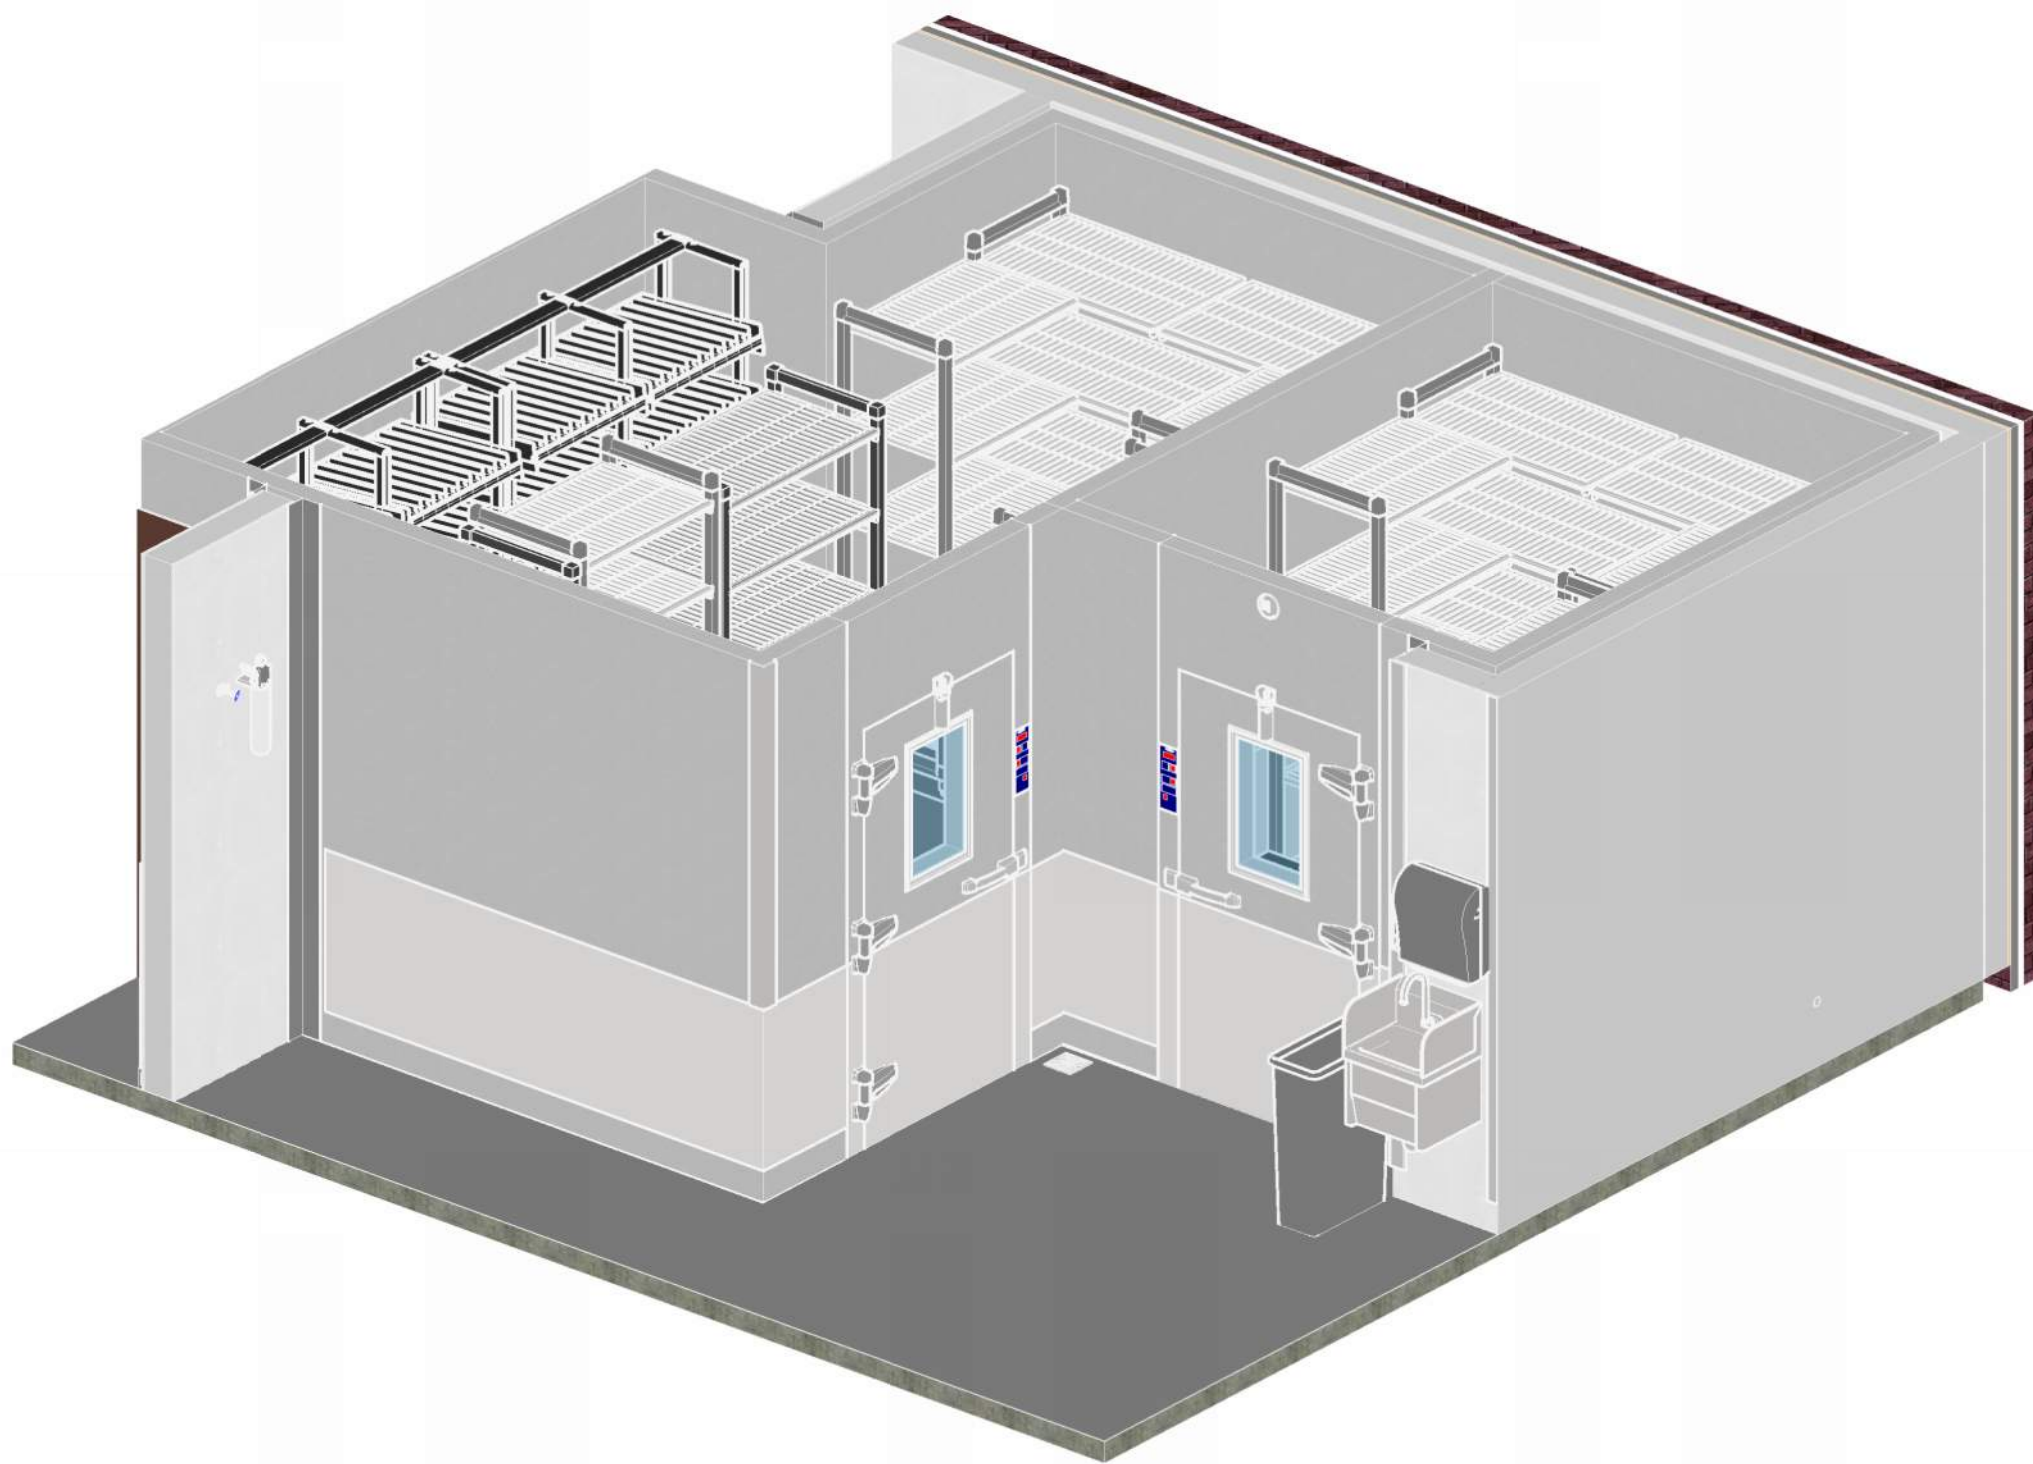


2 COLD STORAGE AXON VIEW
NTS

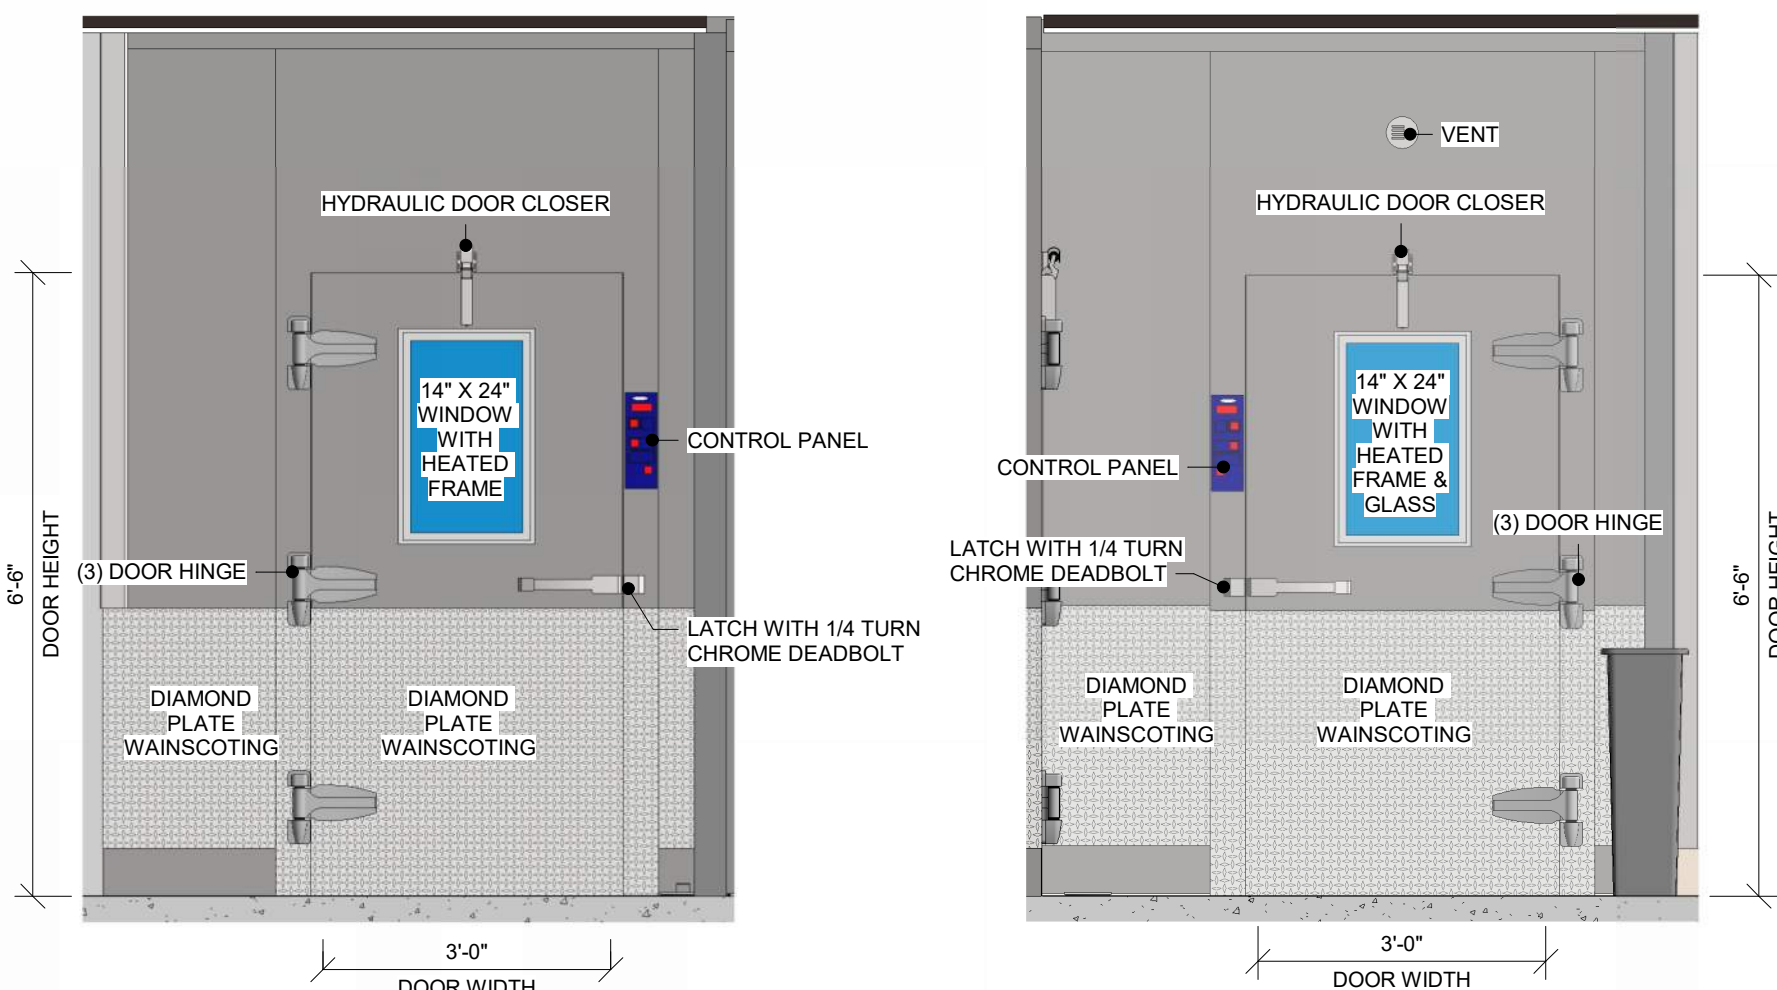

A COLD STORAGE - COOLER ELEVATION
1/2" = 1'-0"

B COLD STORAGE - FREEZER ELEVATION
1/2" = 1'-0"

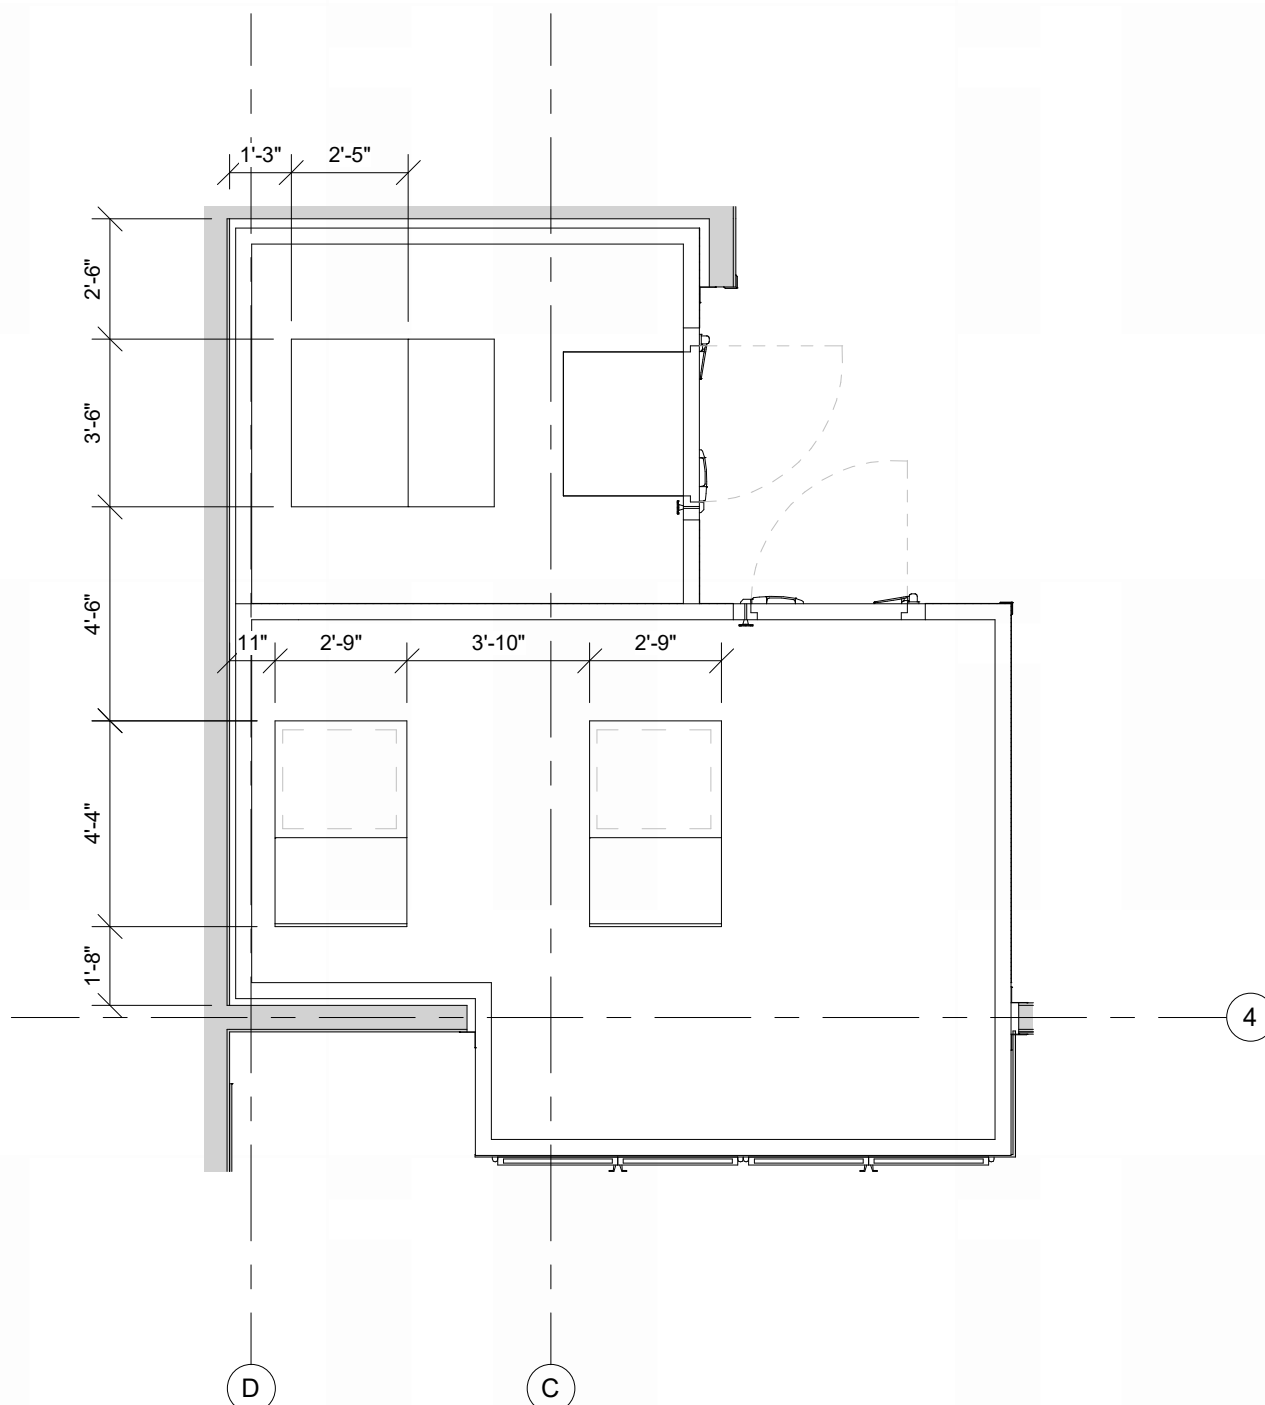


3 FOODSERVICE EQUIPMENT PLAN - T.O. WALK-IN
1/4" = 1'-0"

1
M200
1/8" = 1'-0"

FOUNDATION PLAN


4
M200
1/4" = 1'-0"

ENLARGED PLUMBING PLAN - EAST KITCHEN WALL

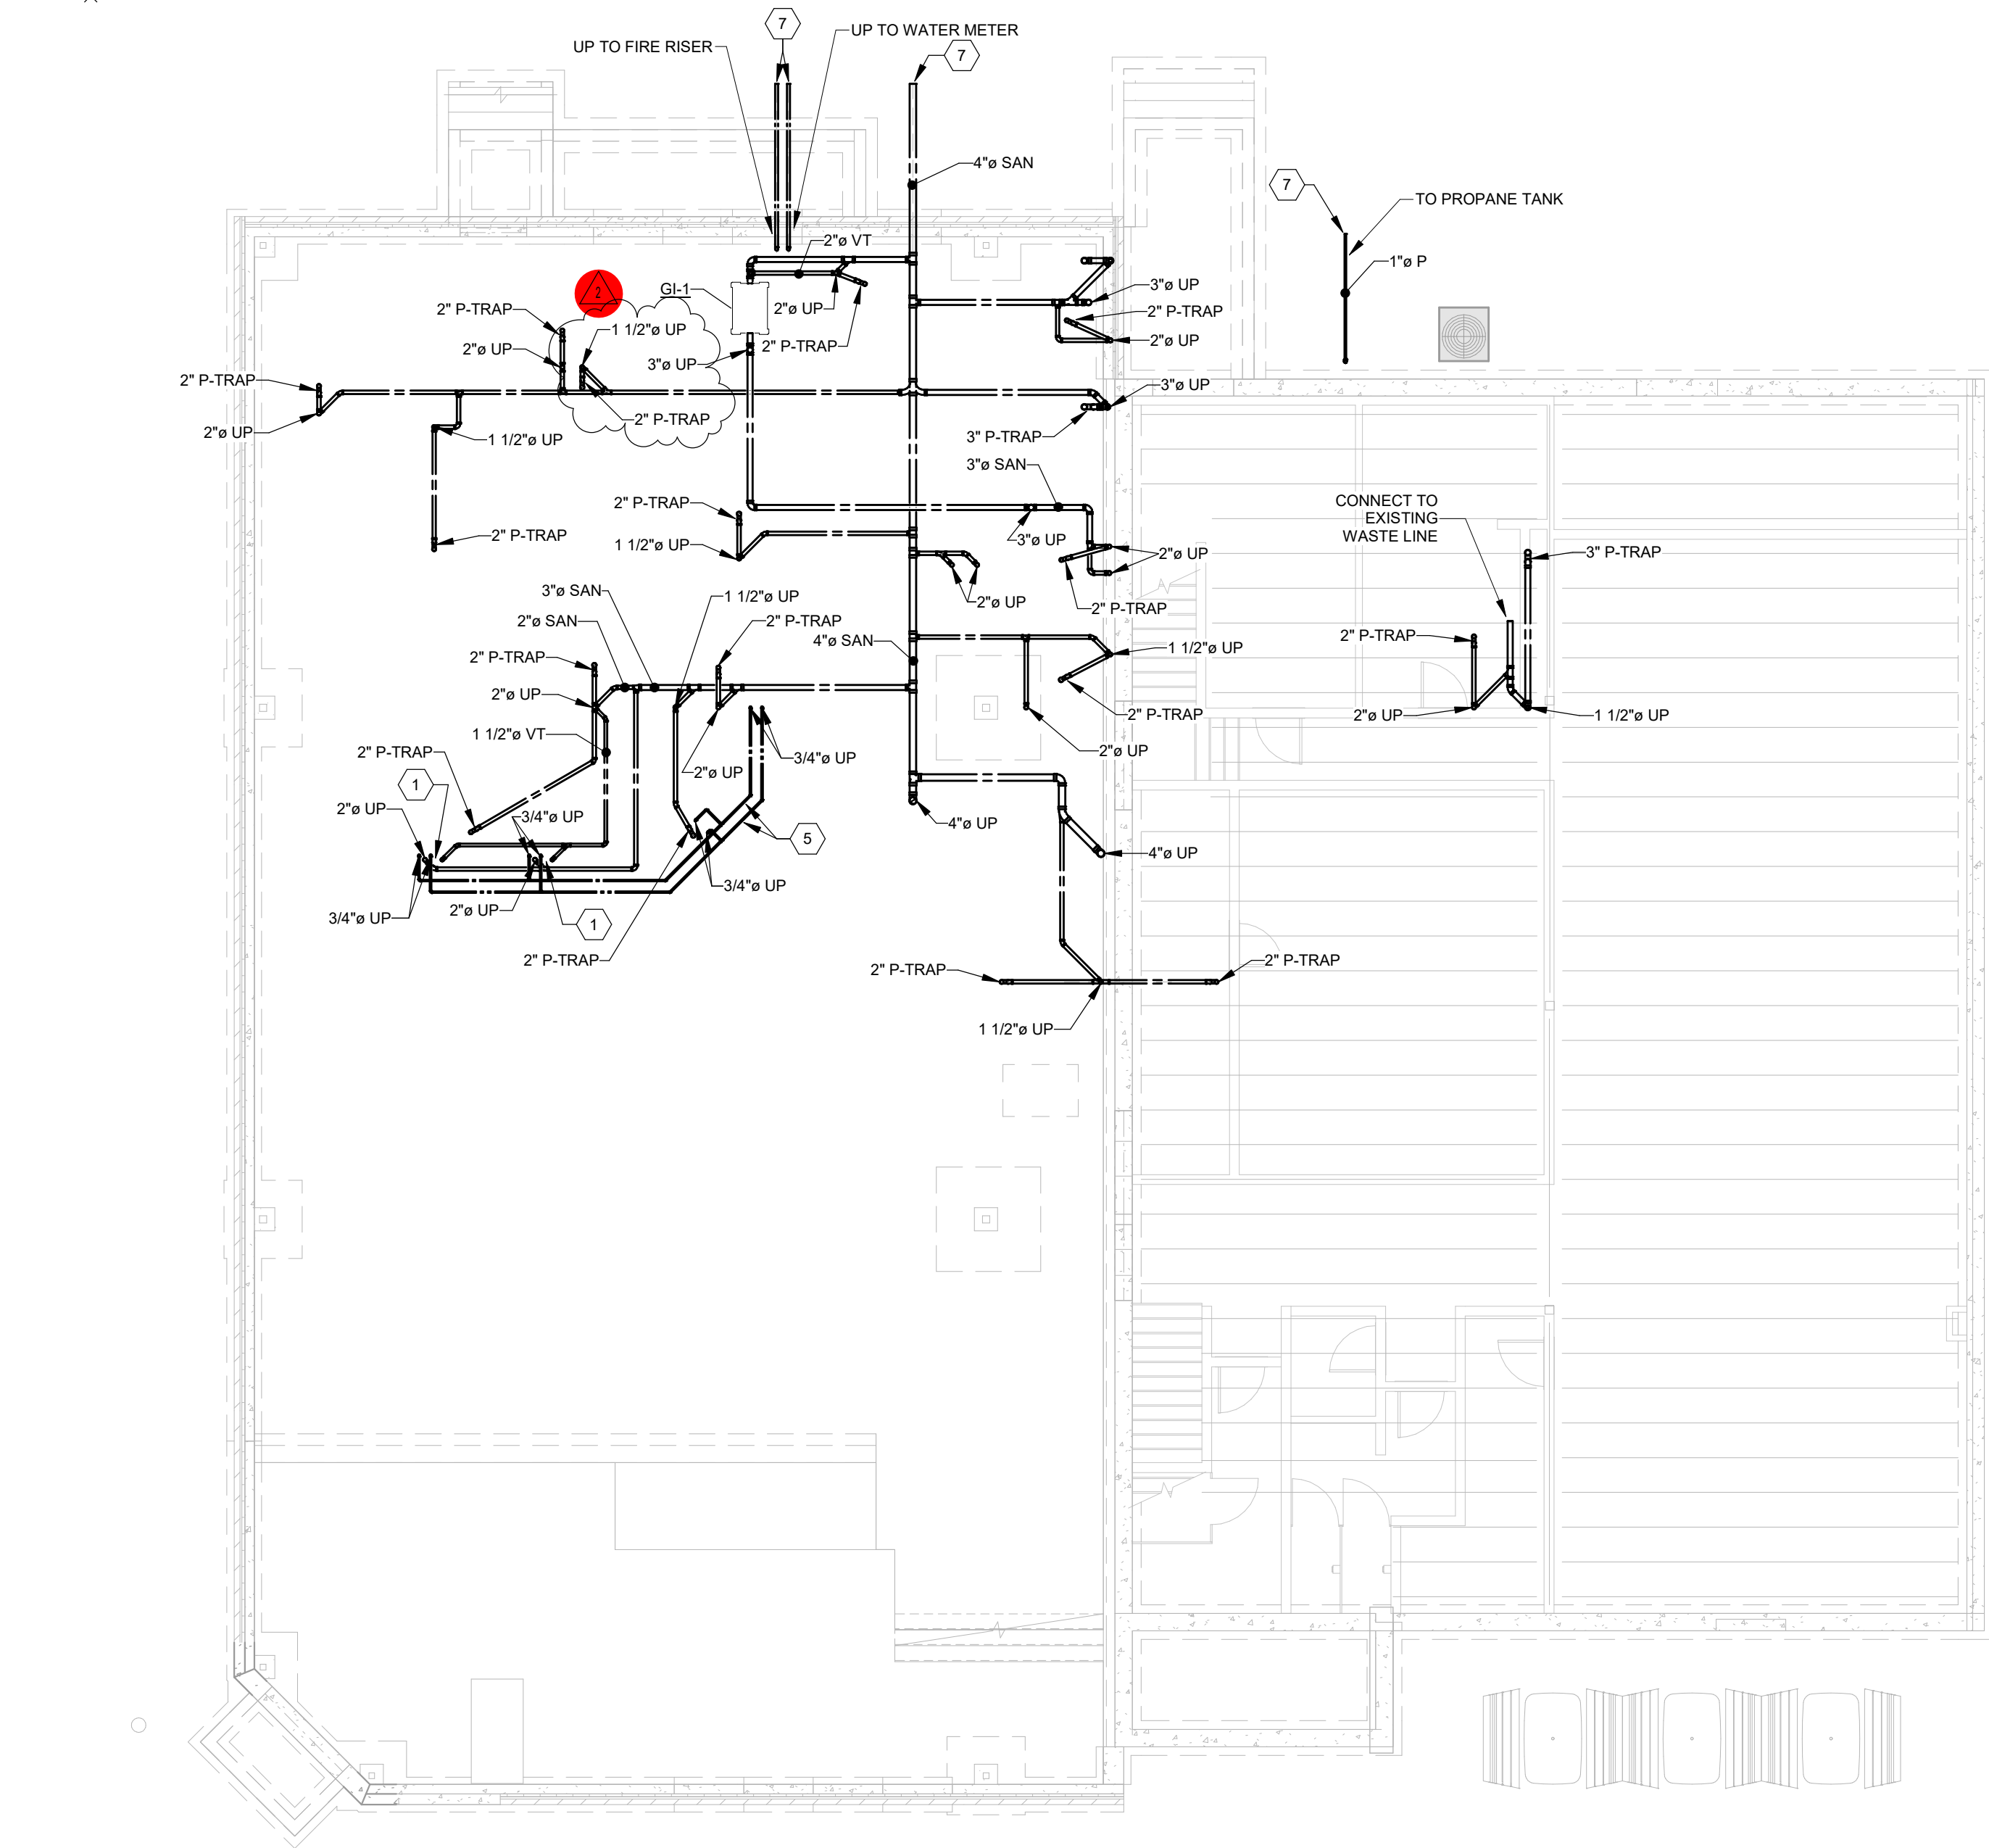


5
M200

TOILET RISER - DWV

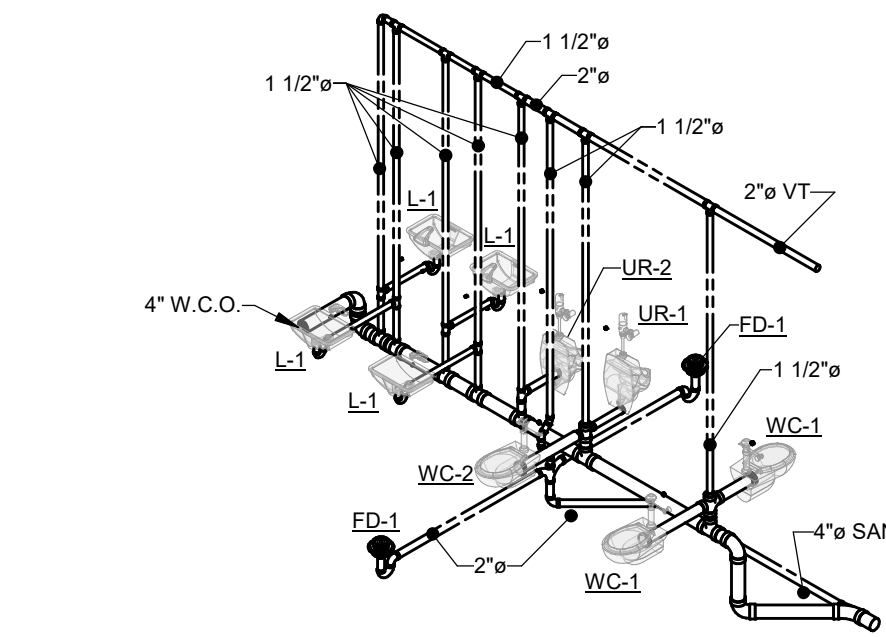

2
M200
1/8" = 1'-0"

PLUMBING PLAN

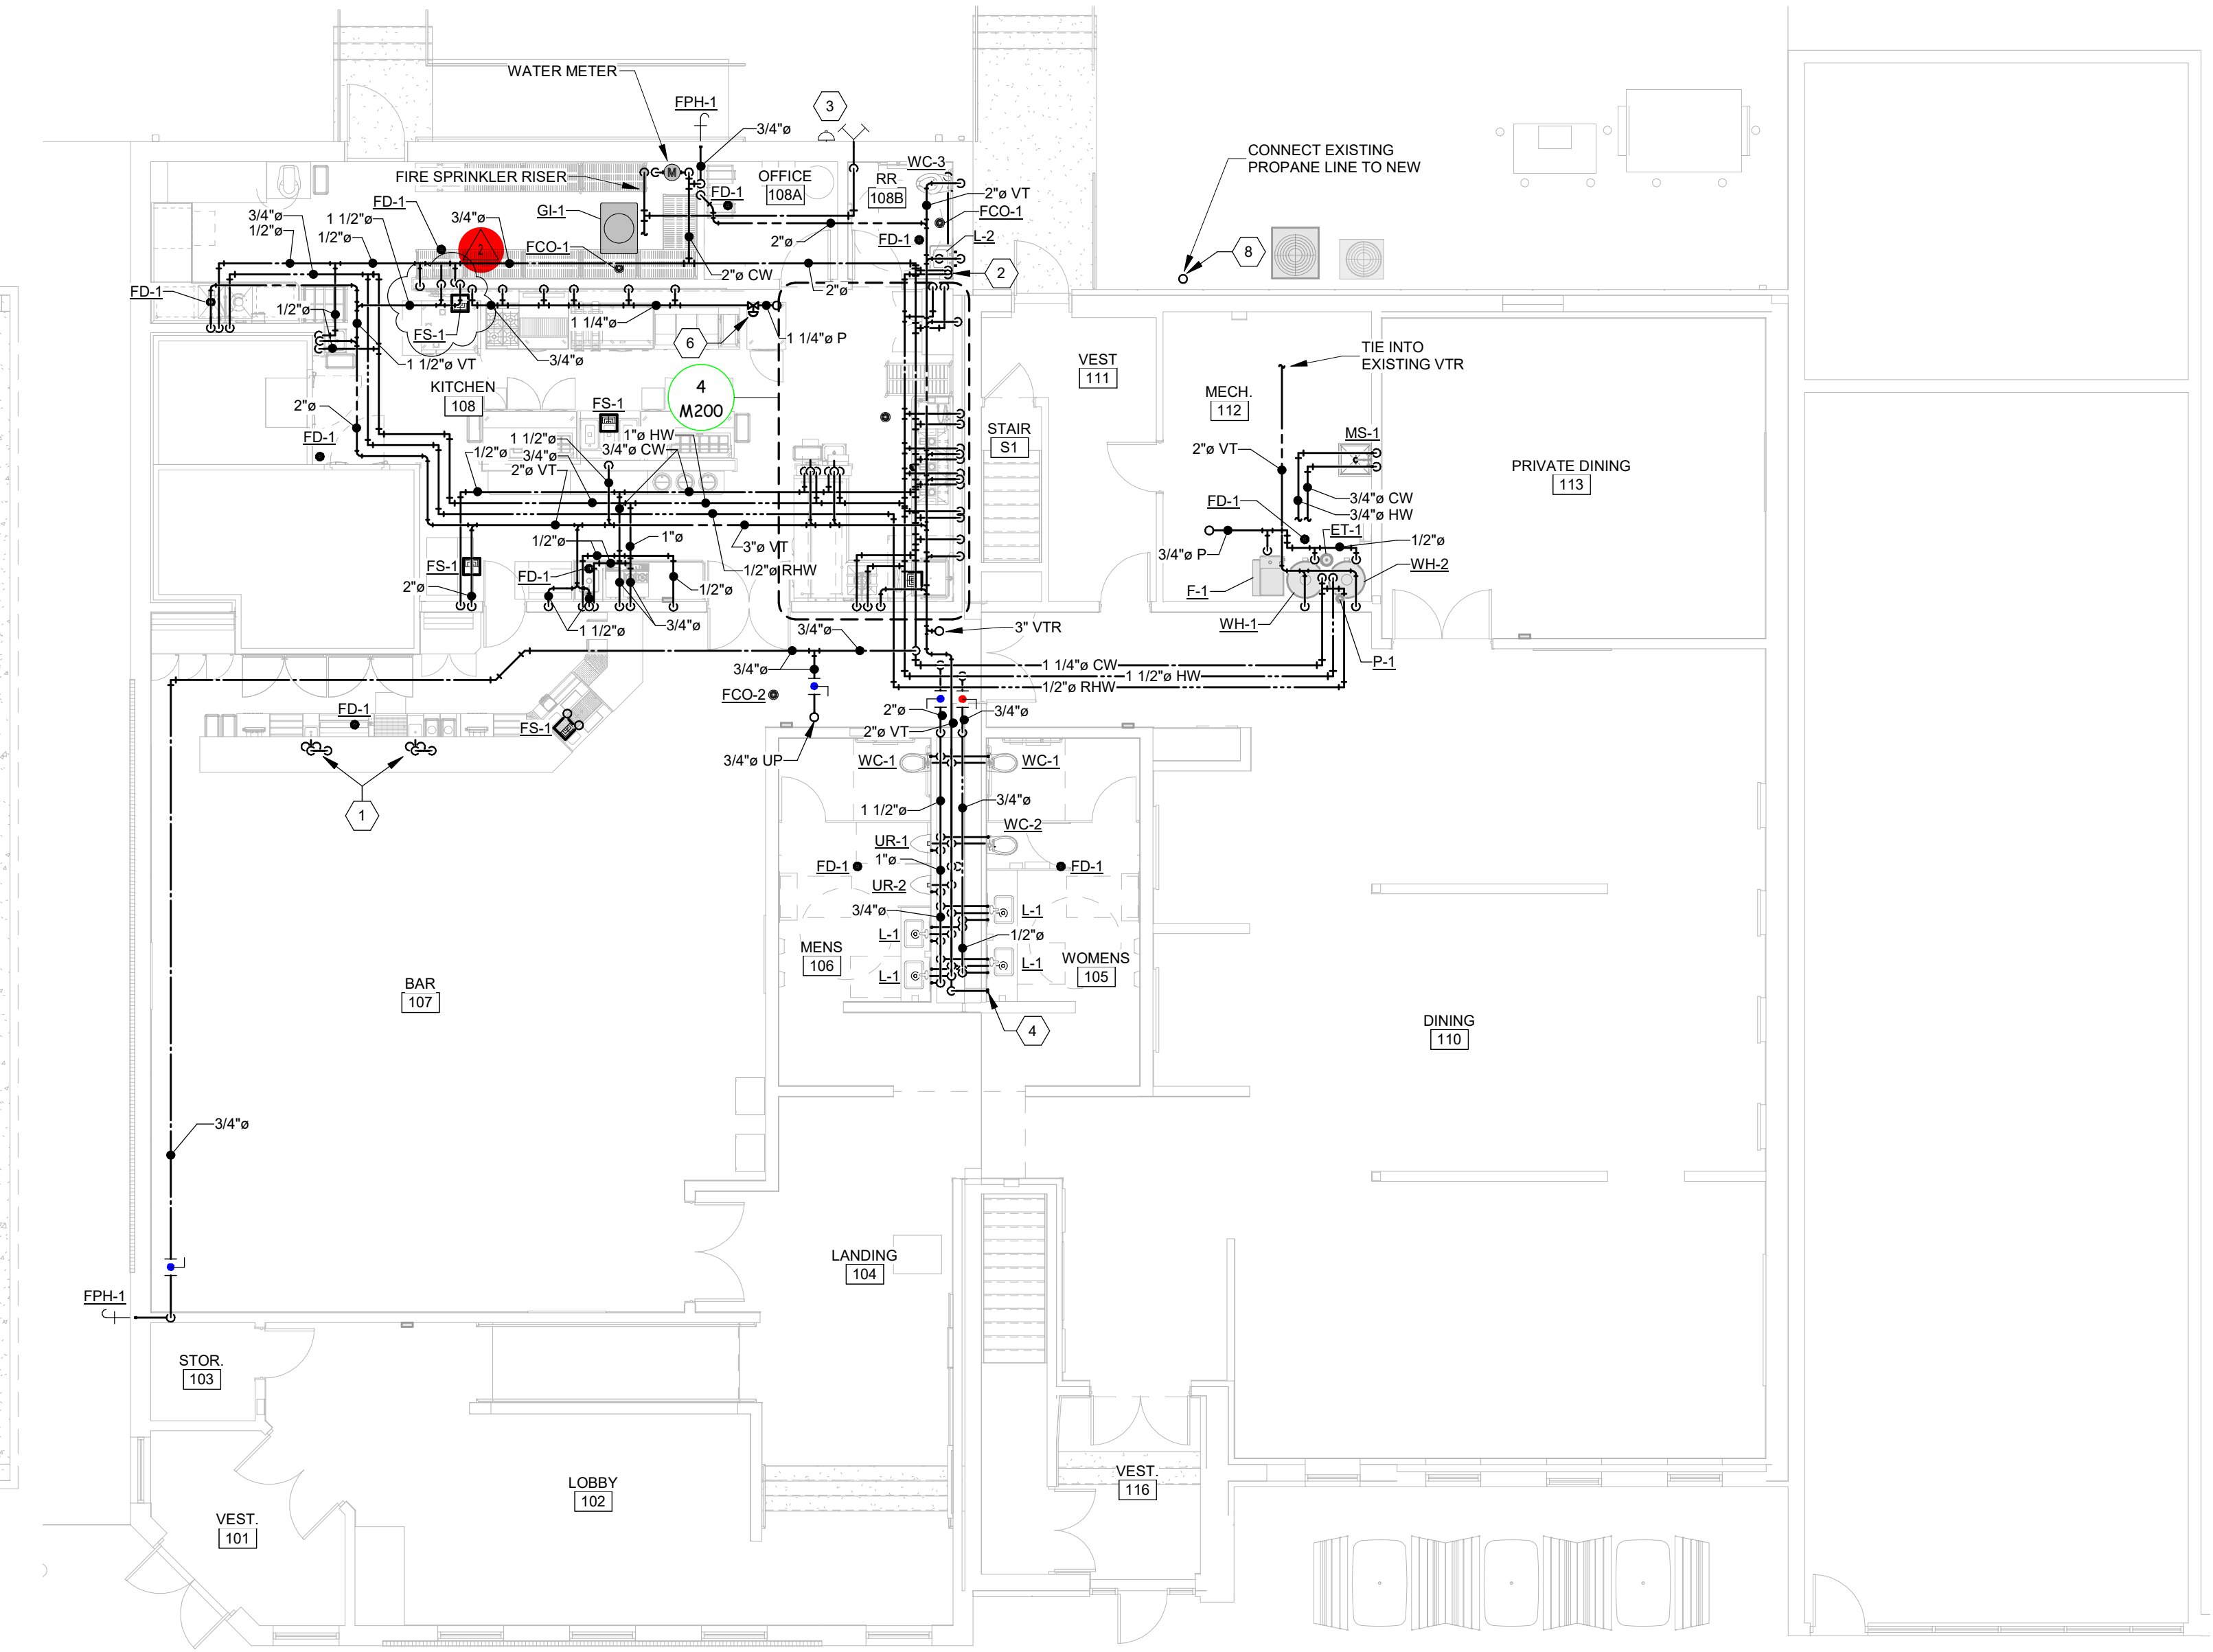

PLUMBING FIXTURE CONNECTIONS			
	WASTE	VENT	SUPPLY
WATER CLOSETS (FLUSH VALVE)	3"	2"	1"
URINALS	2"	1-1/2"	3/4"
LAVATORIES (SINGLE)	1-1/2"	1-1/2"	1/2"
SINKS	2"	1-1/2"	1/2"
SERVICE/MOP SINKS	3"	1-1/2"	3/4"
HOSE BIBBS/WALL FAUCETS	N/A	N/A	3/4"

LINE TYPE LEGEND	
	EXISTING
	NEW
	REMOVE
	HIDDEN
	MATCHLINE

KEYNOTE LEGEND	
1	SEE ISLAND WASTE VENTING DETAIL.
2	RUN 1" WATER COLD WATER AND 1/2" HOT WATER ALONG INTERIOR SIDE OF WALL DOWN TO LAVATORY AND WATER CLOSET.
3	PROVIDE FIRE DEPARTMENT CONNECTION AND AUDIO VISUAL ALARM.
4	4" WALL CLEANOUT BELOW COUNTER.
5	UNDERGROUND DOMESTIC WATER PIPING SHALL BE PEX.
6	MOTORIZED EMERGENCY GAS SHUT-OFF VALVE. INSTALL VALVE OUTSIDE OF KITCHEN HOOD.
7	M.C. TO CONNECT 5' OUTSIDE OF BUILDING - CONTINUATION BY OTHERS.
8	PROVIDE SECONDARY REGULATOR AND SHUT OFF VALVES.

PIPING VALVE & ACCESSORY LEGEND	
	BALL VALVE
	BALL VALVE
	BALL VALVE INDICATOR
	BUTTERFLY VALVE
	GATE VALVE
	VENTURI
	CHECK VALVE
	2-WAY HYDRONIC CONTROL VALVE
	2-WAY DOMESTIC CONTROL VALVE
	3-WAY CONTROL VALVE
	DRAIN VALVE
	STRAINER
	MANUAL AIR VENT
	AUTO AIR VENT
	TEMPERATURE GAUGE
	PRESSURE GAUGE
	SENSOR
	CIRCUIT SOLVER
	UNION

PIPING LEGEND	
	SANITARY WASTE
	SANITARY WASTE
	VENT
	DOMESTIC COLD WATER
	DOMESTIC COLD WATER
	DOMESTIC HOT WATER
	DOMESTIC HOT WATER
	RECIRC HOT WATER
	RECIRC HOT WATER
	CONDENSATE DRAIN
	PROPANE
	CONNECT TO EXISTING



American Legion
352 Main St.
New Town, ND 58763

STRUCTURAL

ICON ARCHITECTURAL GROUP
222 EAST MAIN STREET, SUITE B
MANDAN, ND 58554
(701) 751.0430 OFFICE

MECHANICAL

PRAIRIE ENGINEERING
1905 17TH ST SE
MINOT, ND 58701
(701) 852.6363 OFFICE

ELECTRICAL

PRAIRIE ENGINEERING
1905 17TH ST SE
MINOT, ND 58701
(701) 852.6363 OFFICE

CIVIL

MOORE ENGINEERING
1411 W DAKOTA PKWY SUITE 1B
WILLISTON, ND 58801
(701) 212.3937 OFFICE

FOODSERVICE

FOODSERVICE CONCEPT DESIGN
7900 INTERNATIONAL DRIVE
SUITE 300 -7043
BLOOMINGTON, MN 55425
(612) 325.1494 OFFICE



**BID
DOCUMENTS**

DRAWING HISTORY

NO.	DESCRIPTION	DATE
1	Construction Documents	08/12/26
2	Addendum 1	08/21/26

DRAWN BY: JWB


JN: 25062

PLUMBING PLANS

Prairie
Engineering P.C.
Professional Consulting Engineers
1905 17th Street SE
Minot, ND 58701
tel. 701.852.6363

SHEET

M200

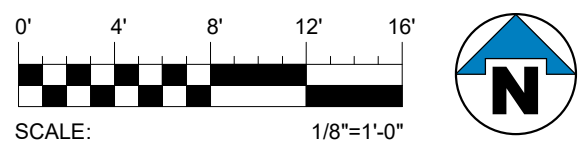



**American Legion -
New Town, ND**

352 Main St.
New Town, ND 58763

STRUCTURAL

ICON ARCHITECTURAL GROUP
222 EAST MAIN STREET, SUITE B
MANDAN, ND 58554
(701) 751.0430 OFFICE

MECHANICAL

PRAIRIE ENGINEERING
1905 17TH ST SE
MINOT, ND 58701
(701) 852.6363 OFFICE

ELECTRICAL

PRAIRIE ENGINEERING
1905 17TH ST SE
MINOT, ND 58701
(701) 852.6363 OFFICE

CIVIL

MOORE ENGINEERING
1411 W DAKOTA PKWY SUITE 1B
WILLISTON, ND 58801
(701) 212.9397 OFFICE

FOODSERVICE

FOODSERVICE CONCEPT DESIGN
7900 INTERNATIONAL DRIVE
SUITE 300 -7043
BLOOMINGTON, MN 55425
(612) 325.1494 OFFICE

STANDARD ELECTRICAL SYMBOLS

BASED ON ANSI Y32.3-1972, ANSI A117.1-1986, AND FEDERAL REGISTER 36-144 (ADA)
MOUNTING HEIGHT MEASUREMENTS SHALL BE MADE FROM FINISH
FLOOR TO CENTER LINE OF OUTLET

SYMBOL	DESCRIPTION	MTG. HT.	
LIGHTING OUTLETS			
	CEILING LUMINAIRE, TYPE A, CKT 1, SW 1	SCHEDULED	
	WALL MOUNTED LUMINAIRE		
	TROFFER LUMINAIRE, SLASH INDICATES UNSWITCHED		
	STRIP LUMINAIRE WITH WIRE GUARD		
PLN		CEILING MOUNTED EXIT SIGN, SHADING INDICATES LIGHTED FACE	SCHEDULED
		WALL MOUNTED EXIT SIGN	
		EMERGENCY BATTERY UNIT	
		REMOTE SEALED BEAM	
		PORCELAIN LAMPHOLDER, 100A LAMP LED LAMP EQUIVALENT	SCHEDULED
	JUNCTION BOX		
RECEPTACLE OUTLETS			
	SINGLE, CKT 1	18"	
	DUPLEX	18"	
	DUPLEX - SPLIT WIRED	18"	
	DUPLEX - GROUND FAULT CIRCUIT INTERRUPTER	18"	
	DUPLEX - EMERGENCY	18"	
	DOUBLE DUPLEX	SCHEDULED	
	SPECIAL CONFIGURATION, DESIGNATION REFERS TO SCHEDULE		
	MULTI-OUTLET ASSEMBLY, ARROWS EXTEND TO LIMIT OF INSTALLATION, SUBSCRIPT INDICATES SPACING OF OUTLETS		
	CLOCK RECEPTACLE	82"	
	DUPLEX RECEPTACLE - FLOOR BOX		
SWITCH OUTLETS			
	SINGLE POLE	46"	
	DOUBLE POLE	46"	
	THREE-WAY	46"	
	FOUR-WAY	46"	
	KEY OPERATED		
	MOTOR - PROVIDE OVERLOAD UNIT AS REQ'D, TOGGLE ACCEPTABLE IF INTERNAL THERMAL PROTECTION INCLUDED, SWITCH NOT REQ'D IF MOTOR ASSEMBLY HAS INTEGRAL DISCONNECTING MEANS		
	PILOT HANDLE	46"	
	TIME DELAY	46"	
	DIMMER - 1000W UNLESS OTHERWISE INDICATED	46"	
	GANGED SWITCHES - ARROW INDICATES MULTI-LEVEL SWITCHING	46"	
	WALL MOUNTED OCCUPANCY SENSOR		
	CEILING MOUNTED OCCUPANCY SENSOR, TYPE A, SW 1, REFER TO SCHEDULE FOR TYPE		
COMMUNICATION/DATA SYSTEM OUTLETS			
	VOICE OUTLET - ONE JACK PER TRIANGLE	18"	
	VOICE OUTLET OR DATA OUTLET - FLOOR BOX		
	DATA OUTLET - ONE JACK PER TRIANGLE	18"	
	DATA OUTLET - ROUGH-IN ONLY WITH BLANK PLATE	18"	
	BELL		
	BUZZER		
	INTERCOM STATION	46"	
	MICROPHONE OUTLET	18"	
	TELEVISION OUTLET	18"	
	VOLUME CONTROL	46"	
	PUSH BUTTON		
	SPEAKER/Baffle/BACKBOX COMBINATION	CEILING	
	CLOCK	84"	
	AUDIO/VIDEO CONNECTION BOX - HDMI TYPICAL		
MISCELLANEOUS			
	PLAN OR DETAIL NOTE		
	SPECIAL PURPOSE CONNECTION - AS REQUIRED BY EQUIPMENT MANUFACTURER, CO-ORDINATE ROUGH-IN WITH SHOP DWG	TOP 75"	
	BRANCH CIRCUIT PANELBOARD, SHADING INDICATES NEW PANEL		
	CONTROL PANEL		
	EXTERNALLY OPERATED DISCONNECT SWITCH		
	CONTROLLER OR RELAY		
	COMBINATION CONTROLLER AND DISCONNECTION MEANS		
	MOTOR, DESIGNATION REFERS TO SCHEDULE		
	EQUIPMENT DESIGNATION, SEE SCHEDULE		
	ELECTRIC HEAT TO SCALE, DESIGNATION REFERS TO SCHEDULE, "T" INDICATES INTEGRAL THERMOSTAT		
	THERMOSTAT-PROVIDED BY DIV. 26	46"	
	THERMOSTAT-FURNISHED BY DIV. 23, INSTALLED BY DIV. 26	46"	
	HUMIDISTAT-FURNISHED BY DIV. 23, INSTALLED BY DIV. 26	46"	
	POTENTIOMETER-FURNISHED BY DIV. 23, INSTALLED BY DIV. 26	46"	
	TIME SWITCH		
	PHOTOELECTRIC SWITCH		
CIRCUITING			
	HOME RUN, MIN 3/4" C, ARROWS AND SUBSCRIPTS INDICATE NUMBER AND IDENTIFICATION OF CIRCUITS		
	CONTROL WIRE, SEE SPECIFICATION SECTION 260536		
	EMERGENCY, MIN 1/2" C #10 AWG		
	TELEPHONE, MIN 3/4" C, HOME RUN TO TERMINAL BOARD		
	TELEPHONE, MIN 3/4" C, STUB INTO CEILING SPACE		
	LOW VOLTAGE, MIN 1/2" C #14 AWG AS REQ'D		
	SPECIAL SYSTEMS, MIN 3/4" C, PROVIDE CONDUCTORS AS REQ'D BY MANUFACTURER, SUBSCRIPT INDICATES SYSTEM, SEE STANDARD ABBREVIATIONS		
FIRE ALARM SYSTEMS			
	DETECTOR, SUBSCRIPT DESCRIBES TYPE: D-DUCT, H-HEAT, P-PHOTOELECTRIC, C-CARBON-MONOXIDE	CEILING	
	CHIME	88"	
	MAGNETIC DOOR HOLDER		
	ADDRESSABLE INPUT MODULE		
	ADDRESSABLE RELAY MODULE		
	FLOW SWITCH		
	MANUAL STATION	46"	
	AUDIBLE ALARM NOTIFICATION APPLIANCE (HORN)	88"	
	VISUAL ALARM NOTIFICATION APPLIANCE	88"	
	COMBO AUDIBLE-VISUAL ALARM NOTIFICATION APPLIANCE	88"	
	MAIN VALVE SUPERVISORY ("TAMPER") SWITCH		
SECURITY AND SURVEILLANCE SYSTEMS			
	ELECTRIC DOOR CONTROL		
	DOOR POSITION SENSOR		
	PROXIMITY CARD READER	46"	
	DOOR CONTROL PANEL		
	POWER SUPPLY		
	LOCKDOWN BUTTON		
	INTERCOM/DOOR CONTROL		
	SECURITY CAMERA - SEE SPECIFICATION SECTION 282000 FOR TYPE		

STANDARD ABBREVIATIONS

AC	ABOVE COUNTER (MIN 4" ABOVE BACKSPLASH)	LV	LOW VOLTAGE
AFF	ABOVE FINISHED FLOOR	MC	MECHANICAL CONTRACTOR
AFG	ABOVE FINISHED GRADE	MCA	MINIMUM CIRCUIT AMPACITY
ATC	AUTOMATIC TEMPERATURE CONTROL	MCB	MAIN CIRCUIT BREAKER
BOF	BOTTOM OF FIXTURE	MLO	MAIN LUG ONLY
CKT	CIRCUIT	NC	NURSE CALL
DTR	DUST TIGHT	NFDS	NON-FUSIBLE DISCONNECT SWITCH
DTR	DATA RACK	NR	NOT REQUIRED
EC	ELECTRICAL CONTRACTOR	PA	PUBLIC ADDRESS
EGC	EQUIPMENT GROUNDING CONDUCTOR	RGSC	RIGID GALVANIZED STEEL CONDUIT
EM	EMERGENCY	RT	RAIN-TIGHT
EP	EXPLOSION PROOF	S	SECURITY
EW	ELECTRIC WATER COOLER	SD	SEE DETAIL
EW	ELECTRIC WATER HEATER	SS	SURGE SUPPRESSION
F	FUSED	SW	SWITCH
FA	FIRE ALARM	T	TELEPHONE
FACP	FIRE ALARM CONTROL PANEL	TOP	TOP OF PANEL
FABA	FIRE ALARM REMOTE ANNUNCIATOR	TSSW	TWO SPEED SEPERATE WINDING
FDS	FUSIBLE DISCONNECT SWITCH	TTB	TELEPHONE TERMINAL BOARD
FLA	FULL LOAD AMPERES	U	USB COMBINATION RECEPTACLE
FVNR	FULL VOLTAGE NON REVERSING	VFD	VARIABLE FREQUENCY DRIVE
FVR	FULL VOLTAGE REVERSING	VT	VAPOR TIGHT
GRA	GENERATOR REMOTE ANNUNCIATOR	W	WALL MTG (46" AFF)
IC	INTERCOM	WP	WIRELESS ACCESS POINT
IG	ISOLATED GROUND	WT	WEATHERPROOF
IL	INTERLOCK	WM	WATER TIGHT
		WM	WIREMOLD

SPECIAL SYMBOLS PECULIAR TO THIS PROJECT

SPECIAL ABBREVIATIONS PECULIAR TO THIS PROJECT

LIGHTING SWIICH SCHEDULE

BASED ON nLight AIR PART NUMBERS (OR EQUAL SYSTEM BY WAVELENGTH)		
SYMBOL	DESCRIPTION	PART #
	LINE POWERED WALL SWITCH, ON/OFF, RAISE/LOWER DIMMING CONTROL	RPODLA-DX
	LINE POWERED WALL SWITCH, ON/OFF	RPODLA
	LINE POWERED ELY DIMMER	DV ELY-300P-XX
	WALL MOUNTED OCCUPANCY SENSOR - SEE SPECIFICATION SECTION 262726	
	WALL MOUNTED OCCUPANCY SENSOR (TYPE D) WITH DIMMING CONTROL - SEE SPECIFICATION SECTION 262726	
	CEILING MOUNTED OCCUPANCY SENSOR - SEE SPECIFICATION SECTION 262726	

FIXTURE SCHEDULE

TYPE	MANUFACTURER	CATALOG NO.	DELIVERED LUMENS	FINISH	MOUNTING	REMARKS
A2	METALUX MARK ARCHITECTURAL	22RLN LD5 44UNV L840 CD 1 WPS WHSPK SERIES	4,400	WHITE	SD 4/E100	2' X 2' LED TROFFER WITH WIRELESS CONTROLLED DIMMING, OCCUPANCY SENSOR, AND PHOTOCCELL. 4000K
B1	METALUX	24CGTX 55 L840 WPS	5,500	WHITE	SD 4/E100	2' X 4' LED FLAT PANEL WITH DIMMING. 4000K
B2	LITHONIA METALUX	CPX SERIES 22CGTX 55 L840 WPS	3,500	WHITE	SD 4/E100	2' X 2' LED FLAT PANEL WITH DIMMING. 4000K
D2	LITHONIA FAIL SAFE LUMINAIRE LED	CPX SERIES HVSL4 2 LD4 1HJ 40 UNV O EDD1 BK 2E/2M/BK SPC4 SERIES	2,000	VERIFY WITH ARCHITECT	WALL MOUNTED CENTERED ABOVE MIRROR	2' LED WALL BRACKET WITH OPAL LENS, AND VERTICAL TRIM BARS. 4000K
D4	FAIL SAFE LUMINAIRE LED	HVSL4 SERIES SPC4 SERIES	4,000			SAME AS TYPE D2 EXCEPT 4 FOOT.
E1	ISOLITE EVENLITE	DTH2-U-BA-MTEB AUR-U-BA-CN	INTEGRAL LEDS	ALL BRUSHED ALUMINUM	NOTE 1	PHOTOLUMINESCENT UNIVERSAL FACE UNIVERSAL MOUNT LED EXIT WITH GREEN LETTERS, AND DIE CAST ALUMINUM HOUSING
E2	ISOLITE EVENLITE	TSR-HO-W-SD TEBL6W-SD	2 LED HEADS	WHITE	WALL HIGH AS POSSIBLE	DECORATIVE EMERGENCY LED FIXTURE WITH SELF-DIAGNOSTICS.
F1	METALUX LITHONIA	4SNX67SL-LN-UNV-L840- CD1 ZL1D SERIES	7,000	WHITE	SURFACE CEILING OR CHAIN HUNG TO ADVOID MECHANICAL EQUIPMENT	4' LED STRIP LIGHT. 4000K
G1	HALO COMMERCIAL LITHONIA	HC6 D010 WPN HM6 3040 830 61 WD H LDN6 SERIES	3,000	SEMI-SPECULAR SILVER	RECESSED CEILING	6" LED DOWNLIGHT WITH WIRELESS CONTROLS. 3000K.
K1	MCGRAW-EDISON	GKO PB2B 740 U T4W BZ	5,000	BLACK	WALL MOUNT SEE PLANS FOR HEIGHT	WEDGE SHAPE ARCHITECTURAL LED WALL PACK. 4000K. SD 5/E100.
K2	LITHONIA	WDGE3 P0 40K RFT MVOLT				
K2	BARNLIGHT	BLE-G-ASF12-700-G15-700-NA -NA-NA-NA-LED27-4000K-DL AS12 SERIES	2,000	ROYAL BLUE	WALL MOUNT SEE PLANS FOR HEIGHT	LED RLM ON GOOSENECK MOUNT. 4000K. SD 5/E100
K3	HALO COMMERCIAL LITHONIA	GFLM40FSUNVDBZK	4,000	BLACK	WALL MOUNT SEE PLANS FOR HEIGHT	LED FLOOD LIGHT POINTED AT THE FLAG. 4000K. SD 2/E100 AND 5/E100
J1	ACCLAIM	ESXF SERIES FLEXOS3 FLX MIN	250/FT	ALUMINUM	SD	LED TAPE LIGHT IN CHANNEL. INCLUDE ALL DRIVERS AND ACCESSORIES FOR A COMPLETE INSTALLATION.
	JESCO	FLEX2 SERIES				
N1	LUMENS	ARMIN CHANDELIER ELB2579277	4,000	BLACK	CEILING MOUNT	ARCHITECTURAL CHANDELIER PROVIDE LED EDISON BULBS WITH E26 BASE. 3000K.
N2	KUZCO	LUCIAN CH338836UBCC	4,000	BLACK	CEILING MOUNT	ARCHITECTURAL CHANDELIER PROVIDE LED EDISON BULBS WITH E12 BASE. 3000K.
N3	QUORUM OXYGEN	VIDA PENDANT 3-6203-22	2,000	OILED BRONZE	CEILING MOUNT	ARCHITECTURAL PENDANT PROVIDE LED MEDIUM A19 BULBS. 3000K.
T6	LITON	LTD8331B-B45-TS30	2,000	BLACK	NOTE 2	6' TRACK LIGHTING WITH TWO HEADS. 3000K. NOTE 3.
	JUNO	R610L SERIES				
T12	LITON	LTD8331B-B45-TS30	2,000	BLACK	NOTE 2	12' TRACK LIGHTING WITH THREE HEADS. 3000K. NOTE 3.
	JUNO	R610L SERIES				
T18	LITON	LTD8331B-B45-TS30	2,000	BLACK	NOTE 2	18' TRACK LIGHTING WITH FOUR HEADS. 3000K. NOTE 3.
	JUNO	R610L SERIES				
T30	LITON	LTD8331B-B45-TS30	2,000	BLACK	NOTE 2	30' TRACK LIGHTING WITH SIX HEADS. 3000K. NOTE 3.
	JUNO	R610L SERIES				
T36	LITON	LTD8331B-B45-TS30	2,000	BLACK	NOTE 2	36' TRACK LIGHTING WITH EIGHT HEADS. 3000K. NOTE 3.
	JUNO	R610L SERIES				
T44	LITON	LTD8331B-B45-TS30	2,000	BLACK	NOTE 2	44' TRACK LIGHTING WITH ELEVEN HEADS. 3000K. NOTE 3.
	JUNO	R610L SERIES				
T48	LITON	LTD8331B-B45-TS30	2,000	BLACK	NOTE 2	48' TRACK LIGHTING WITH TWELVE HEADS. 3000K. NOTE 3.
	JUNO	R610L SERIES				
TSPR	LITON	LTD8331B-B45-TS30 LTD8331B-B45-TS30-2C2N R610L SERIES	2,000	BLACK	N/A	PROVIDE SIX (6) SPARE HEADS.
CF1	RPLIGHTING	ALDEA VII 10670B-OB WC-4WH	N/A	BRONZE	SD 3/E100	56" CEILING FAN WITH WALL CONTROLLER STATION. NOTE 4.

NOTES:

1. WALL MOUNT DIRECTLY ABOVE EXIT DOOR WHERE POSSIBLE. CEILING OR END MOUNT IN REMAINING LOCATIONS AS DICTATED BY BUILDING CONDITIONS.
2. ATTACH THE TRACK TO STRUCTURE AND PROVIDE INTERMEDIATE SUPPORT AS REQUIRED.
3. PROVIDE ALL TRACK CONNECTORS AND PIECES AS REQUIRED FOR A COMPLETE INSTALLATION.
4. ONLY ONE WALL CONTROL STATION TO BE PROVIDE AND INSTALLED FOR EACH ROOM.

DRAWING HISTORY

NO.	DESCRIPTION	DATE
1	Construction Documents	08-13-26
2	Addendum #1	08-21-26

DRAWN BY: TCK

JN: PE 25062

Legends and Details

SHEET

E000